


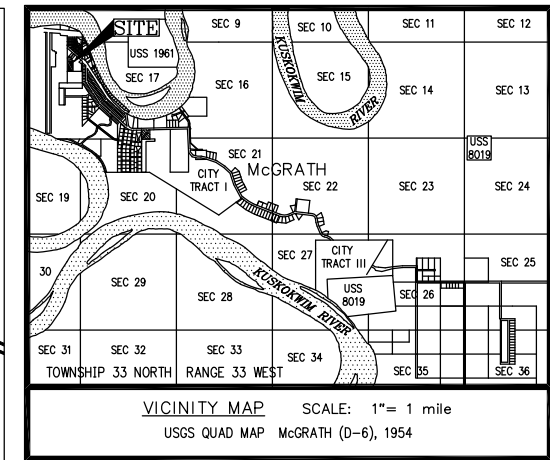

The station is located along the east side of McGrath, Alaska at McGrath Airport. The Airport is unrestricted. Contact the Airport Manager a minimum of 48 hours prior to entry. To reach the station from the airport main terminal, proceed northwest 0.09 miles across the apron to a point on the north edge of apron and 125 feet east of the T/W -A- Hold line. Turn right and proceed northerly 467 feet across small aircraft parking, parallel to R/W I6-34, and to the station on the right. The station is a standard CGS Azimuth Mark brass disc stamped: MCGRATH NW BASE 1951

Horizontal Control
Coordinate System:
This project is a local surface grid coordinate system expressed in U.S. Survey feet.
Horizontal data obtained from existing survey of Lots 1 and 2 MTNT SUBDIVISION, done
by McClintock Land Associates, Inc. dated 8-08-05.

NOTES:

I. Whether listed or not, all monuments or property markers, corners, or accessories, which will be disturbed or buried, shall be referenced or re-established in their original position (A.S. 19.10.260) and recorded (A.S. 34.65.040).

Set	Found
	BRASS CAP
	ALCAP
	CONTROL MONUMENT (PUBLISHED)
	GPS CONTROL (LAT. LONG)
	IRON PIPE
	REBAR
	SPIKE
	PK OR MAG NAIL
	TBM
	HUB

Control Point Number

STATE OF ALASKA
4912
Michael L. Jokela
No. LS-7839
04-20-08
ALASKA PROFESSIONAL LAND SURVEYOR

**ALASKA NATIVE TRIBAL
HEALTH CONSORTIUM**

**DIVISION OF ENVIRONMENTAL
HEALTH AND ENGINEERING**

1901 Bragaw Street, Suite 200
ANCHORAGE, ALASKA, 99508-3440
(907) 729-3600



McGRATH SUB-REGIONAL HEALTH CENTER SURVEY CONTROL 100% DESIGN DRAWINGS	
DATE: APRIL 2009	PROJ MGR: TD
DRAWN BY: TSN	PROJ SURV: MS
CHECKED BY: MS	TUS ENG:
FILE: MCG-V-STCNTL	LAYOUT: V-101

CIVIL/SURVEY LEGEND

SYMBOLS

Water

Proposed	Existing	
		FIRE HYDRANT
		WATER VALVE
		WATER KEY BOX
		AIR RELIEF VALVE
		BLOW OFF VALVE
		WELL

Electric & Telephone Communication

	LIGHT POLE
	UTILITY POLE
	ELECTRIC PED
	ELECTRIC METER
	GUY ANCHOR
	GUY POLE
	ELECTRICAL TRANSFORMER
	THERMISTOR
	TELEPHONE PED
	TELEPHONE BOOTH
	CABLE PED
	SATELLITE DISH

Sanitary Sewer


Proposed	Existing	
		SEWER MANHOLE
		SEWER CLEANOUT
		SEPTIC VENT
		SEPTIC CLEANOUT (MONITOR TUBE)
		SEWAGE LIFT STATION
		RESIDENTIAL EFFLUENT PUMP STATION

Survey

Set	Found
	 BRASS CAP (3 3/4")
	 BRASS CAP (3 1 1/4")
	 ALCAP
	 CONTROL MONUMENT (PUBLISHED)
	 GPS CONTROL (LAT. LONG)
	 IRON PIPE
	 REBAR
	 SPIKE
	 PK OR MAG NAIL
	 TBM
	 HUB

Miscellaneous

	TEST PIT
	SOILS BORE
	SIGN/PRIVATE
	SIGN/TRAFFIC
	BOLLARD
	GATE POST
	FLAG POLE

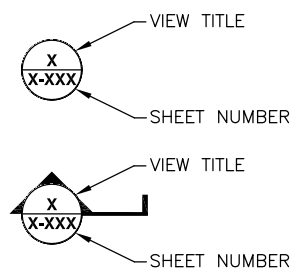

DETAIL LEGEND

SITE PLAN

EXISTING

	STRUCTURES
	ROADS (PAVED)
	ROADS (UNPAVED)
	PROPERTY LINE
	COMMUNICATIONS LINE
	POWER LINE
	SEWER SERVICE LINE
	WATER SERVICE LINE
	SEWER LINE
	WATER LINE
	FORCE MAIN
	FENCE
	UTILIDOR
	RAILROAD
	CONTOUR

PROPOSED

C

P

SS

WS

S

W

 
FM

X


UT

— 340 —

CONCRETE, 4" THICK



CONCRETE, 6" THICK

 AGGREGATE BASE COURSE

PREPARED SUBGRADE

SUBBASE MATERIALUNCLASSIFIED MATERIALTOPSOIL

ROCK LINE DITCH



COMMON ABBREVIATIONS

ABS	ACRYLONITRILE BUTADIENE STYRENE	INV	INVERT
ALUM	ALUMINUM	LS	LIFT STATION
AS	ASPHALT	LF	LINEAR FEET
AWH	AUTOMATIC WATER HEATER	MH	MANHOLE
BC	BOTTOM OF CURB	MAX	MAXIMUM
BOT	BOTTOM	MIN	MINIMUM
CL	CENTERLINE	NFS	NON—FROST SUSCEPTIBLE
CO	CLEANOUT	N.C.	NORMALLY CLOSED
CONC	CONCRETE	N.O.	NORMALLY OPEN
LNK	CHAIN LINK	N	NORTH
CW	COLD WATER	NTS	NOT TO SCALE
CON	CONCRETE	NO	NUMBER
CMP	CORRUGATED METAL PIPE	OS	OFFSET
DIA	DIAMETER	OD	OUTSIDE DIAMETER
DWG	DRAWING	PSI	POUNDS PER SQUARE INCH
E	EAST	PP	POWER POLE
ELL	90° ELBOW	PT	PRESSURE TANK
EL	ELEVATION	REQ'D	REQUIRED
EQUIL	EQUIVALENT	REPS	RESIDENTIAL EFFLUENT PUMPING STATION
FT	FEET, FOOT	SIM	SIMILAR
FF	FINISHED FLOOR	S	SOUTH
FH	FIRE HYDRANT	SAS	SOIL ABSORPTION SYSTEM
FLG	FLANGE	SS	STAINLESS STEEL
FM	FORCE MAIN	STA	STATION
FND	FOUND	STL	STEEL
GA	GAGE	TC	TOP OF CURB
GALV	GALVANIZED	TW	TREATED WATER
GB	GRADE BREAK	TYP	TYPICAL
GRV	GRAVEL	U.O.N.	UNLESS OTHERWISE NOTED
HGR	HEATED GLYCOL RETURN	WWTF	WASTE WATER TREATMENT FACILITY
HGS	HEATED GLYCOL SUPPLY	WTP	WATER TREATMENT PLANT
HDPE	HIGH DENSITY POLYETHYLENE	WST	WATER STORAGE TANK
HP	HORSEPOWER	W	WEST
HB	HOSE BIBB	WD	WOOD
HW	HOT WATER		
ID	INSIDE DIAMETER		
INT	INTERSECTION		

CALL BEFORE YOU DIG!!!	
Locate Call Center of Alaska, Inc.	Statewide 800-478-3121
Alaska Railroad	265-2520
Military Fuel Lines	552-3760
State Storm Drains	333-2411
City of McGrath	524-3391

[illegible]

ALASKA NATIVE TRIBAL
HEALTH CONSORTIUM

DIVISION OF ENVIRONMENTAL
HEALTH AND ENGINEERING


1901 Bragaw Street, Suite 200
ANCHORAGE, ALASKA, 99508-3440
(907) 729-3600



DATE: APRIL 2009	PROJ MGR: TD
DRAWN BY: TSN	PROJ ENG: MS
CHECKED BY: MS	TUS ENG:
FILE: MCG-C-STLND	LAYOUT: C-001

C-001
SHEET **1** OF **13**

USER: TNGRO FILE: J:\08SDATA\30303.05 MCGRATH HEALTH CENTER\00 CADD\01 WORKING SET\01 CIVIL\MCG-C-STSITE1.DWG PLOT DATE: 4/20/2009 10:14 AM

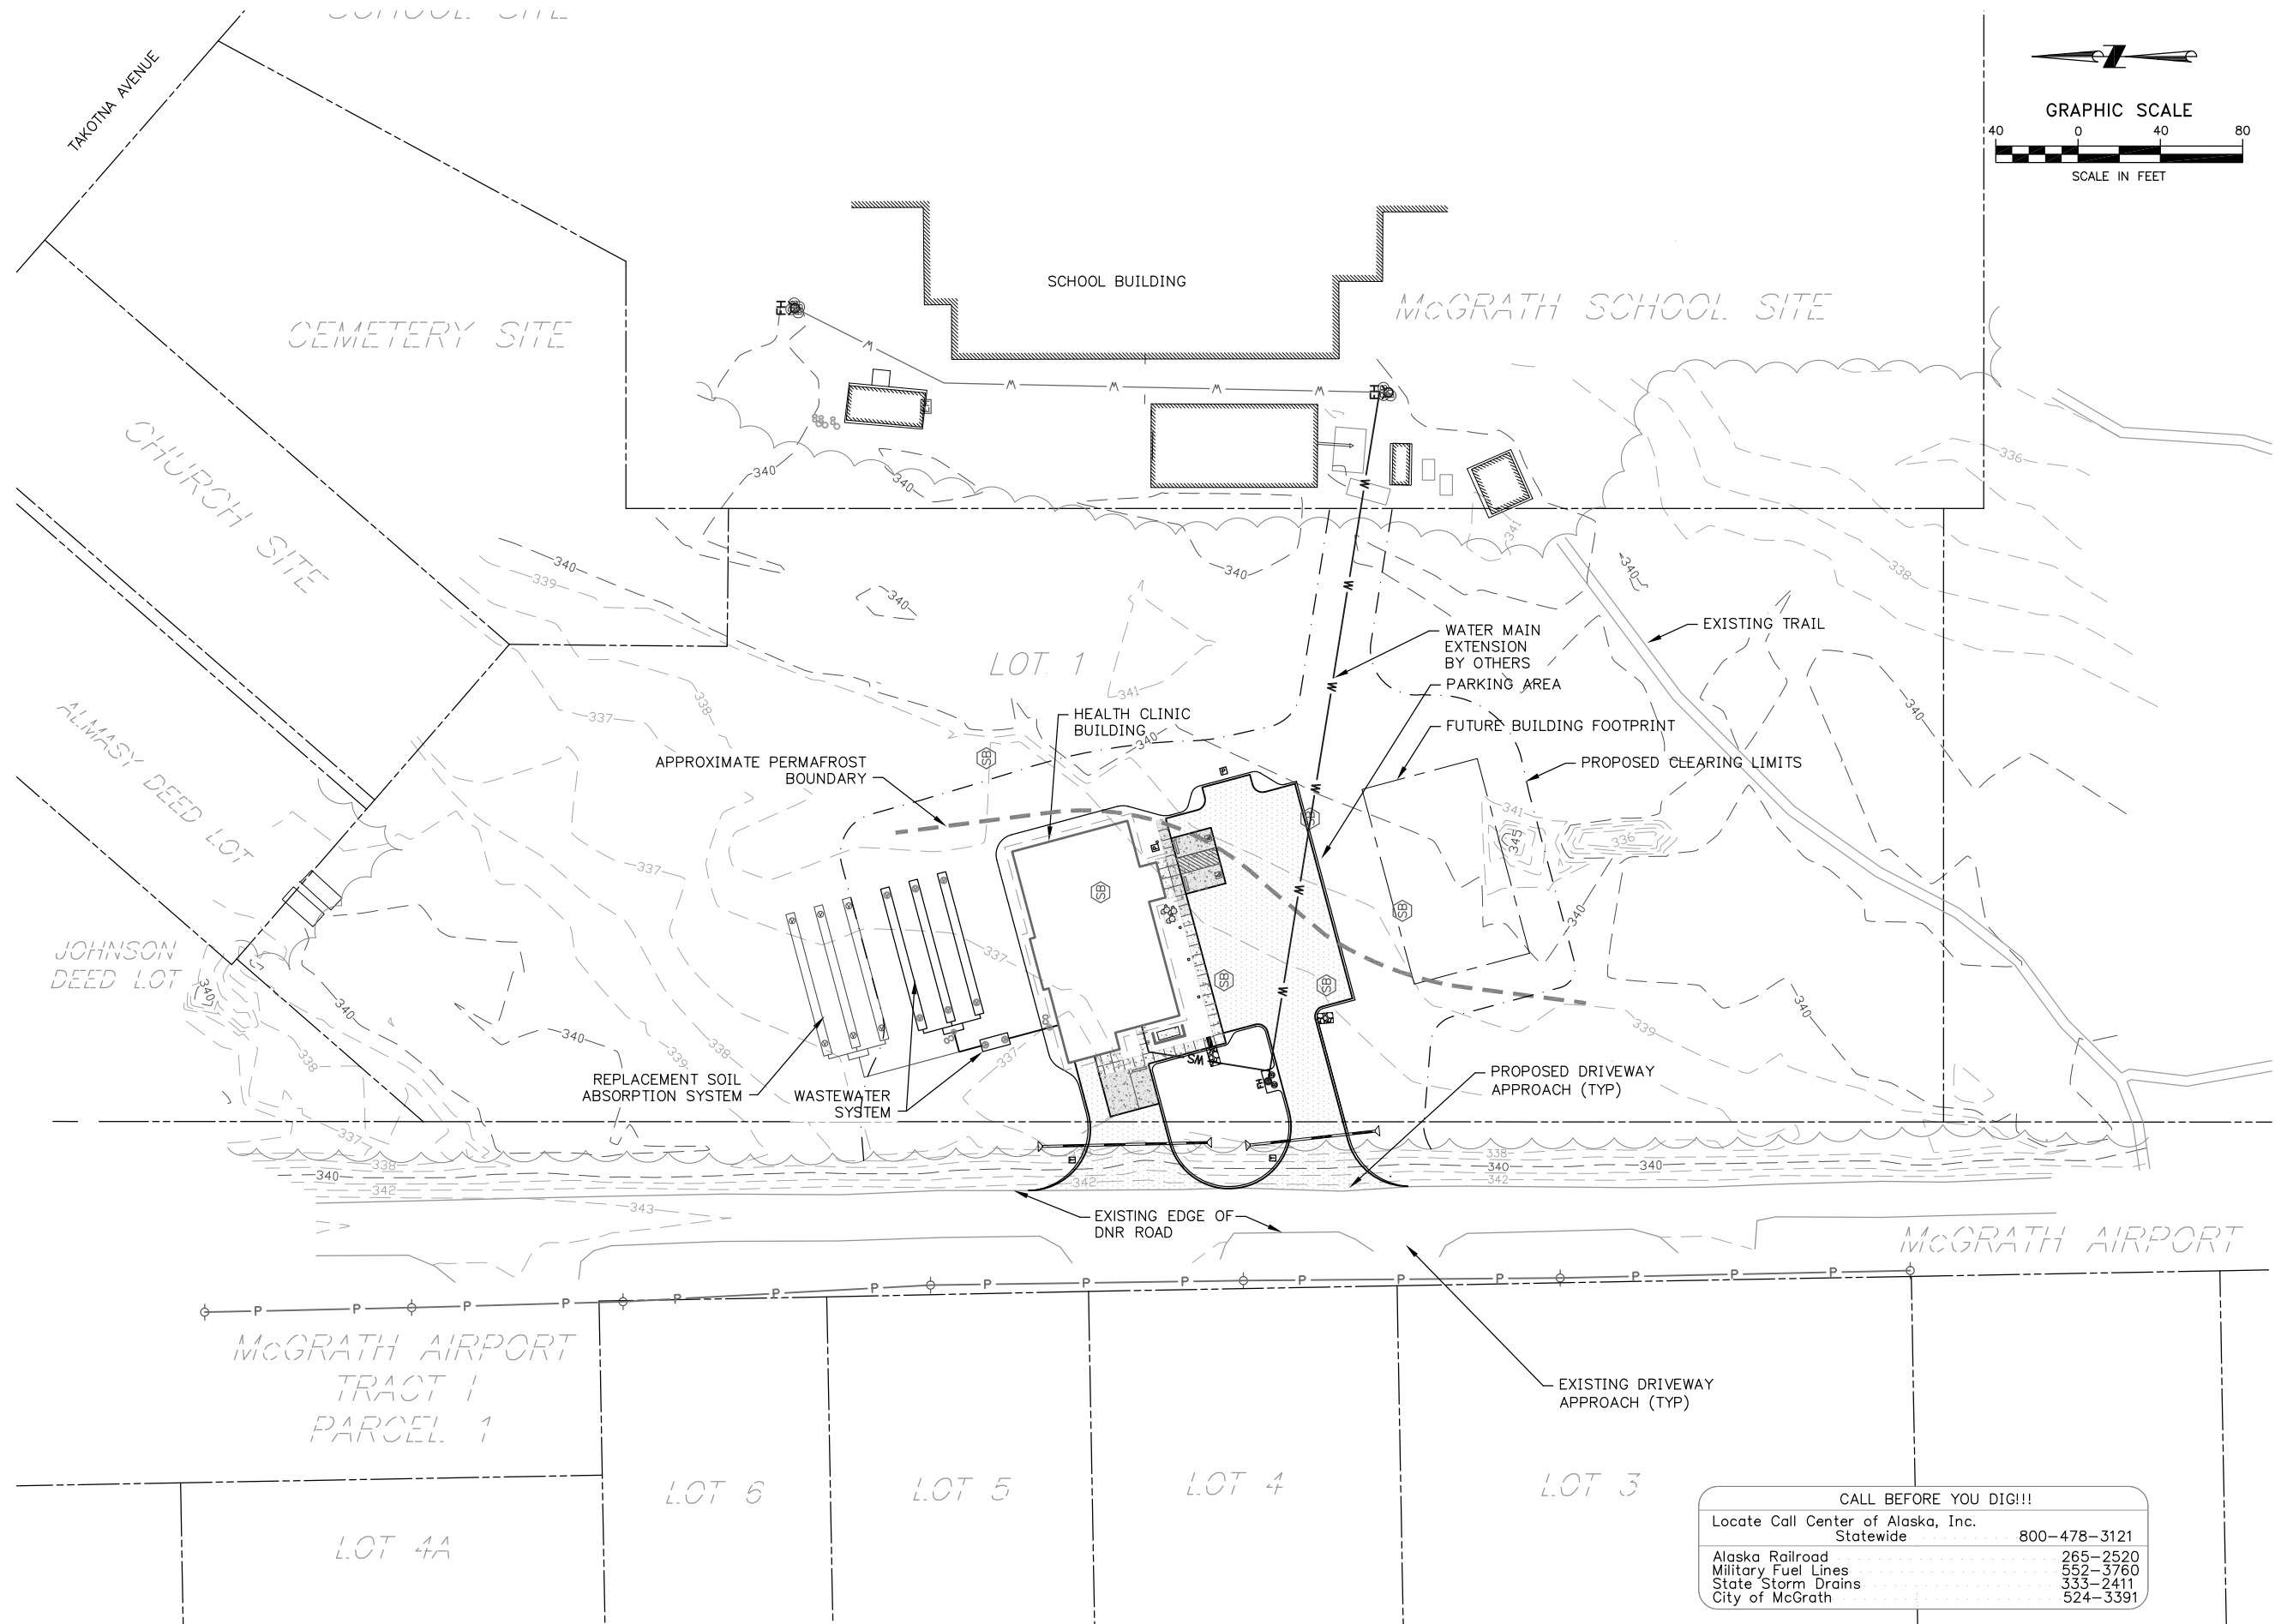

1 OVERALL SITE PLAN
Scale: 1" = 40'

CALL BEFORE YOU DIG!!!	
Locate Call Center of Alaska, Inc.	
Statewide	800-478-3121
Alaska Railroad	265-2520
Military Fuel Lines	552-3760
State Storm Drains	333-2411
City of McGrath	524-3391


DATE	REVISIONS	INIT



ALASKA NATIVE TRIBAL
HEALTH CONSORTIUM
DIVISION OF ENVIRONMENTAL
HEALTH AND ENGINEERING
1901 Bragaw Street, Suite 200
ANCHORAGE, ALASKA 99508-3440
(907) 729-3600



McGRATH SUB-REGIONAL HEALTH CENTER OVERALL SITE PLAN 100% DESIGN DRAWINGS	
DATE: APRIL 2009	PROJ MGR: TD
DRAWN BY: TSN	PROJ ENG: MS
CHECKED BY: MS	TUS ENG: MS
FILE: MCG-C-STSITE1	LAYOUT: C-101

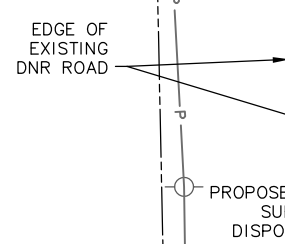

MATCH EXISTING
ROAD (TYP)

1. APPROXIMATE PERMAFROST BOUNDARY LINE TAKEN FROM GEOTECHNICAL REPORT TITLED, "MCGRATH HEALTH CENTER, MCGRATH ALASKA" DATED JANUARY 2009..
2. THE WATER MAIN, WATER SERVICE AND FIRE HYDRANT WILL BE INSTALLED BY THE CITY OF MCGRATH PUBLIC WORKS DEPARTMENT. THE CONTRACTOR SHALL COORDINATE WITH THE CITY OF MCGRATH FOR THE INSTALLATION AND ACCESS OF THIS UTILITY DURING CONSTRUCTION.
3. LOT CONTAINS 20 PARKING STALLS. TYPICAL PARKING STALL DIMENSIONS SHALL BE 10X20'. FOUR ACCESSIBLE LOADING/UNLOADING ZONES ARE INCLUDED IN THIS PARKING LOT; TWO OF THESE FOUR SHALL BE CONSTRUCTED THIS PROJECT.
4. REMOVE ALL ORGANIC MATERIAL BELOW FILL MATERIAL FOOTPRINT.
5. MATCH INVERT OF THE ROCK LINED DITCH TO THE FLOW PATH OF RUNOFF.

• SPECIAL SIGN SEE 1/C-502



MASS EARTHWORK QUANTITIES NOTES:

1. VOLUME CALCULATIONS ASSUME 18 INCHES OF ORGANIC AND UNCLASSIFIED MATERIAL BELOW DRIVEWAY, PARKING LOT AND BUILDING PAD FILL WILL BE EXCAVATED. OTHER DISTURBED AREAS WILL ONLY REMOVE 6 INCHES OF ORGANIC MATERIAL.
2. THE EARTHWORK VOLUMES PRESENTED ON THIS SHEET ARE APPROXIMATE AND SHOULD NOT BE USED FOR BIDDING PURPOSES. IT IS THE CONTRACTOR'S RESPONSIBILITY TO CALCULATE ALL EARTHWORK VOLUMES FOR REQUIRED MATERIAL VOLUMES.



ALASKA NATIVE TRIBAL
HEALTH CONSORTIUM

DIVISION OF ENVIRONMENTAL
HEALTH AND ENGINEERING

1901 Bragaw Street, Suite 200
ANCHORAGE, ALASKA, 99508-3440
(907) 729-3600



McGRATH SUB-REGIONAL
HEALTH CENTER
DETAILED SITE PLAN

DATE: APRIL 2009	PROJ MGR: TD
DRAWN BY: TSN	PROJ ENG: MS
CHECKED BY: MS	TUS ENG:
FILE: MCG-C-SITE2	LAYOUT: C-102

USER: TNGRO FILE: J:\06SDATA\30303.05 MCGRATH HEALTH CENTER\00 CADD\01 WORKING SET\01 CIVIL\MCG-C-STHZCONTROL.DWG PLOT DATE: 4/20/2009 10:36 AM

WASTEWATER SYSTEM		
POINT NUMBER	NORTHING	EASTING
101	53330.25	197283.92
102	53354.40	197277.45
103	53367.82	197273.85
104	53378.55	197270.98
105	53368.18	197287.34
106	53381.95	197283.64
107	53395.71	197279.95


BUILDING		
POINT NUMBER	NORTHING	EASTING
301	53325.32	197265.57
302	53335.03	197301.79
303	53337.61	197301.10
304	53344.24	197325.86
305	53341.66	197326.55
306	53352.85	197368.28
307	53296.82	197383.30
308	53290.83	197360.92
309	53282.78	197363.07
310	53278.20	197346.01
311	53286.25	197343.85
312	53271.46	197288.63
313	53302.69	197280.27
314	53300.54	197272.23

NOTES:
1. TO OUTSIDE FINISH FACE OF BUILDING

DRIVEWAY AND PARKING		
POINT NUMBER	NORTHING	EASTING
401	53160.57	197205.64
402	53189.61	197227.87
403	53205.44	197286.94
404	53201.90	197293.04
405	53187.41	197296.92
406	53215.36	197401.24
407	53229.85	197397.36
408	53235.97	197400.90
409	53237.27	197405.72
410	53260.45	197399.51
411	53259.16	197394.68
412	53262.69	197388.56
413	53278.14	197384.42
414	53275.56	197374.76
415	53256.24	197379.94
416	53248.99	197352.89
417	53268.31	197347.72
418	53250.19	197280.10
419	53234.74	197284.24
420	53228.61	197280.71

DRIVEWAY AND PARKING		
POINT NUMBER	NORTHING	EASTING
421	53218.30	197242.23
422	53246.48	197204.47
423	53276.36	197227.08
424	53281.38	197245.81
425	53286.55	197265.13
426	53310.14	197258.80
427	53304.96	197239.48
428	53312.85	197268.92
429	53322.51	197266.33
430	53315.80	197241.29
431	53344.80	197203.53

WATER SYSTEM		
POINT NUMBER	NORTHING	EASTING
201	53174.26	197591.64
202	53227.59	197261.63
203	53228.39	197256.70
204	53286.46	197270.98
205	53289.86	197283.70

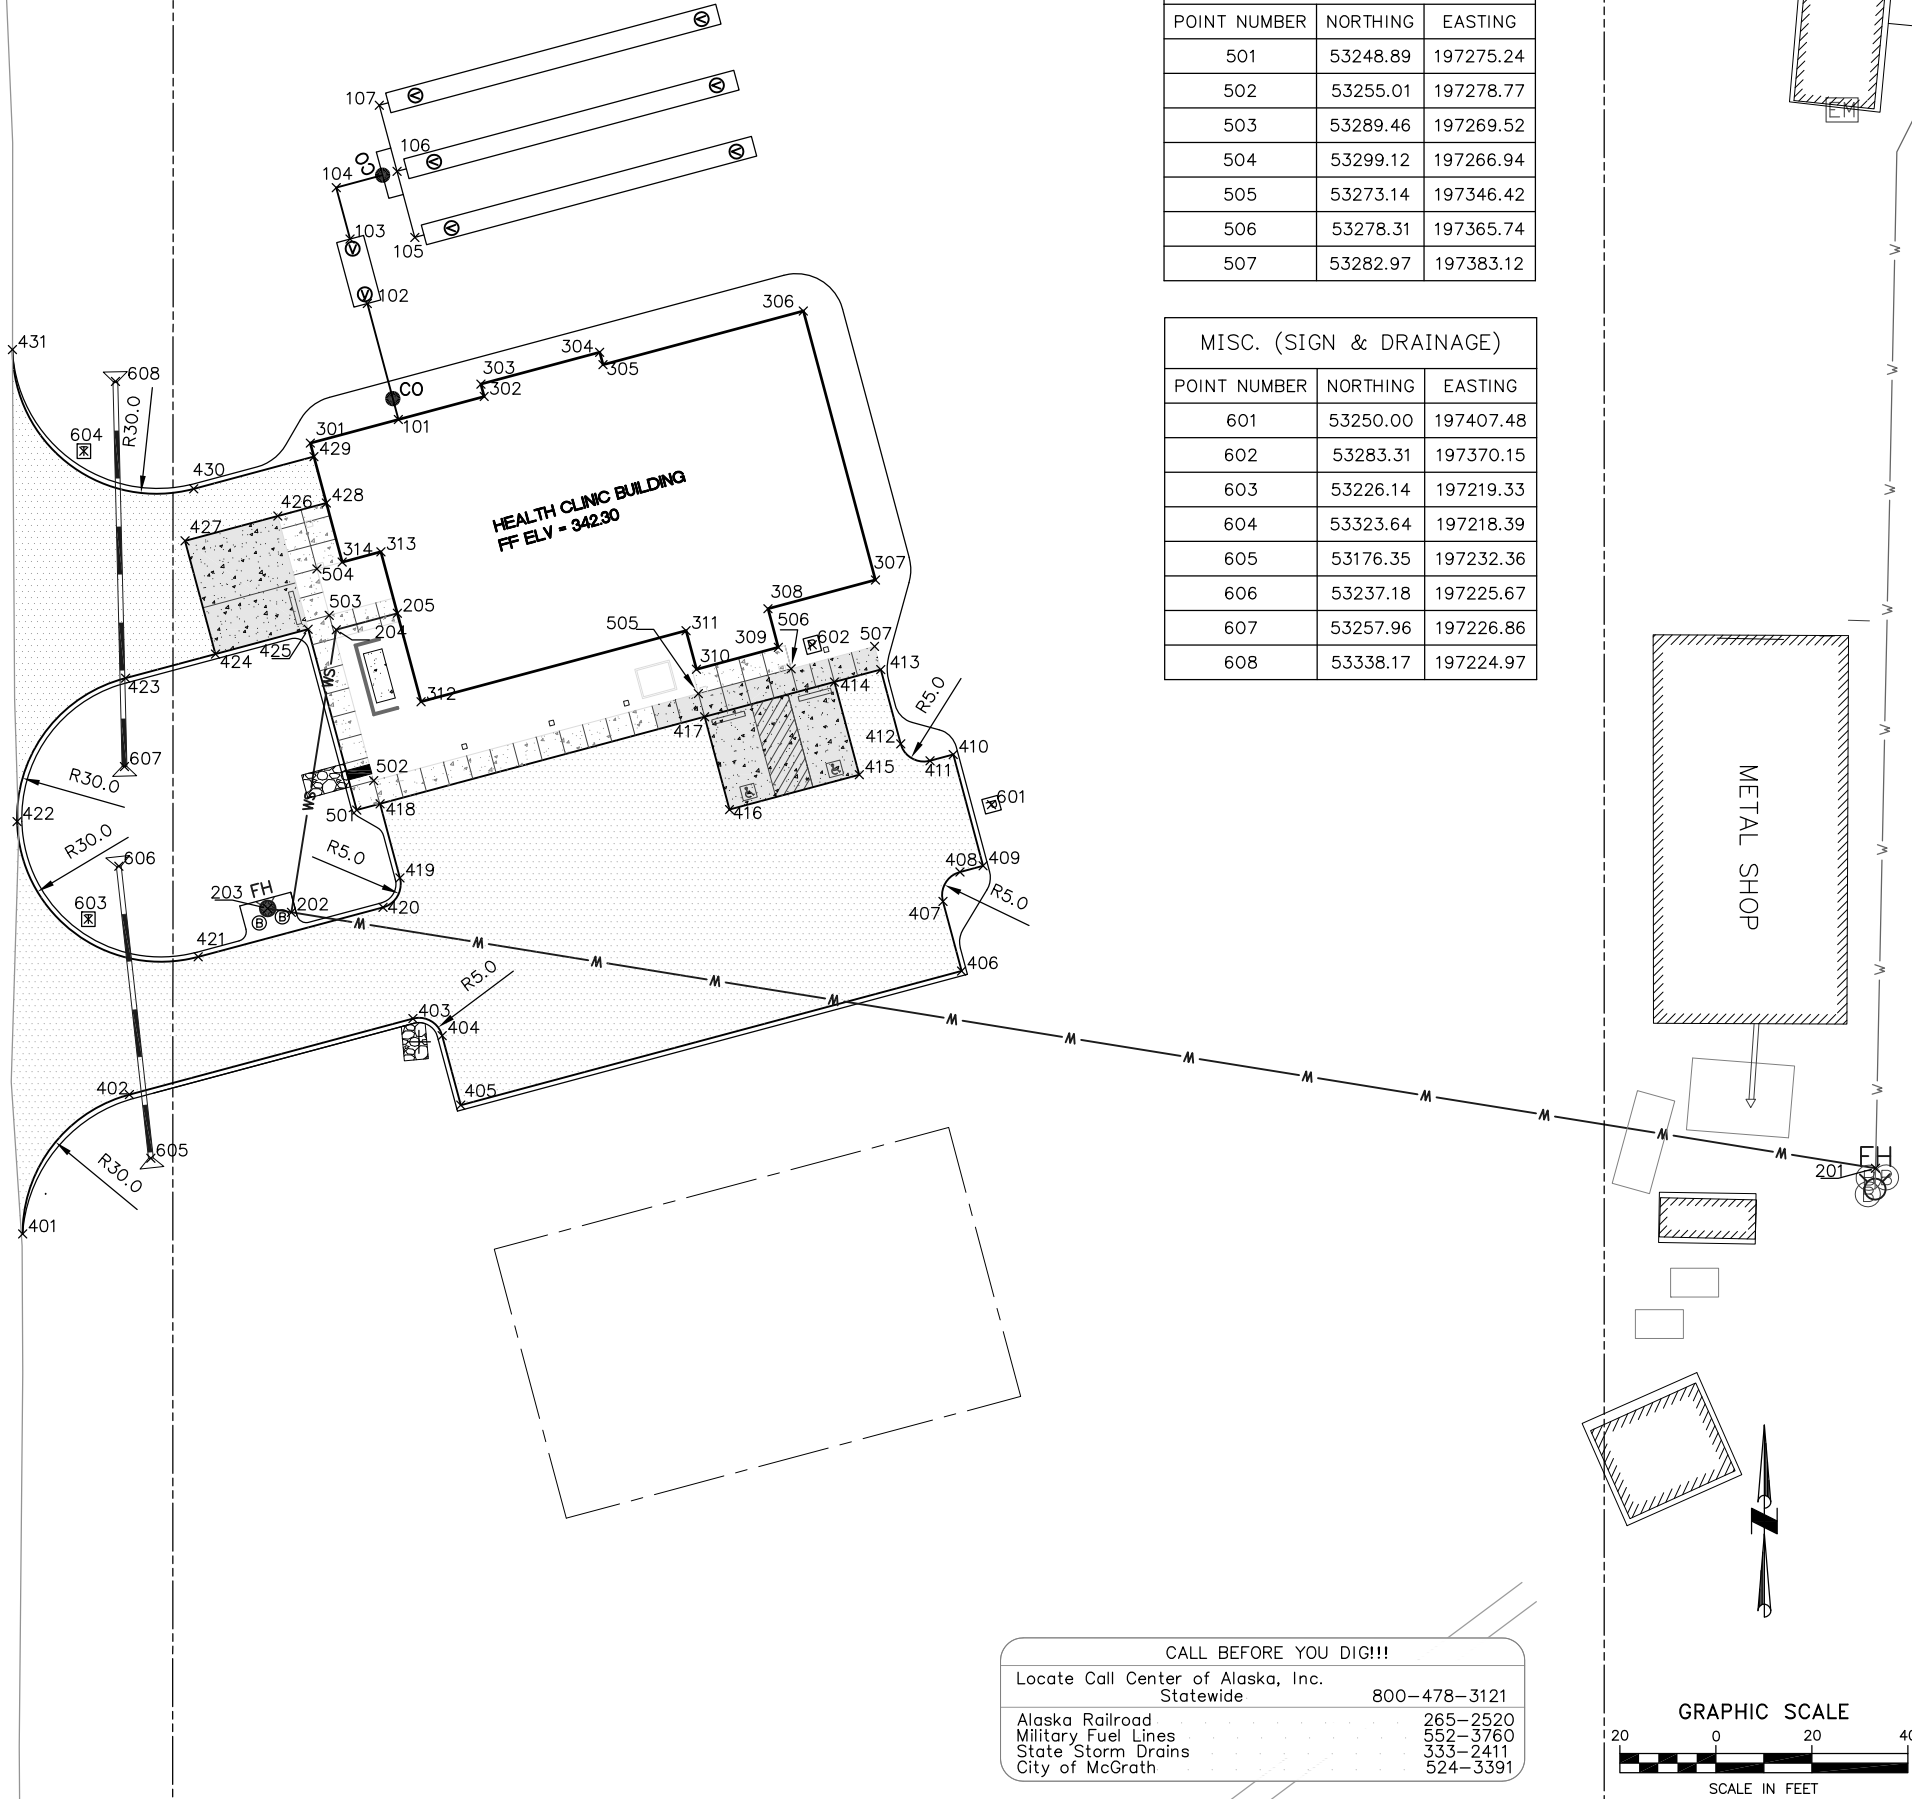

CONCRETE WALKWAY		
POINT NUMBER	NORTHING	EASTING
501	53248.89	197275.24
502	53255.01	197278.77
503	53289.46	197269.52
504	53299.12	197266.94
505	53273.14	197346.42
506	53278.31	197365.74
507	53282.97	197383.12

MISC. (SIGN & DRAINAGE)		
POINT NUMBER	NORTHING	EASTING
601	53250.00	197407.48
602	53283.31	197370.15
603	53226.14	197219.33
604	53323.64	197218.39
605	53176.35	197232.36
606	53237.18	197225.67
607	53257.96	197226.86
608	53338.17	197224.97




ALASKA NATIVE TRIBAL
HEALTH CONSORTIUM
DIVISION OF ENVIRONMENTAL
HEALTH AND ENGINEERING
1901 Bragaw Street, Suite 200
ANCHORAGE, ALASKA 99508-3440
(907) 729-3600



McGRATH SUB-REGIONAL
HEALTH CENTER
HORIZONTAL CONTROL
100% DESIGN DRAWINGS
DATE: APRIL 2009
DRAWN BY: TSN
CHECKED BY: MS
FILE: MCG-C-STHZCONTROL
PROJ MGR: TD
PROJ ENG: MS
TUS ENG: MS
LAYOUT: C-105

C-105
SHEET 6 OF 13

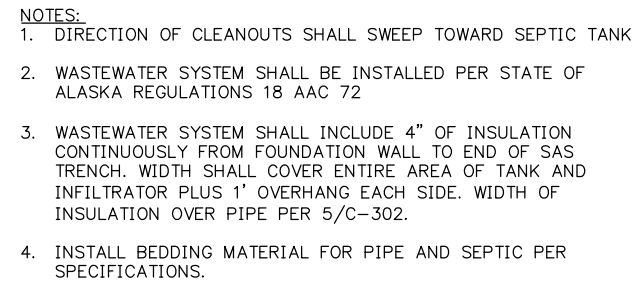


ALASKA NATIVE TRIBAL
HEALTH CONSORTIUM

DIVISION OF ENVIRONMENTAL
HEALTH AND ENGINEERING


1901 Braagaw Street, Suite 200
ANCHORAGE, ALASKA, 99508-3440
(907) 729-3600




McGRATH SUB-REGIONAL HEALTH CENTER ONSITE WASTEWATER SYSTEM PLAN AND PROFILE 100% DESIGN DRAWINGS	
DATE: APRIL 2009	PROJ MGR: TD
DRAWN BY: TSN	PROJ ENG: MS
CHECKED BY: MS	TUS ENG:
FILE: MCG-C-STLSV	LAYOUT: C-301

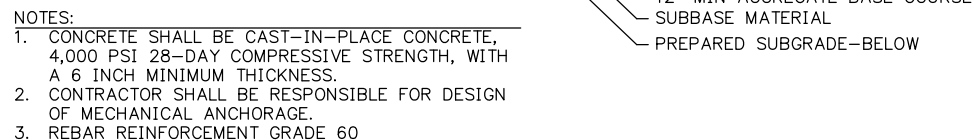


Scale: NTS

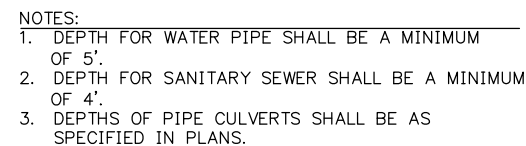

Scale: NTS

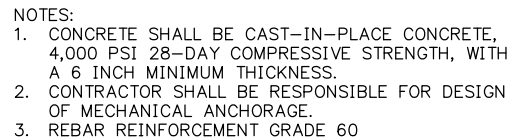


Scale: NTS

 


Scale: NTS

C-302
SHEET **8** OF **13**

USER: TNGRO FILE: J:\005DATA\30303.05 MCGRATH HEALTH CENTER\00 CADD\01 WORKING SET\01 CIVIL\MCG-C-STLSV.DWG PLOT DATE: 4/20/2009 10:49 AM

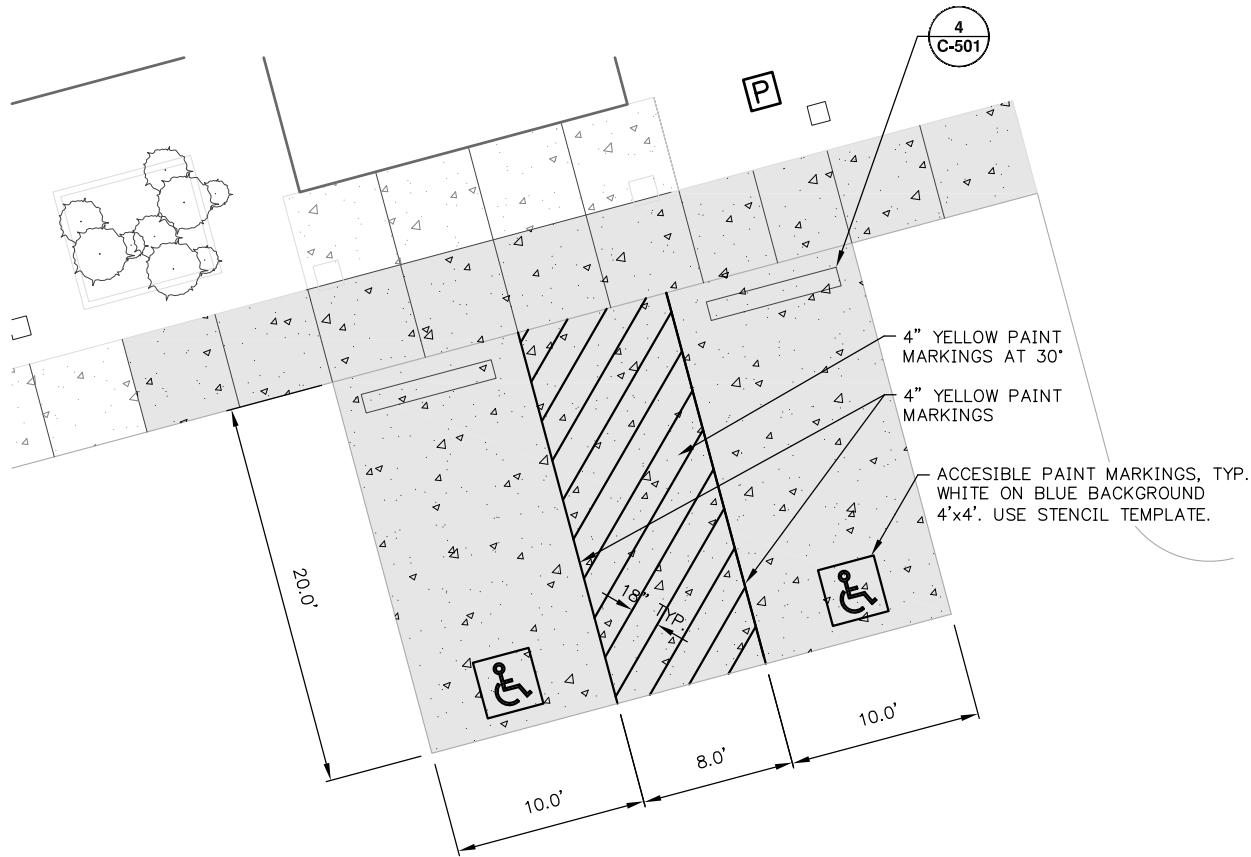


A PAINT MARKINGS DETAIL
Scale: 1"=5'

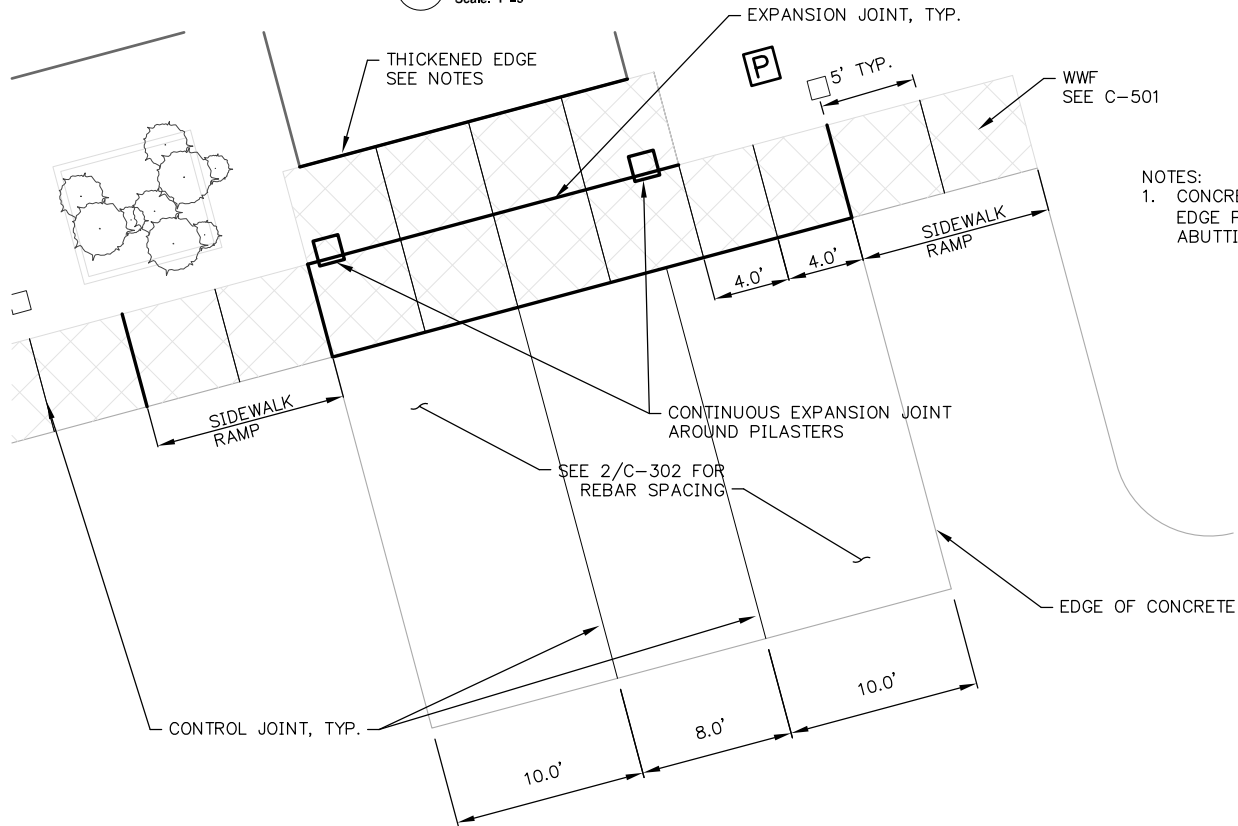


B CONCRETE JOINT DETAIL
Scale: 1"=5'

1 HANDICAP PARKING CONCRETE PAD DETAILS
Scale: SEE DETAIL

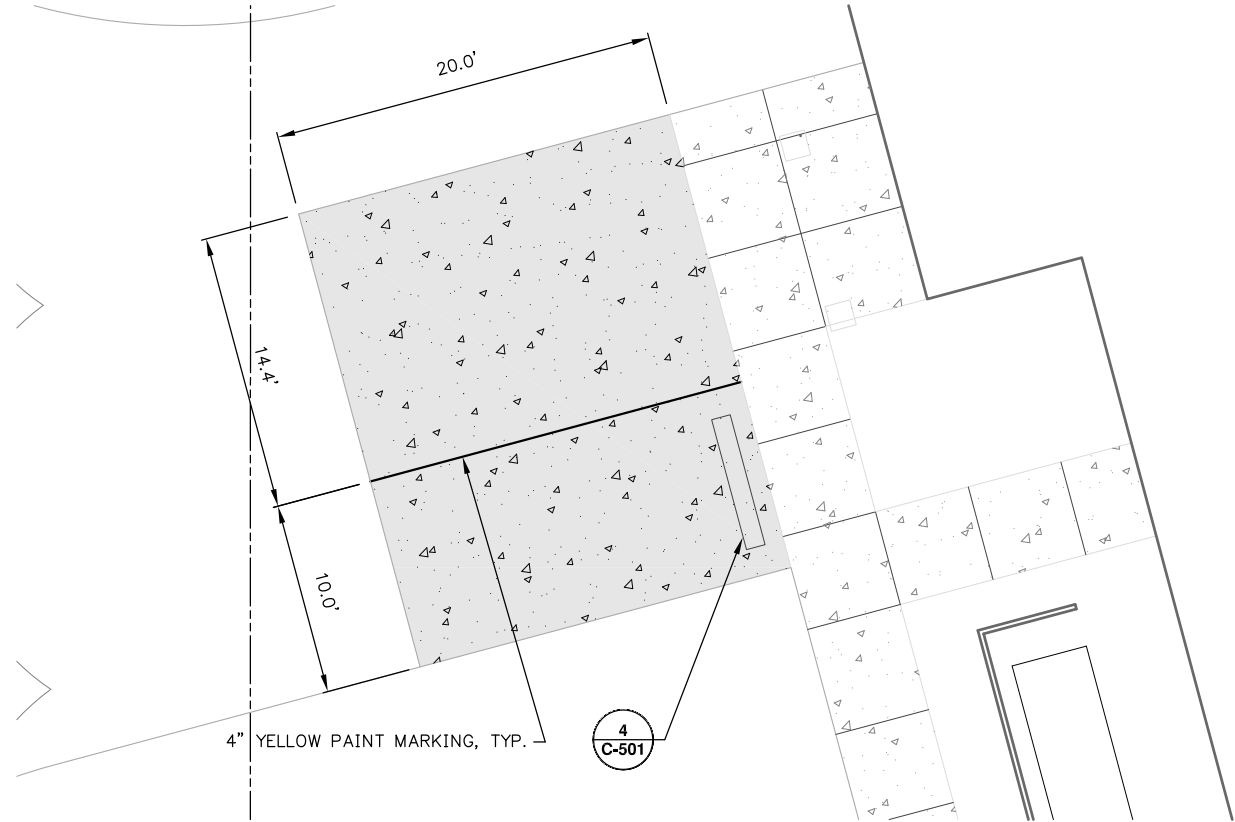

A PAINT MARKINGS DETAIL
Scale: 1"=5'

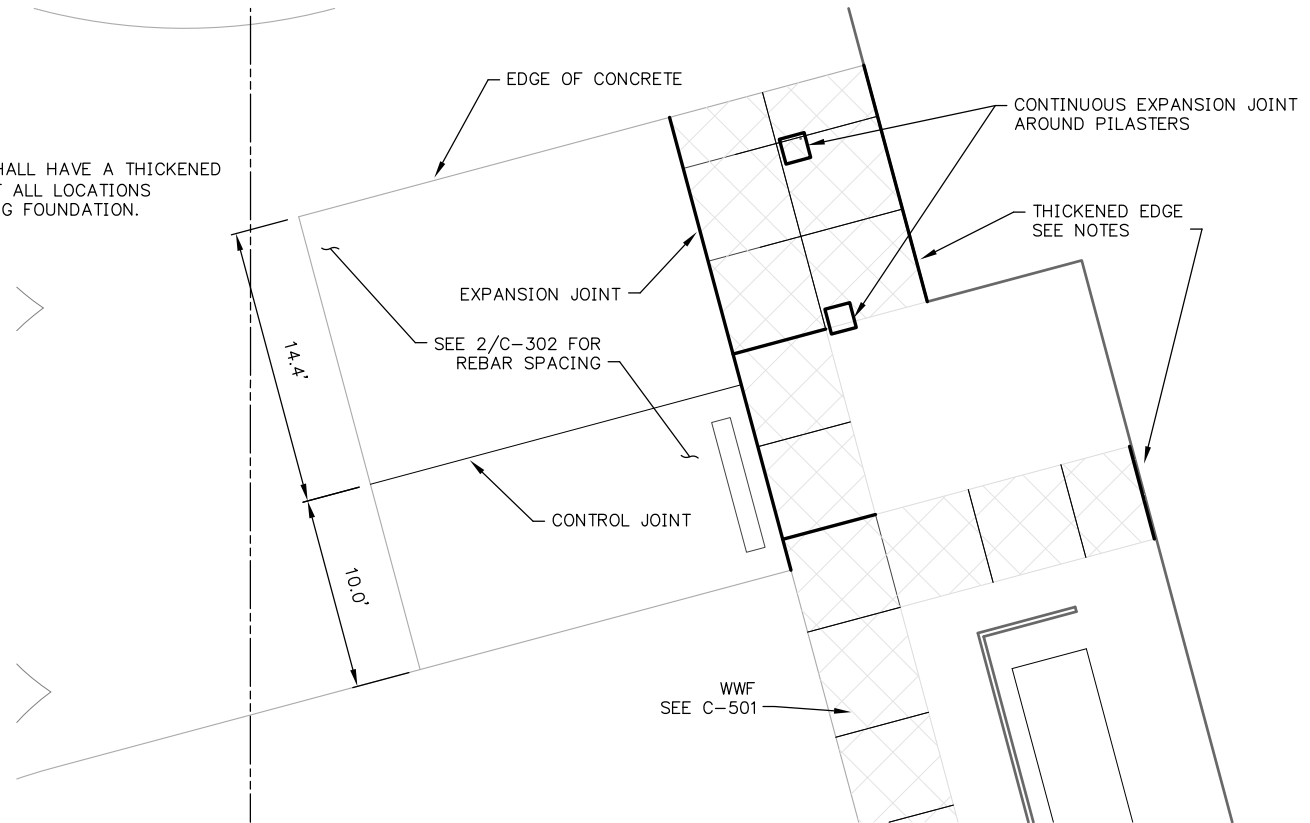

B CONCRETE JOINT DETAIL
Scale: 1"=5'

2 EMERGENCY VEHICLE PARKING CONCRETE PAD DETAILS
Scale: SEE DETAIL



ALASKA NATIVE TRIBAL
HEALTH CONSORTIUM
DIVISION OF ENVIRONMENTAL
HEALTH AND ENGINEERING
1901 Bragaw Street, Suite 200
ANCHORAGE, ALASKA 99508-3440
(907) 729-3600


 


MCGRATH SUB-REGIONAL
HEALTH CENTER
CONCRETE PARKING PAD DETAILS
100% DESIGN DRAWINGS
DATE: APRIL 2009
DRAWN BY: JSN
CHECKED BY: MS
FILE: MCG-C-STLSV
PROJ MGR: TD
PROJ ENG: MS
TUS ENG: MS
LAYOUT: C-401


C-401
SHEET 10 OF 13



C-501
SHEET **11** OF **13**

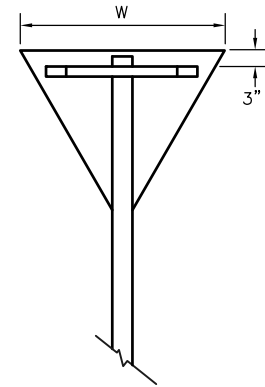

3 SIGN BRACING PLACEMENT

 

5 TUBE POST SIGN BRACING

Scale: NTS

5 TUBE POST SIGN BRACING
Scale: NTS

[illegible]

ALASKA NATIVE TRIBAL
HEALTH CONSORTIUM

DIVISION OF ENVIRONMENTAL
HEALTH AND ENGINEERING

1901 Bowdoin Street, Suite 200
ANCHORAGE, ALASKA 99508-3440
(907) 729-3600




McGRATH SUB-REGIONAL HEALTH CENTER SIGN DETAILS 100% DESIGN DRAWINGS	
DATE: APRIL 2009	PROJ MGR: TD
DRAWN BY: TSN	PROJ ENG: MS
CHECKED BY: MS	TUS ENG:
FILE: MCG-C-DTGEN	LAYOUT: C-502

C-502
SHEET **12** OF **13**


USER: TNORD

NOTES:

 2. WIDTH OF DOOR MAY VARY SLIGHTLY DUE TO CONTRACTOR SELECTED DOOR HINGE AND THE SPACING REQUIRED FOR PROPER DOOR OPENING.




1

 


2

 Scale: NTS



A-A

 

(3)

Scale: NTS

ALASKA NATIVE TRIBAL
HEALTH CONSORTIUM

DIVISION OF ENVIRONMENTAL
HEALTH AND ENGINEERING

1901 Bragaw Street, Suite 200
ANCHORAGE, ALASKA, 99508-3440
(907) 729-3600



McGRATH SUB-REGIONAL HEALTH CENTER FENCE AND GATE DETAILS 100% DESIGN DRAWINGS	
DATE: APRIL 2009	PROJ MGR: TD
DRAWN BY: TSN	PROJ ENG: MS
CHECKED BY: MS	TUS ENG:
FILE: MCG-C-DTGN	LAYOUT: C-503

C-503
SHEET **13** OF **13**


1 ABBREVIATIONS

"	INCH	CSK.	COUNTERSUNK	FLR.	FLOOR	MECH.	MECHANICAL	S.S.	SANITARY SEWER
#	NUMBER	CSMT.	CASEMENT	FLSH.	FLASHING	MEMB.	MEMBRANE	SAN.	SANITARY
&	AND	CTD.	COATED	FLUOR.	FLUORESCENT	MFG.	MANUFACTURE	SCHED.	SCHEDULED
@	AT	CTR.	CENTER	FRPF.	FIREPROOFING	MH.	MANHOLE	SD.	SIDE
<	ANGLE	CU.	CUBIC	FRT.	FIRE RETARDANT TREATED	MIN.	MINIMUM OR MINUTE	SDG.	SIDING
Ø	DIAMETER	CVR'G	COVERING	FT.	FOOT	MIR.	MIRROR	SECT.	SECTION
A.B.	ANCHOR BOLT	D.B.	DRAWER BANK	FTG.	FOOTING	MISC.	MISCELLANEOUS	SHEATH.	SHEATHING
A.C.T.	ACOUSTICAL CEILING TILE	D.F.	DRINKING FOUNTAIN	FURR.	FURRING	MTL.	MULLION	SHT.	SHEET
A.F.F.	ABOVE FINISH FLOOR	D.L.	DEAD LOAD	FUT.	FUTURE	MULL.	MULLION	SHWR.	SHOWER
ACOUS.	ACOUSTICAL	DBL.	DOUBLE	G.A.	GYPSUM ASSOCIATION	MWP.	MEMBRANE WATER PROOFING	SIM.	SIMILAR
ACT.	ACTUAL	DEMO.	DEMOLITION	G.B.	GRAB BAR	N	NORTH	SPEC.	SPECIFICATIONS.
ADD.	ADDITION OR ADDENDUM	DEPT.	DEPARTMENT	G.I.	GALVANIZED IRON	N.A.	NOT APPLICABLE	SPL.	SPECIAL
ADDN.	ADDITIONAL	DIA.	DIAMETER	G.W.B.	GYPSUM WALL BOARD	N.I.C.	NOT IN CONTRACT	SQ.	SQUARE
ALT.	ALTERNATE	DIAG.	DIAGONAL	GA.	GAUGE	N.T.S.	NOT TO SCALE	SQ. FT.	SQUARE FEET
ALUM.	ALUMINUM	DIFF.	DIFFUSER OR DIFFERENCE	GAL.	GALLON	NO.	NUMBER	SST.	STAINLESS STEEL
ANDD.	ANODIZED	DIM.	DIMENSION	GALV.	GALVANIZED	NOM.	NOMINAL	ST.S.	STORM SEWER
APPROX.	APPROXIMATE	DISP.	DISPENSER	GL.	GLASS	O.C.	ON CENTER	STA.	STATION
ARCH.	ARCHITECTURAL	DK.	DECK	GLB.	GLUE LAMINATED BEAM	O.H.	OVER HEAD	STD.	STANDARD
ASB.	ASBESTOS	DN.	DOWN	GOV'T.	GOVERNMENT	OFF.	OFFICE	STL.	STEEL
ASPH.	ASPHALT	DR.	DOOR	GR.	GRADE	OHD.	OVER HEAD DOOR	STOR.	STORAGE
AUTO. DR.	AUTOMATIC DOOR	DS.	DOWN SPOUT	GSP.	GALVANIZED STEEL PIPE	OPNG.	OPENING	STRUCT.	STRUCTURE
AVG.	AVERAGE	DTL.	DETAIL	GYM.	GYMNASIUM	OPP.	OPPOSITE	SUR.	SURFACE
B.C.	BASE CABINET	DWG.	DRAWING	GWB.	GYPSUM WALL BOARD	ORIG.	ORIGINAL	SUSP.	SUSPENDED
B.M.	BENCH MARK	E.	EAST	H.B.	HOSE BIB	P.I.A.M.	PLASTIC LAMINATE	SV.	SHEET VINYL
B.O.	BOTTOM OF	E.I.F.S.	EXT INSULATION & FINISH SYS	H.C.	HANDICAPPED	P.T.D.	PAPER TOWER DISPENSER	SYM.	SYMMETRICAL
B.S.	BOTH SIDES	E.S.	EACH SIDE	H.C.	HOLLOW CORE	PL.	PLASTER	T.&G.	TONGUE AND GROOVE
B.T.U.	BRITISH THERMAL UNIT	E.W.	EACH WAY	H.M.	HOLLOW METAL	PART.	PARTITION	T.B.	TACK BOARD
B.U.R.	BUILT-UP ROOFING	E.A.	EACH	H.M.F.	HOLLOW METAL FRAME	PL.	PLATE	T.I.	TENANT IMPROVEMENT
BK.	BACK	ELECT.	ELECTRICAL	H.P.	HIGH POINT	PLAST.	PLASTER	T.O.	TOP OF
BLDG.	BUILDING	ELEV.	ELEVATION	H.W.	HOT WATER	PLYWD.	PLYWOOD	T.O.C.	TOP OF CURB
BLK.	BLOCK	ENCL.	ENCLOSURE	HD.	HAND	PR.	PAIR	T.O.S.	TOP OF STEEL
BLKG.	BLOCKING	EQ.	EQUAL	HDWD.	HARDWOOD	PRE. ENG.	PREVIOUSLY ENGINEERED	TEL.	TELEPHONE
BM.	BEAM	EQUIP.	EQUIPMENT	HDWR.	HARDWARE	PREFAB.	PREFABRICATED	TEMP.	TEMPORARY
BOTT.	BOTTOM	EXIST.	EXISTING	HORIZ.	HORIZONTAL	PROJ.	PROJECT	TERR.	TERRAZZO
C TO C	CENTER TO CENTER	EXP.	EXPANSION	HR.	HOUR	PSF.	POUNDS PER SQUARE FOOT	THK.	THICK
C.B.	CATCH BASIN	EXP. AGG.	EXPOSED AGGREGATE	HT.	HEIGHT	PT.	POINT	THRU.	THROUGH
C.I.	CAST IRON	EXP. JT.	EXPANSION JOINT	HWY.	HIGHWAY	Q.T.	QUARRY TILE	TRANSV.	TRANSVERSE
C.I.P.	CAST IRON PIPE	EXT.	EXTERIOR	I.D.	INSIDE DIAMETER	R.	RISER	TS.	TUBE STEEL
C.J.	CONTROL JOINT	EXTR.	EXTRUDED	IN.	INCH	RCP	REFLECTED CEILING PLAN	TV.	TELEVISION
C.M.P.	CORRUGATED METAL PIPE	F TO F	FACE TO FACE	INCL.	INCLUDE	R.D.	ROOF DRAIN	TYP.	TYPICAL
C.M.U.	CONCRETE MASONRY UNITS	F.B.	FLAT BAR	INSUL.	INSULATE	R.H.	RIGHT HAND	U.L.	UNDERWRITERS LABORATORIES
C.R.	COLD ROLLED	F.D.	FLOOR DRAIN	INT.	INTERIOR	R.L.	RAIL LEADER	U.O.N.	UNLESS OTHERWISE NOTED
C.R.C.	COLD ROLLED CHANNEL	F.E.	FIRE EXTINGUISHER	JAN.	JANITOR	R.O.	ROUGH OPENING	UNFIN.	UNFINISHED
C.T.	CERAMIC TILE	F.E.C.	FIRE EXTINGUISHER CABINET	JT.	JOINT	R.O.W.	RIGHT OF WAY	V.B.	VAPOR BARRIER
CAB.	CABINET	F.F.	FACTORY FINISH	KIT.	KITCHEN	RAD.	RADIUS	V.C.T.	VINYL COMPOSITION TILE
CEM.	CEMENT	F.F.E.	FINISHED FLOOR ELEVATION	L.L.	LIVE LOAD	RBR.	RUBBER	V.I.F.	VERIFY IN FIELD
CER.	CERAMIC	F.H.C.	FIRE HOSE CABINET	L.P.	LOW POINT	REF.	REFERENCE	V.T.	VINYL TILE
CH.B.	CHALK BOARD	F.L.	FLOOR LINE	LAB.	LABORATORY	REFR.	REFRIGERATOR	VAC.	VACUUM
CIRC.	CIRCULAR	F.O.	FACE OF	LAM.	LAMINATE	REINF.	REINFORCED	VERT.	VERTICAL
CL.	CENTER LINE	F.O.B.	FACE OF BLOCK	LAV.	LAVATORY	REQ.	REQUIRED	VEST.	VESTIBULE
CLG.	CEILING	F.O.BLDG.	FACE OF BUILDING	LB.	POUND	RESIL.	RESILIENT	VFY.	VERIFY
CLKG.	CAULKING	F.O.C.	FACE OF CONCRETE	LBR.	LUMBER	REV.	REVERSED	W.	WEST
CLOS.	CLOSET	F.O.F.	FACE OF FINISH	LG.	LONG OR LENGTH	RGH.	ROUGH	W.C.	WATER CLOSET
CLR.	CLEAR	F.O.S.	FACE OF STUDS	LH.	LEFT HAND	RM.	ROOM	W.P.	WATER PROOF
COL.	COLUMN	F.O.W.	FACE OF WALL	LKRS.	LOCKERS	RT.	RIGHT	W.W.F.	WELDED WIRE FABRIC
COMM.	COMMUNICATION	F.P.	FIRE PROOF	LT.	LEFT	S.	SOUTH	W.W.M.	WELDED WIRE MESH
COMP.	COMPOSITION	F.S.	FULL SIZE	M.	MINUTE	S.A.T.	SUSPENDED ACOUSTICAL TILE	W/	WITH
CONC.	CONCRETE	F.T.	FIRE TREATED	M.C.	MEDICINE CABINET	S.B.	SINK BASE	W/O	WITHOUT
CONN.	CONNECTION	FAB.	FABRICATED	M.O.	MASONRY OPENING	S.C.	SOLID CORE	WD.	WOOD
CONST.	CONSTRUCTION	FDN.	FOUNDATION	MAT'L.	MATERIAL	S.C.W.	SOLID CORE WOOD	WT.	WEIGHT
CONT.	CONTINUOUS	FIG.	FIGURE	MAX.	MAXIMUM	S.D.	SMOKE DETECTOR	WTH.	WIDTH
CORR.	CORRIDOR	FIN.	FINISH						
CPT.	CARPET	FIN. FL.	FINISH FLOOR						

3 GENERAL NOTES

- SUMMARY OF WORK:
- THE SCOPE OF WORK SHOWN IN THE CONTRACT DOCUMENTS ADDRESSES THE WORK REQUIRED TO COMPLETE THE NEW CONSTRUCTION OF A HEALTH CLINIC FOR THE VILLAGE OF MCGRATH, ALASKA.
- ALL WORK SHALL BE PERFORMED IN ACCORDANCE WITH THE MOST RECENT ADOPTED EDITION OF THE INTERNATIONAL BUILDING CODE, NFPA, JCAHO, INTERNATIONAL MECHANICAL CODE, NATIONAL ELECTRICAL CODE, UNIFORM PLUMBING CODE AND ALL LOCAL AND ALASKA STATE CODE REGULATIONS AND AMENDMENTS.
 - THESE DRAWINGS ARE SUPPLIED TO THE GENERAL CONTRACTOR AND OTHERS FOR THEIR USE ON THIS SPECIFIC PROJECT. ALL COPIES OF THESE DRAWINGS SHALL REMAIN THE PROPERTY OF ANTHC AND SHALL NOT BE RE-USED OR REPRODUCED WITHOUT PERMISSION FROM ANTHC.
 - THE ORGANIZATION OF THESE DRAWINGS IS NOT INTENDED TO CONTROL THE DIVISION OF WORK AMONG SUB-CONTRACTORS. THE DIVISION OF THE WORK SHALL BE THE SOLE RESPONSIBILITY OF THE GENERAL CONTRACTOR.
 - CONTRACTORS ARE RESPONSIBLE FOR CONFORMING TO ALL APPLICABLE LOCAL CODES AND TRADE STANDARDS.
 - CONTRACTORS SHALL TAKE ALL NECESSARY PRECAUTIONARY MEASURES TO PROTECT THE PUBLIC AND ADJACENT PROPERTIES FROM DAMAGE THROUGHOUT CONSTRUCTION. CONTRACTOR ASSUMES ALL LIABILITY FOR DAMAGES INCURRED DURING CONSTRUCTION.
 - CONTRACTOR SHALL PROVIDE ALL LABOR, EQUIPMENT AND MATERIALS REQUIRED TO COMPLETE ALL WORK AS SHOWN OR AS IMPLIED ON THESE DRAWINGS.
 - CONTRACTOR SHALL PROVIDE AND MAINTAIN ALL FACILITIES FOR LIGHT, HEAT AND POWER WITHIN THE PREMISES AND IN THE CONSTRUCTION AREA DURING THE ENTIRE CONSTRUCTION PERIOD. PROVIDE NECESSARY MATERIALS AND LABOR FOR POWER CONNECTIONS FOR MACHINES, PORTABLE, ETC. AS USED BY OTHER TRADES, REGARDLESS OF SIZE.
 - CONTRACTOR SHALL VERIFY ALL DIMENSIONS AND CONDITIONS IN THE FIELD PRIOR TO CONSTRUCTION. IF A CONDITION NOT COVERED IN THE DRAWINGS IS ENCOUNTERED, OR IF A DIMENSIONAL ERROR IS FOUND, THE CONTRACTOR SHALL NOTIFY THE ARCHITECT BEFORE COMMENCING WITH THAT PORTION OF THE WORK.
 - ALL COMPONENTS, EQUIPMENT, ETC., SHALL BE INSTALLED PER MANUFACTURERS PRINTED RECOMMENDATIONS
 - CONTRACTOR SHALL BE RESPONSIBLE FOR THE REMOVAL OF ALL RUBBISH AND DEBRIS RESULTING FROM CONSTRUCTION.
 - ALL COLOR SELECTION SHALL BE PER THE COLOR SCHEDULE OR IF NOT ON THE COLOR SCHEDULE THEN SUBMIT TO THE CONTRACTING OFFICER FOR APPROVAL.
 - ALL DIMENSIONS ARE TO FACE OF STUDS, FACE OF PANEL SHEATHING, GRID LINES, FACE OF ROUGH OPENING, UNLESS INDICATED OTHERWISE.
 - CAULK ALL JOINTS, PROVIDE BACKER ROD AS NEEDED, AND PROVIDE FLASHING AND COUNTER FLASHING AS NEEDED TO PROVIDE COMPLETE WEATHER PROOF INSTALLATION.

2 DRAWING SYMBOLS

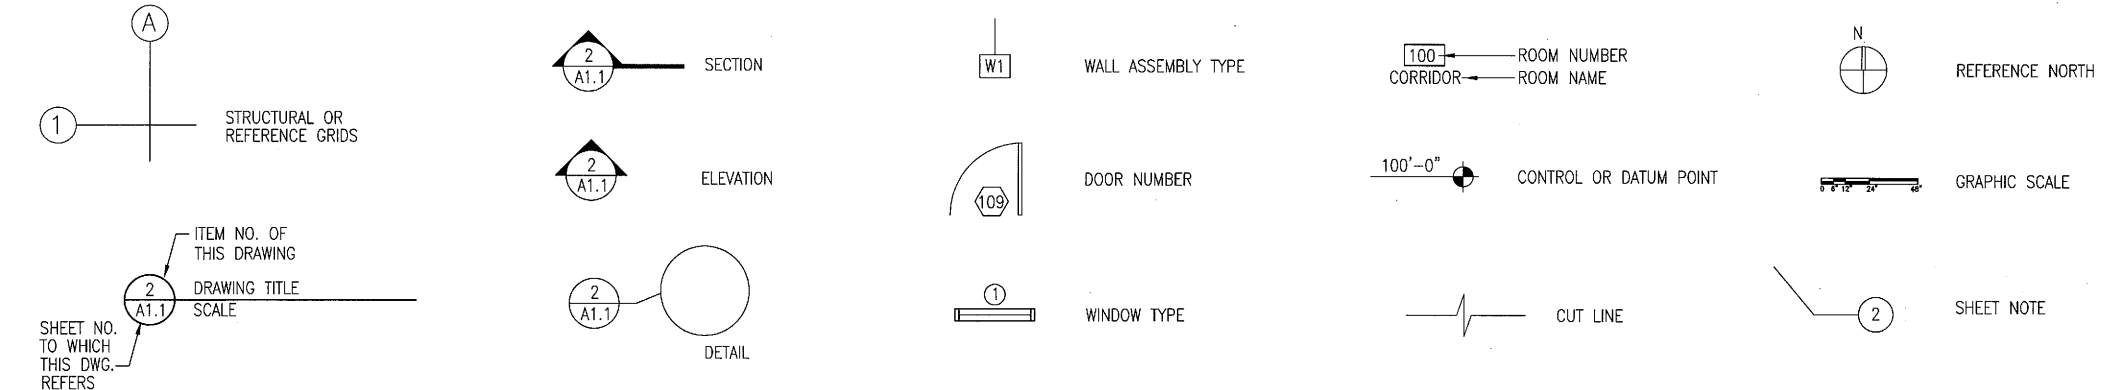

INT:

REVISIONS

DATE

STATE OF ALASKA

REGISTERED PROFESSIONAL ARCHITECT

WILLIAM A. KLUGE

A6301

4.20 2009

ALASKA NATIVE TRIBAL HEALTH CONSORTIUM

DIVISION OF ENVIRONMENTAL HEALTH AND ENGINEERING

1901 SOUTH BRACAW STREET, SUITE 200

ANCHORAGE, ALASKA 99508-3440

(907) 729-3600

McGRATH SUB-REGIONAL HEALTH CENTER

ABBREVIATIONS, GENERAL NOTES & DRAWING SYMBOLS

FILE NAME:

PROJECT NO: 0198

PROJ ARCH: BK

DATE: 4/20/2009






SCALE: AS NOTED

DRAWN BY: CFP

SHEET A-001

1 OF 13A

LEGEND		
SYMBOL	DETAIL	DESCRIPTION
		(7)10'-12' NATIVE BIRCH
		(6)6' NATIVE SPRUCE
		4" MIN TOPSOIL W/ KENTUCKY BLUE GRASS SEED @ ALL DISTURBED AREAS. REFER TO CIVIL DRAWINGS FOR THE EXTEND OF CLEARING LIMITS.
PARKING (22) TOTAL PARKING SPACES (2) ADA ACCESSIBLE SPACES		

 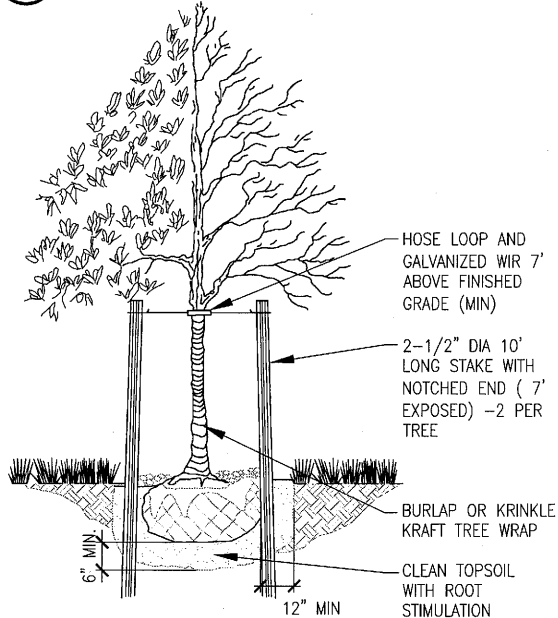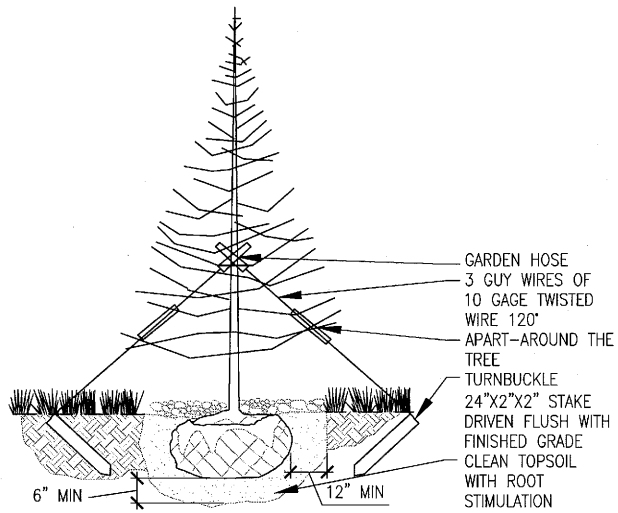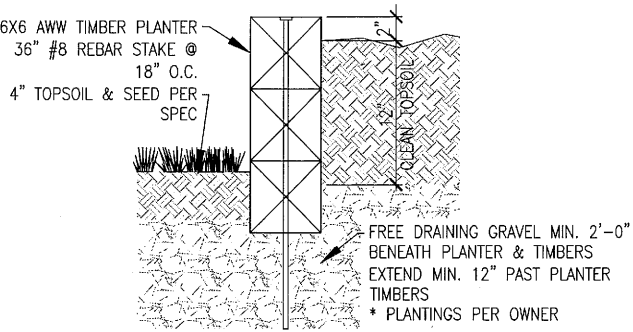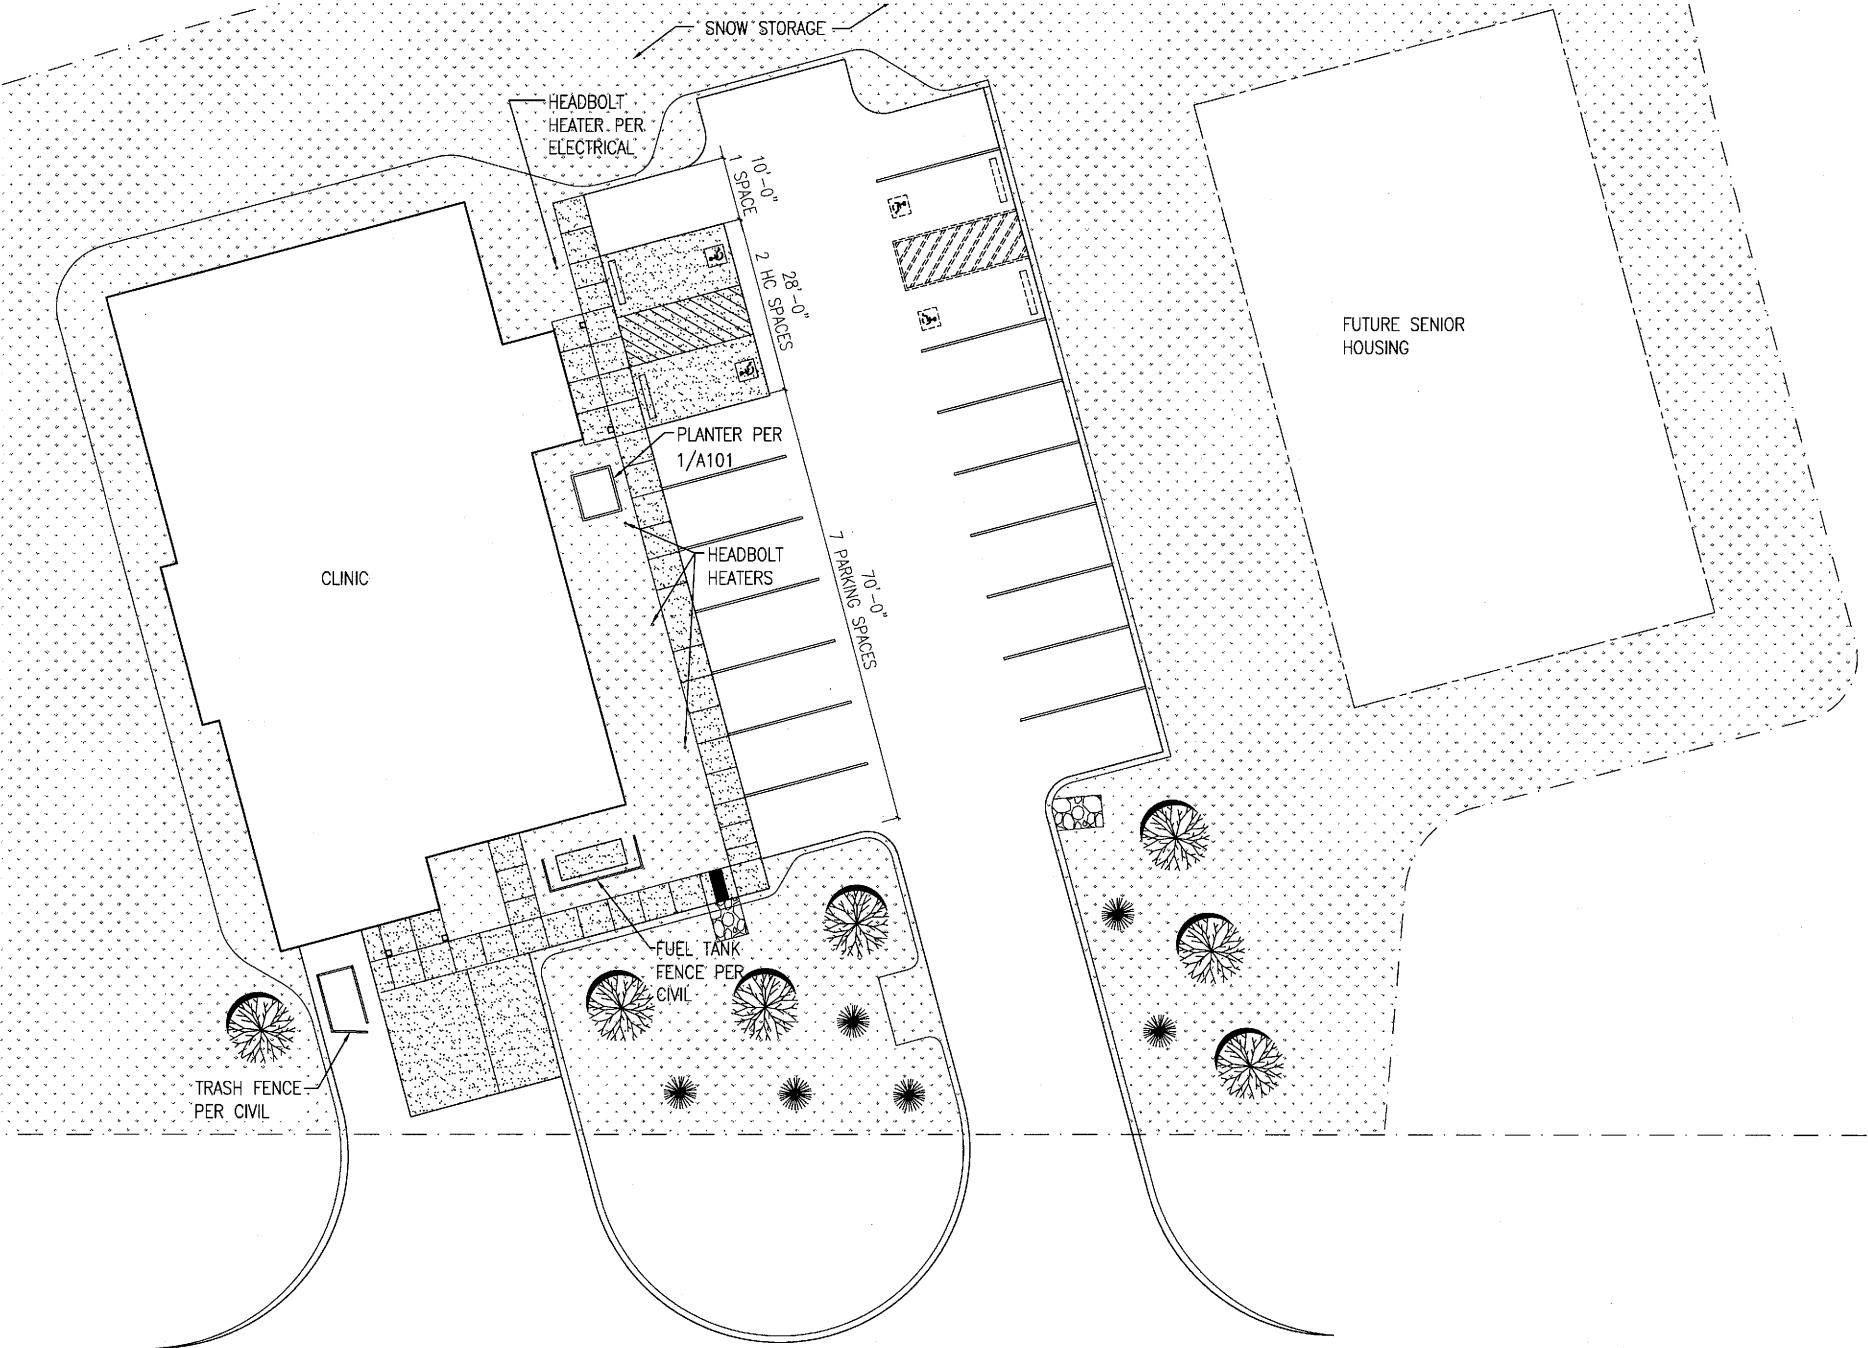

INIT.	
REVISIONS	
DATE	




4.20 2009

ALASKA NATIVE TRIBAL HEALTH CONSORTIUM

DIVISION OF ENVIRONMENTAL HEALTH AND ENGINEERING

1901 SOUTH BRAGAW STREET, SUITE 200
ANCHORAGE, ALASKA, 99508-3440
(907) 729-3600

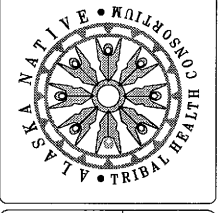

McGRATH SUB-REGIONAL HEALTH CENTER

SITE PLAN

FILE NAME: _____

PROJECT NO: 0198

PROJ ARCH: BK

DATE: 4/20/2009

SCALE: AS NOTED


DRAWN BY: CFP

SHEET A-101

2 OF 13A




INIT.	
REVISIONS	
DATE	

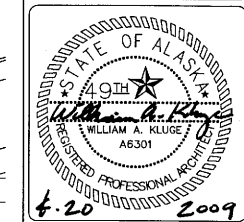

ALASKA NATIVE
TRIBAL HEALTH CONSORTIUM

DIVISION OF ENVIRONMENTAL
HEALTH AND ENGINEERING
1901 SOUTH BRAGAW STREET, SUITE 200
ANCHORAGE, ALASKA, 99508-3440
(907) 729-3600










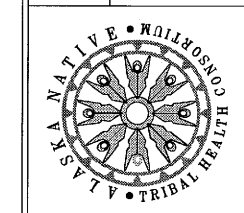



McGRATH SUB-REGIONAL
HEALTH CENTER
ROOF PLAN

FILE NAME: _____
PROJECT NO: 0198
PROJ ARCH: BK

DATE: 4/20/2009
SCALE: AS NOTED
DRAWN BY: CFP

  
SHEET
A-104
5 OF 13A

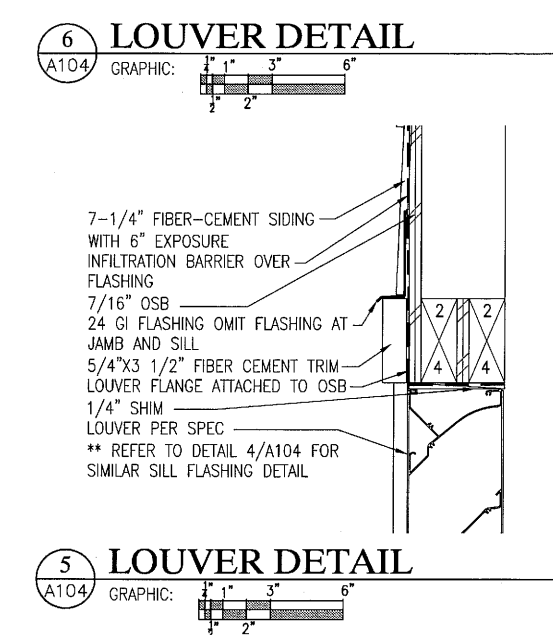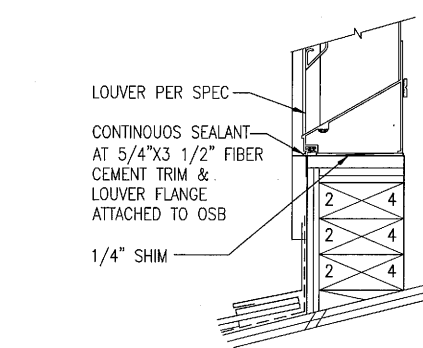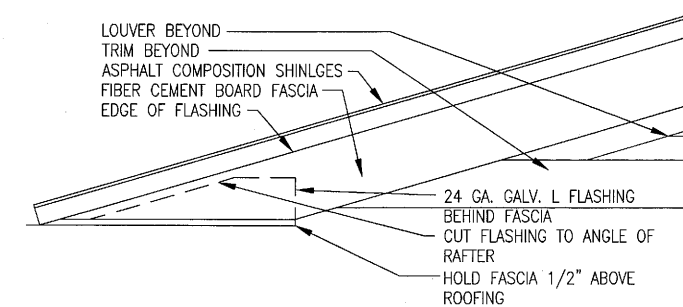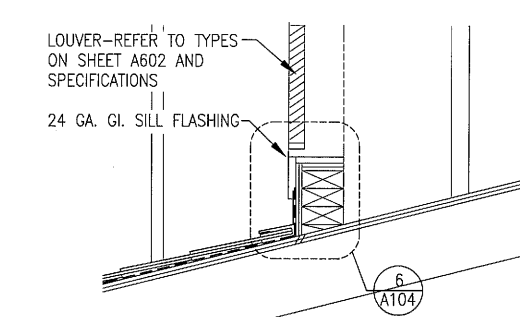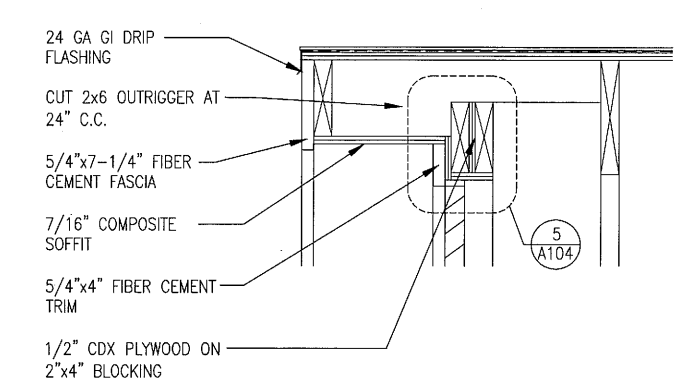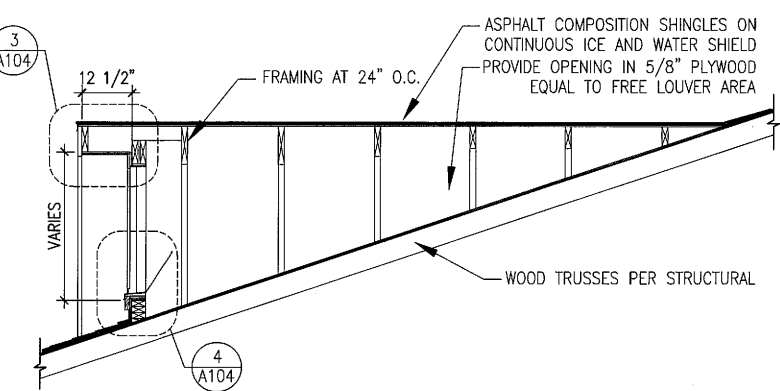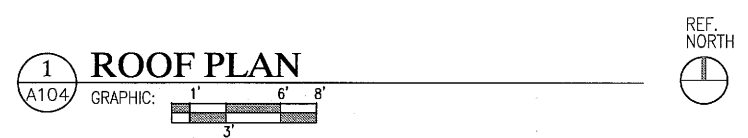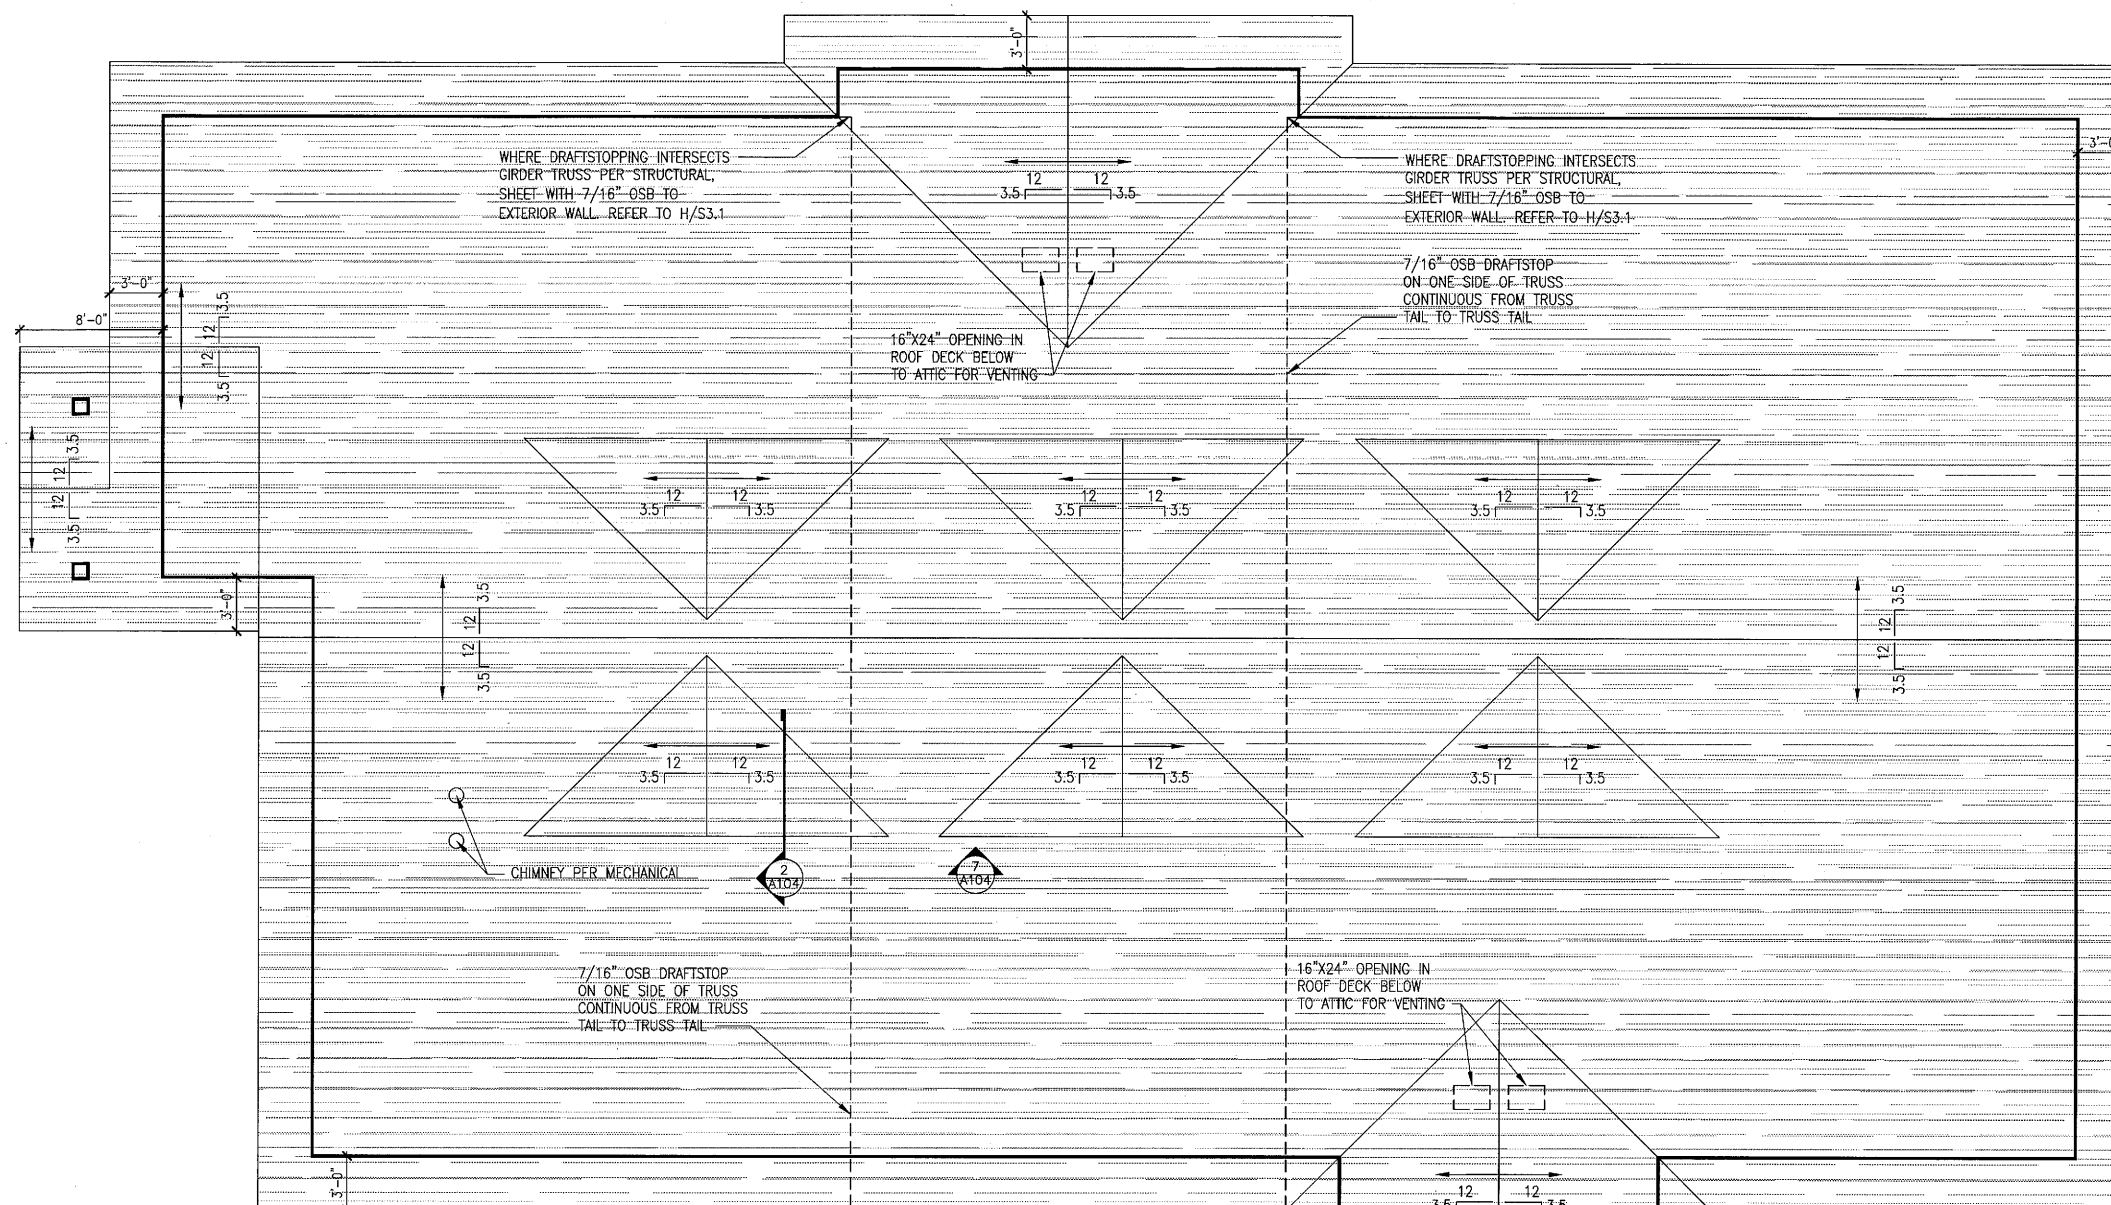

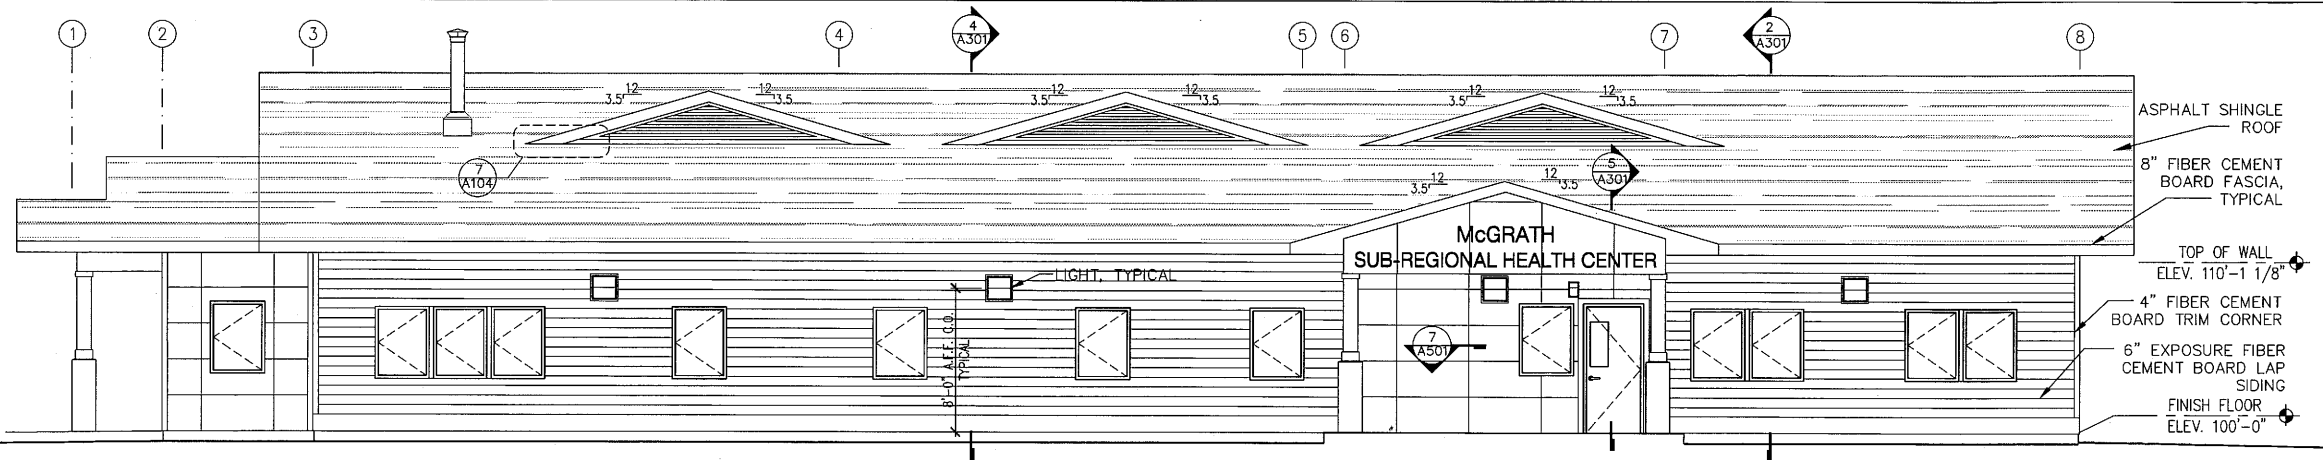


1 FRONT ELEVATION

A201 GRAPHIC: 1' 6' 8' 3'

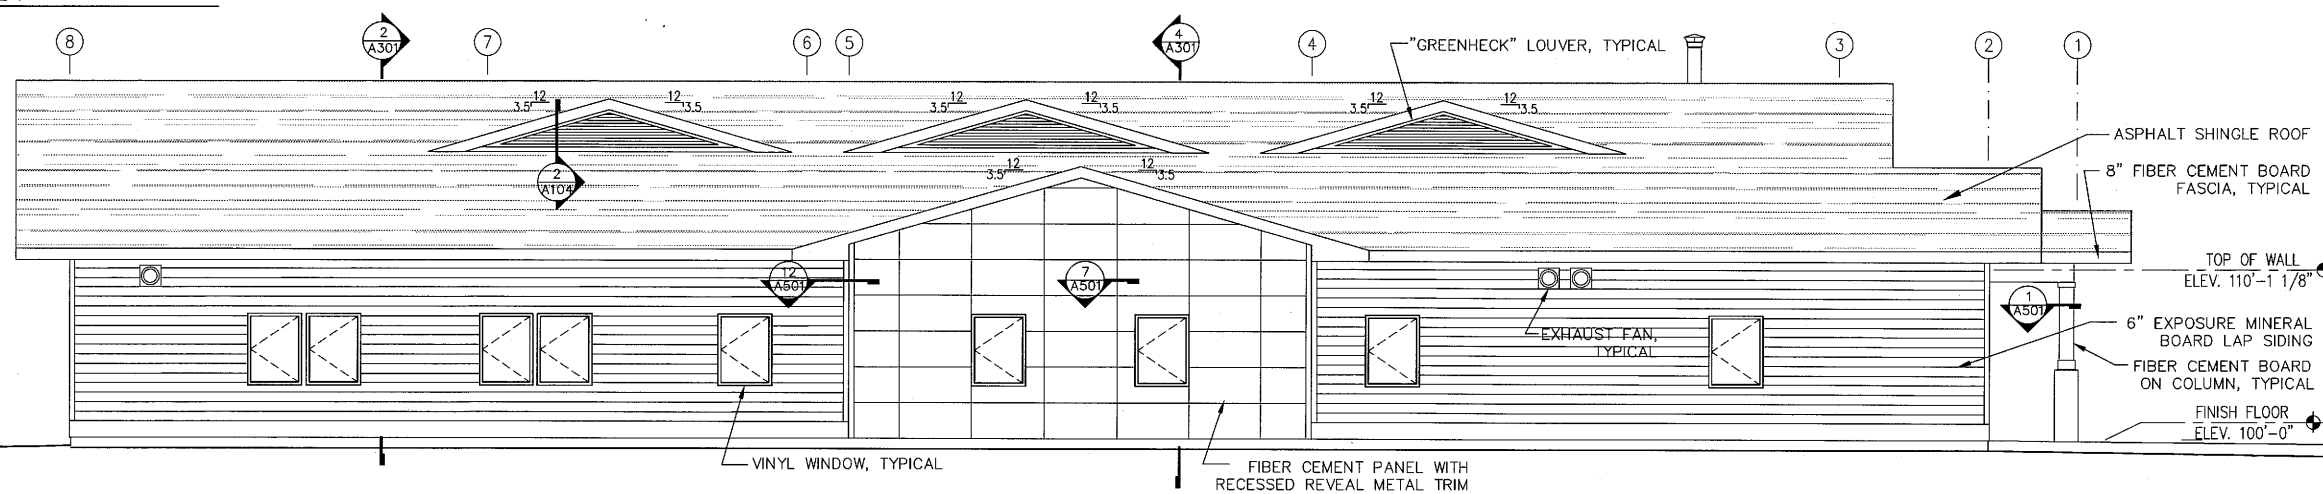


2 BACK ELEVATION

A201 GRAPHIC: 1' 6' 8' 3'

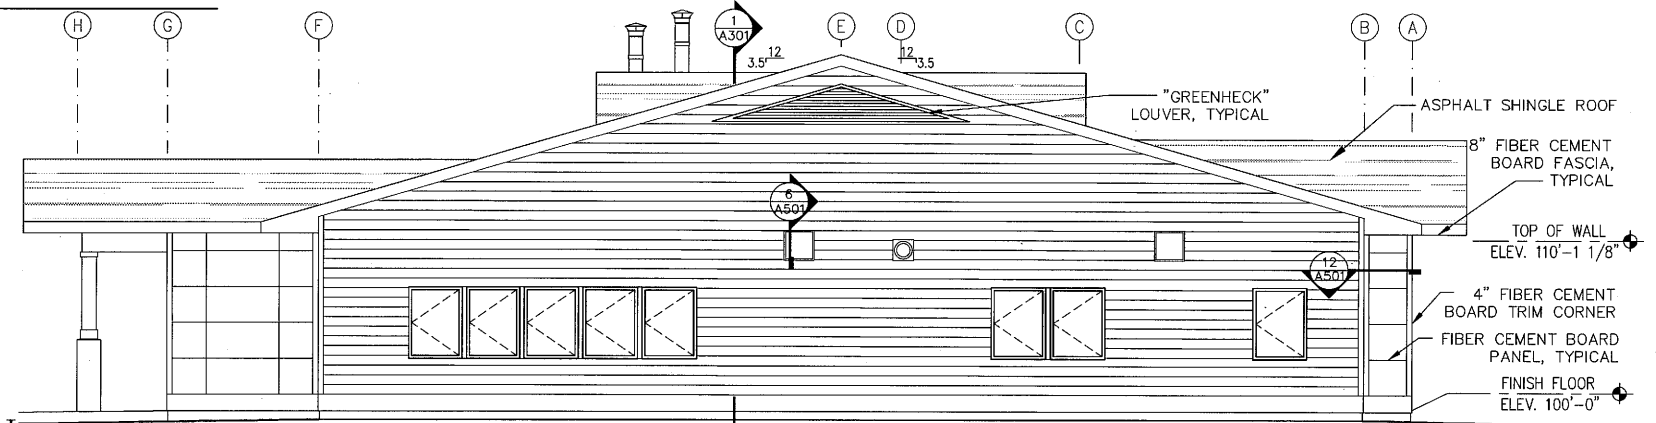

3 RIGHT ELEVATION

A201 GRAPHIC: 1' 6' 8' 3'

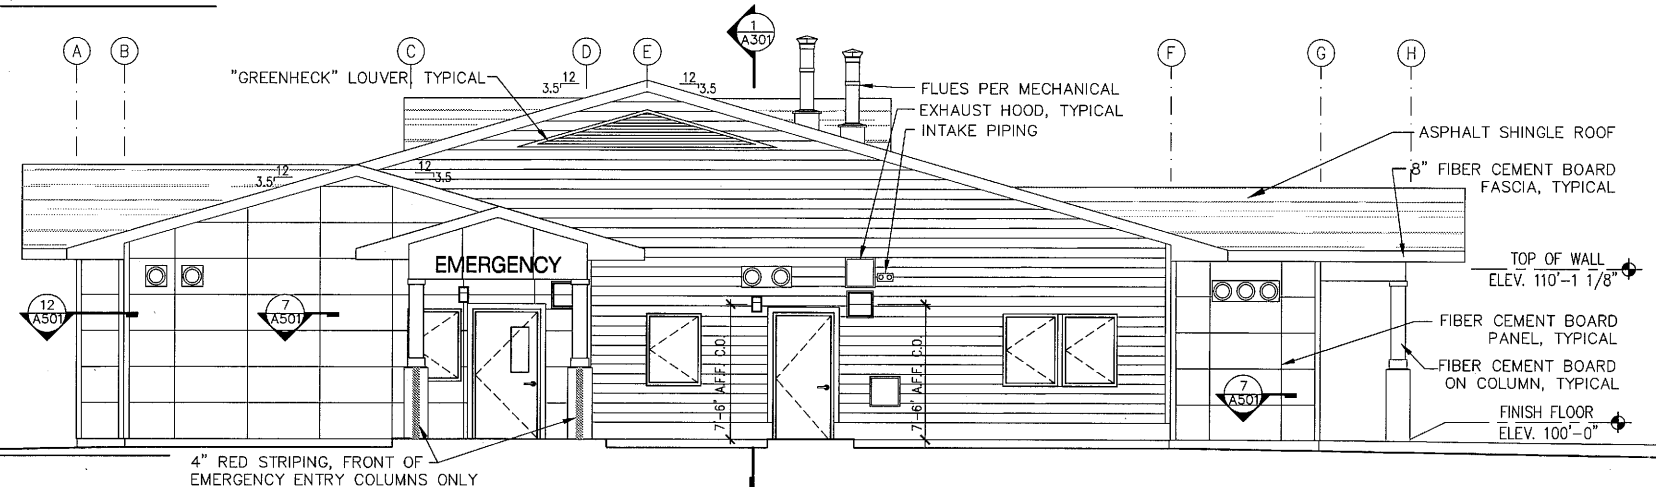


4 LEFT ELEVATION

A201 GRAPHIC: 1' 6' 8' 3'

GENERAL NOTES

1. ARCHITECTURAL DRAWING'S FINISH FLOOR HEIGHT IS SET AT 100'-0" FOR CONVENIENCE. CIVIL FINISH FLOOR IS SET AT A DIFFERENT DATUM.

INIT.	DATE	REVISIONS

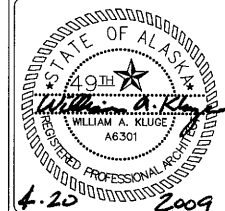

ALASKA NATIVE TRIBAL HEALTH CONSORTIUM
DIVISION OF ENVIRONMENTAL HEALTH AND ENGINEERING
1901 SOUTH BRAGAW STREET, SUITE 200
ANCHORAGE, ALASKA, 99508-3440
(907) 729-3600

 
 
 
 


McGrath SUB-REGIONAL HEALTH CENTER
EXTERIOR ELEVATIONS

FILE NAME: _____
PROJECT NO: 0198
PROJ ARCH: BK


DATE: 4/20/2009
SCALE: AS NOTED
DRAWN BY: CFP








INIT.	
REVISIONS	
DATE	

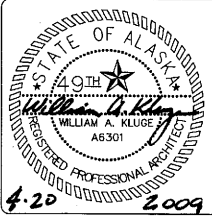

ALASKA NATIVE
TRIBAL HEALTH CONSORTIUM
DIVISION OF ENVIRONMENTAL
HEALTH AND ENGINEERING
1901 SOUTH BRAGAW STREET, SUITE 200
ANCHORAGE, ALASKA, 99508-3440
(907) 729-3600

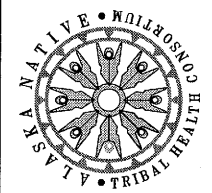


McGRATH SUB-REGIONAL
HEALTH CENTER
WALL SECTIONS


FILE NAME:
PROJECT NO: 0198
PROJ ARCH: BK

DATE: 4/20/2009
SCALE: AS NOTED
DRAWN BY: CFP


SHEET
A-401
8 OF 13A

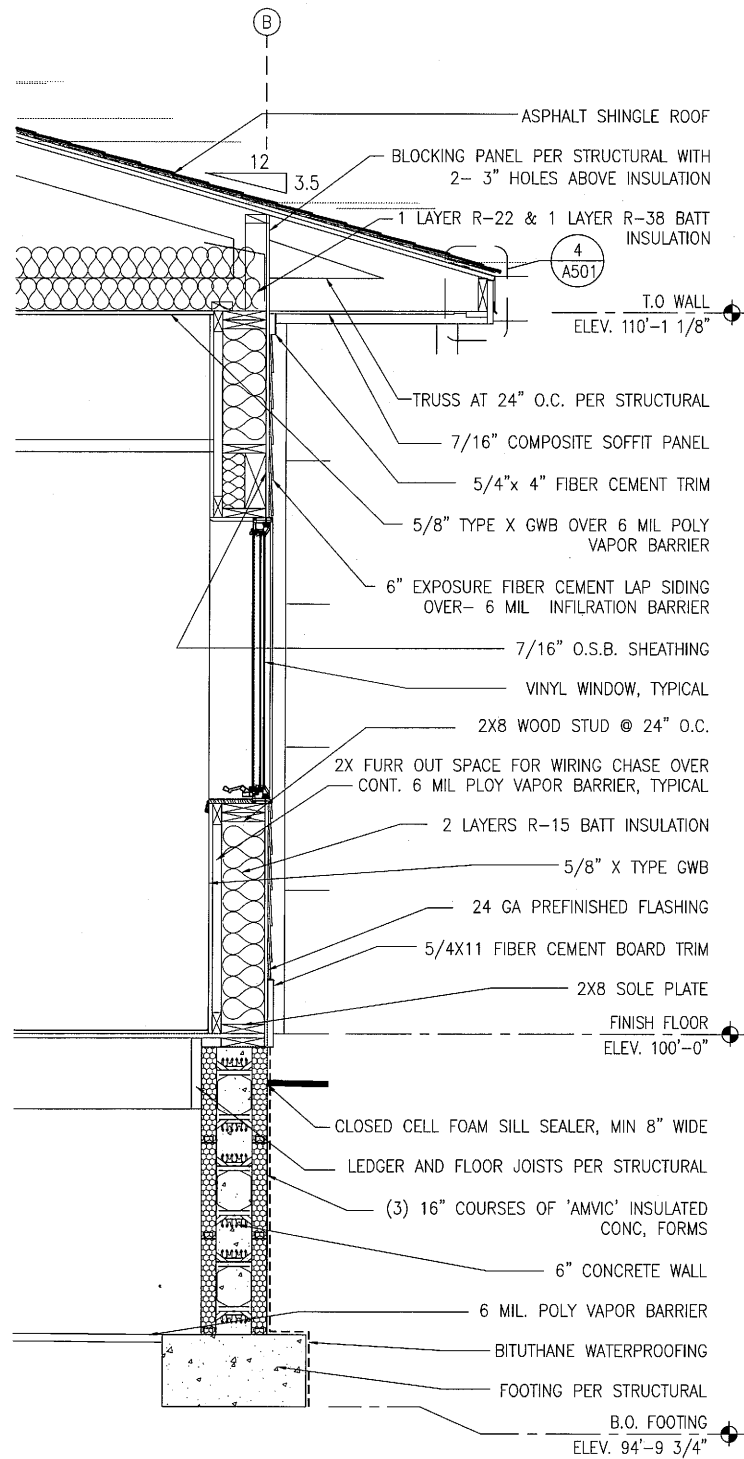


1 WALL SECTION
A401
GRAPHIC: 1" 4" 12" 24"
2" 6"

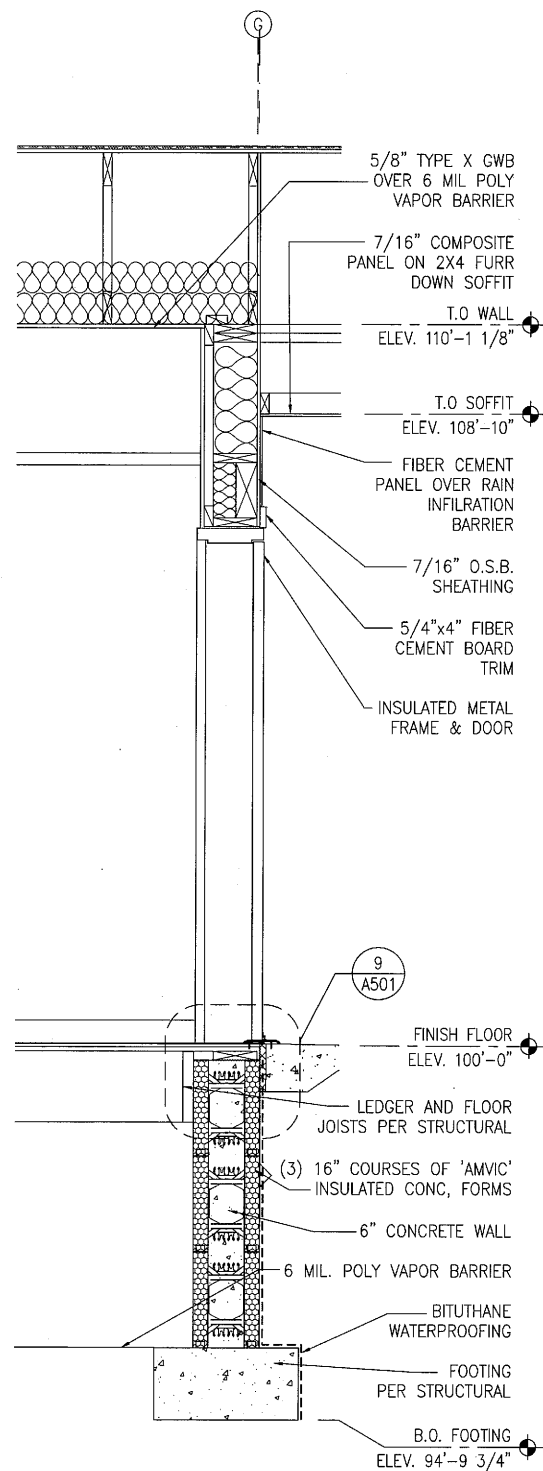


2 WALL SECTION
A401
GRAPHIC: 1" 4" 12" 24"
2" 6"

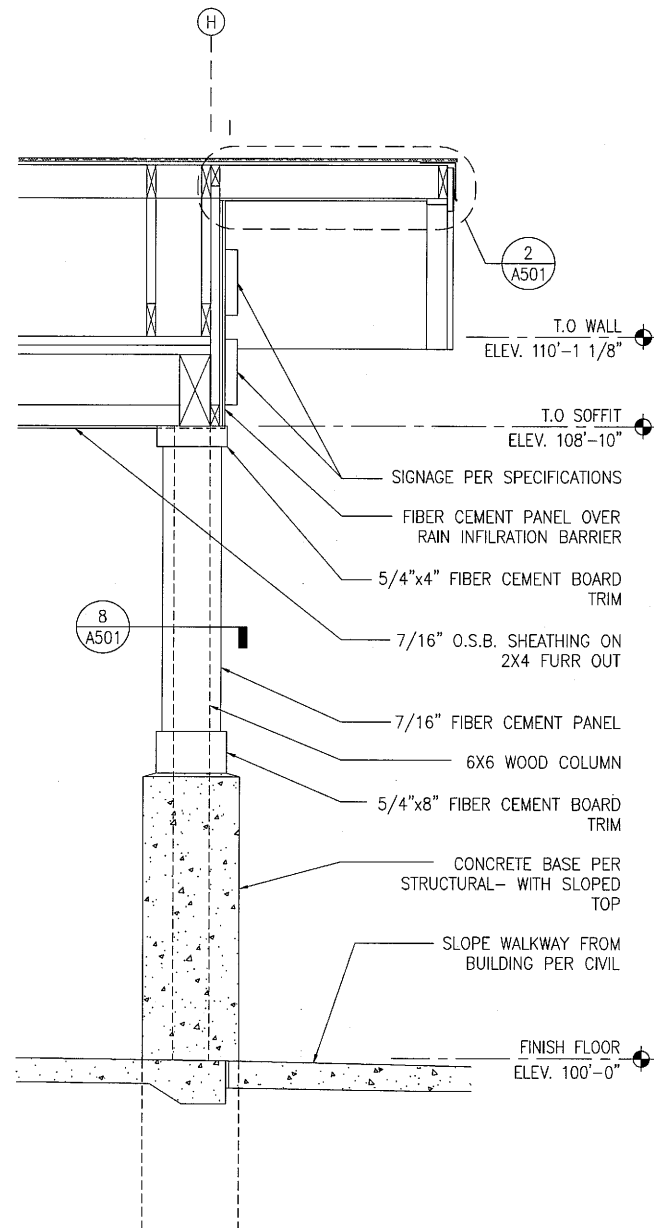

3 WALL SECTION
A401
GRAPHIC: 1" 4" 12" 24"
2" 6"

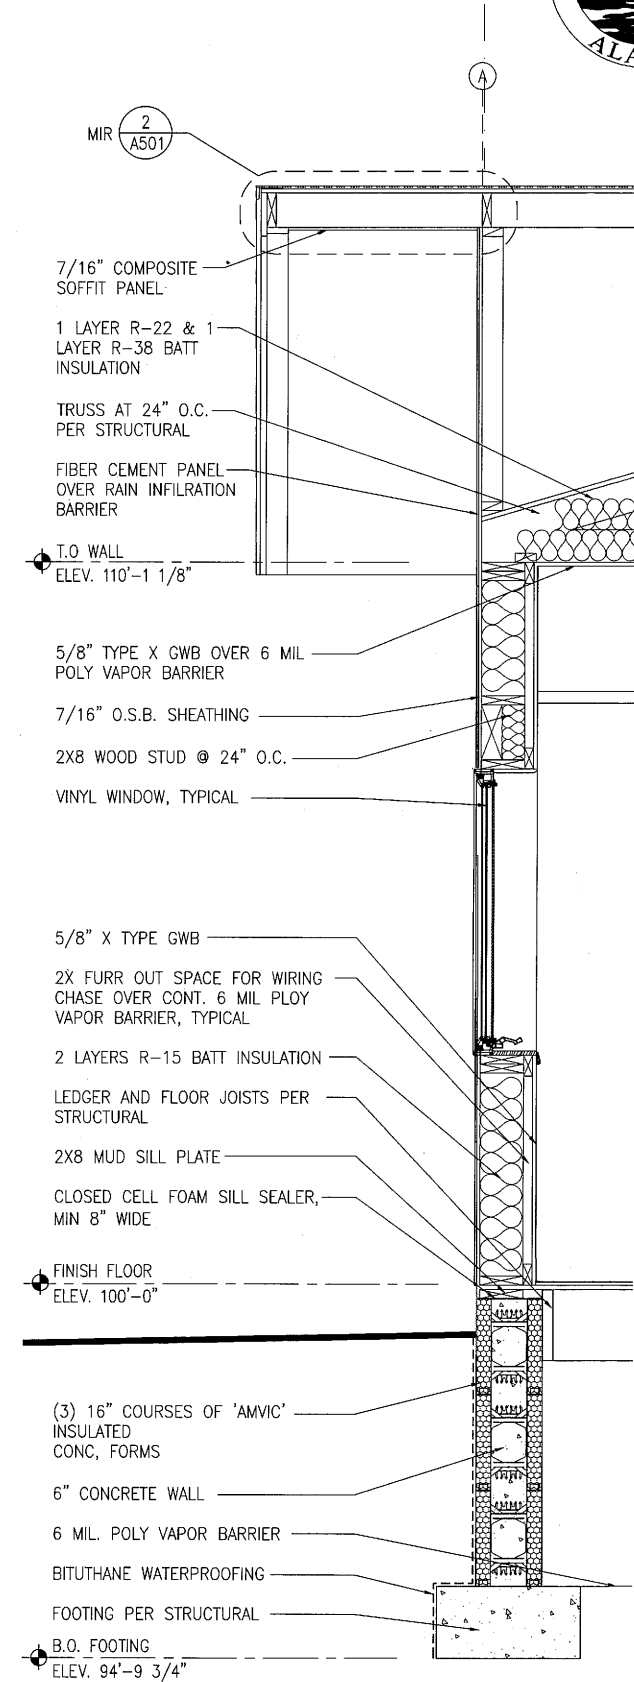


4 WALL SECTION
A401
GRAPHIC: 1" 4" 12" 24"
2" 6"

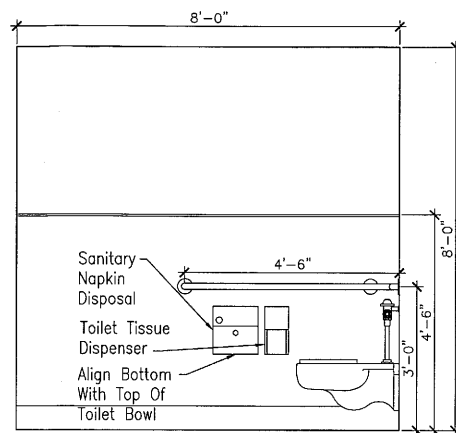

1 TOILET-102

A402 GRAPHIC: 0 6" 12" 24" 48"


ELEVATION 1/A402 ONLY:
TOILET-103 & TOILET-138: SAME AS TOILET-102
TOILET-116: SAME AS TOILET-102, BUT MIRRORED AND WITH W4 PER A-601

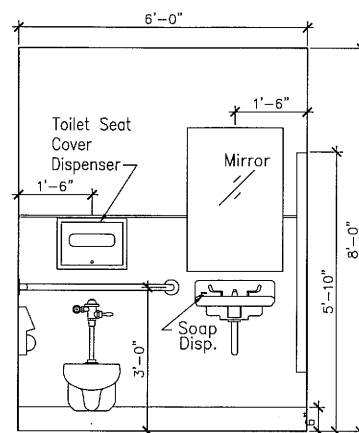

2 TOILET-102

A402 GRAPHIC: 0 6" 12" 24" 48"


ELEVATION 2/A402 ONLY:
TOILET-103: SAME AS TOILET-102
TOILET-116: SAME AS TOILET-102, BUT MIRRORED AND WITH W4 PER A-601

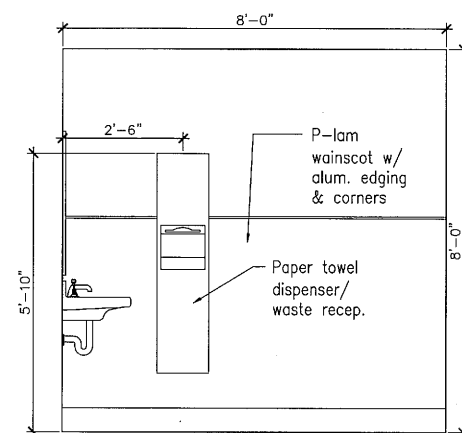

3 TOILET-102

A402 GRAPHIC: 0 6" 12" 24" 48"

ELEVATION 3/A402 ONLY:
TOILET-103: SAME AS TOILET-102
TOILET-116: SAME AS TOILET-102, BUT MIRRORED AND WITH W4 PER A-601

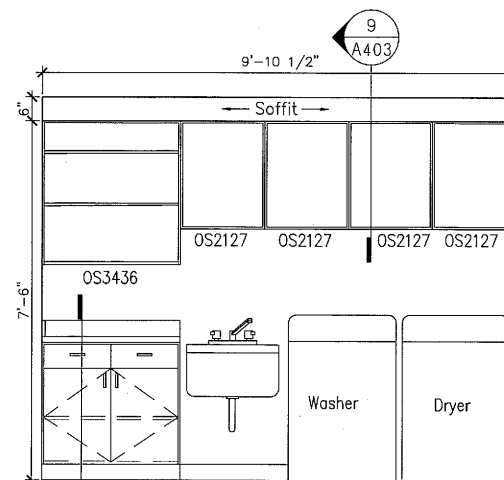


4 LAUNDRY-112

A402 GRAPHIC: 0 6" 12" 24" 48"

CABINETRY LEGEND


TYPE BC 36 34
WIDTH OF CABINET
(BASE) HEIGHT A.F.F. TO TOP OF COUNTER OR (UPPER) HEIGHT OF UNIT

BC BASE CABINET UNIT
SB SINK BASE UNIT
DB DRAWER BASE
UC UPPER CABINET WALL UNIT
OS OPEN SHELVING UNIT

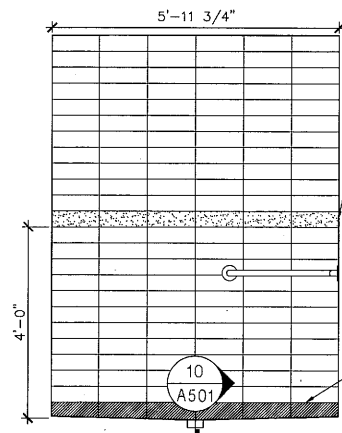

5 SHOWER-115


A402 GRAPHIC: 0 6" 12" 24" 48"

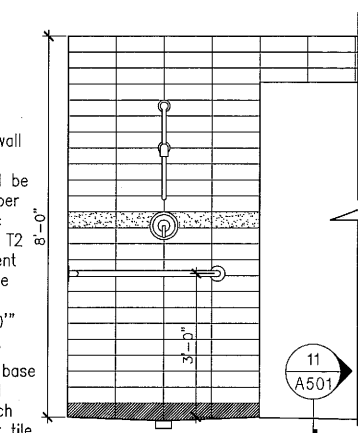

6 SHOWER-115


A402 GRAPHIC: 0 6" 12" 24" 48"

All wall tile shall be T1 per spec with T2 accent stripe at 4'-0" a.f.f.
Tile base shall match floor tile

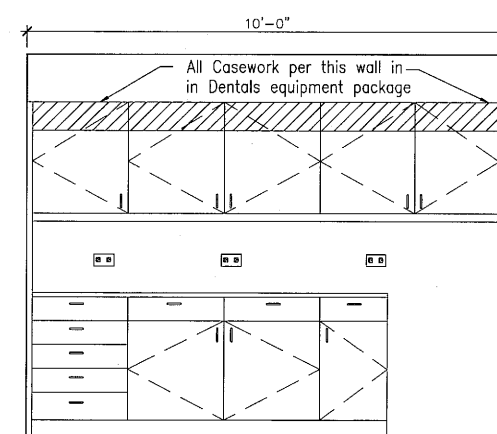


7 CLEAN/DIRTY-118

A402 GRAPHIC: 0 6" 12" 24" 48"

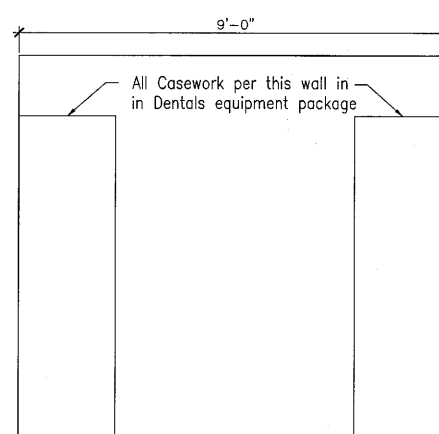


8 CLEAN/DIRTY-118

A402 GRAPHIC: 0 6" 12" 24" 48"

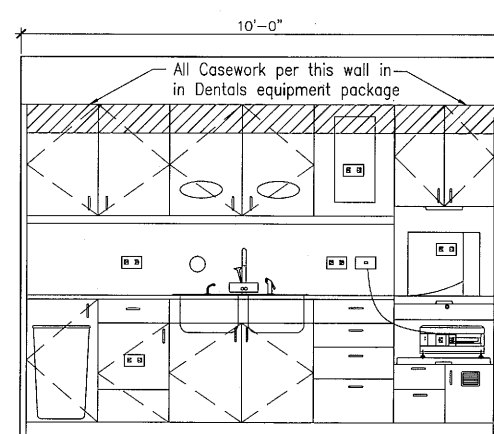


9 CLEAN/DIRTY-118

A402 GRAPHIC: 0 6" 12" 24" 48"

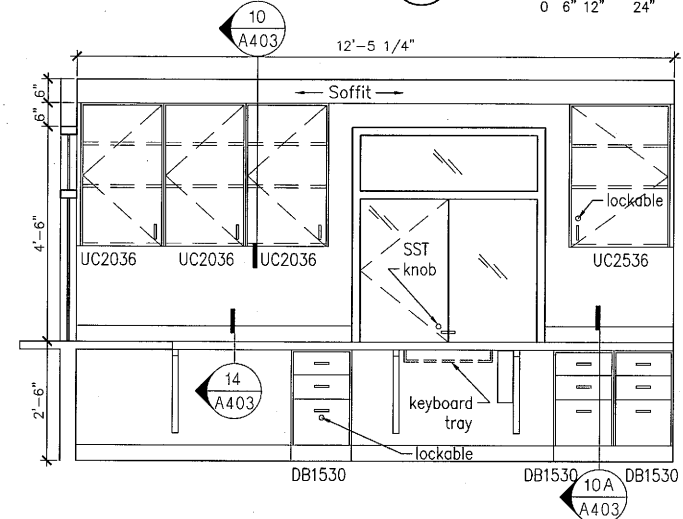


10 RECEPTION-126

A402 GRAPHIC: 0 6" 12" 24" 48"

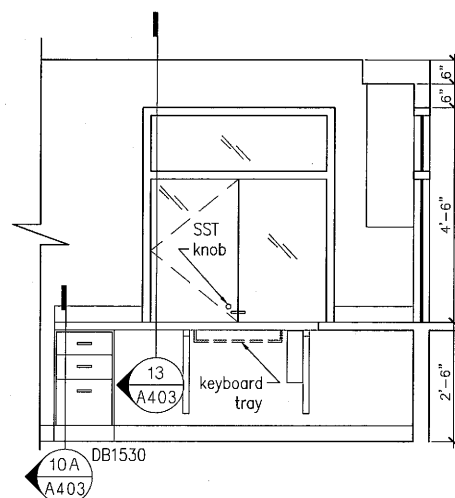


11 RECEPTION-126

A402 GRAPHIC: 0 6" 12" 24" 48"

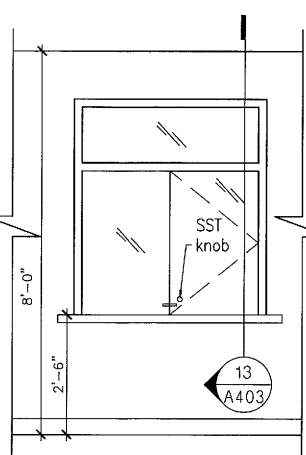


12 WAITING-104

A402 GRAPHIC: 0 6" 12" 24" 48"

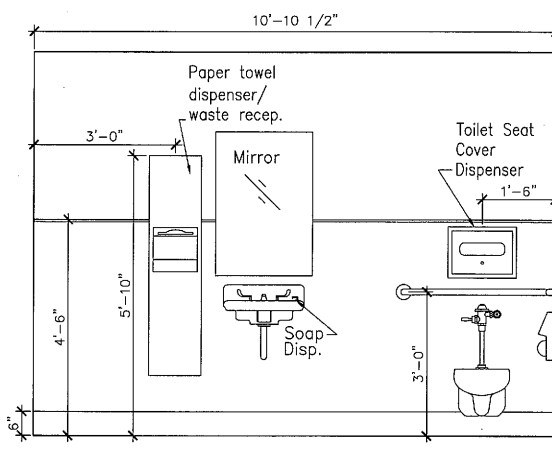


13 H.C. BATH-131

A402 GRAPHIC: 0 6" 12" 24" 48"

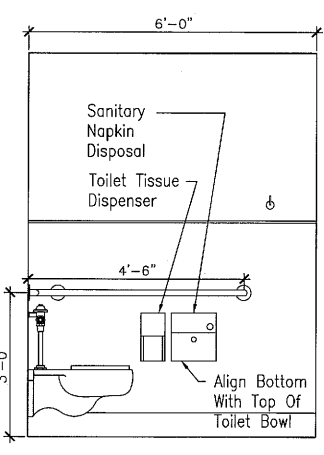


14 H.C. BATH-131

A402 GRAPHIC: 0 6" 12" 24" 48"

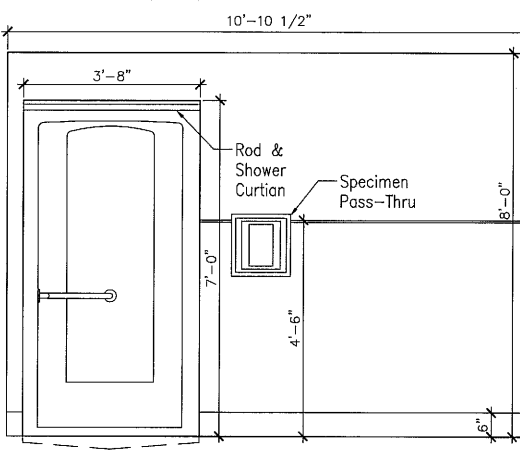


15 H.C. BATH-131

A402 GRAPHIC: 0 6" 12" 24" 48"

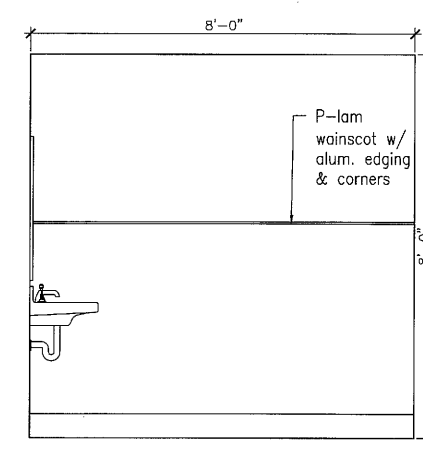

16 TOILET-138


A402 GRAPHIC: 0 6" 12" 24" 48"

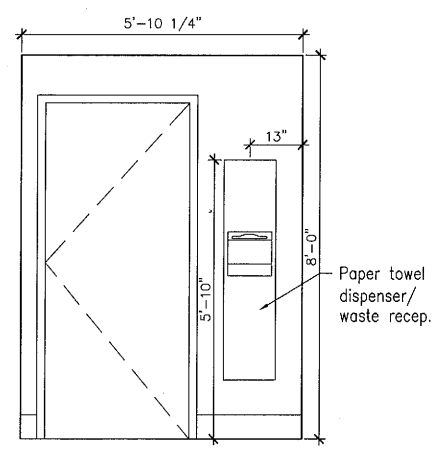


17 TOILET-138

A402 GRAPHIC: 0 6" 12" 24" 48"

INIT.	
REVISIONS	
DATE	

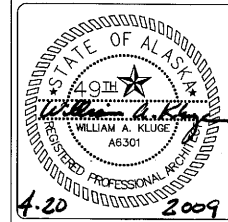


ALASKA NATIVE TRIBAL HEALTH CONSORTIUM
DIVISION OF ENVIRONMENTAL HEALTH AND ENGINEERING
1901 SOUTH BRAGAW STREET, SUITE 200
ANCHORAGE, ALASKA 99508-3440
(907) 729-3600

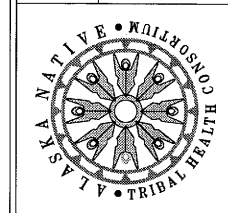

McGrath Sub-Regional Health Center
INTERIOR ELEVATIONS


FILE NAME:
PROJECT NO: 0198
PROJ ARCH: BK

DATE: 4/20/2009
SCALE: AS NOTED
DRAWN BY: CFP CMP

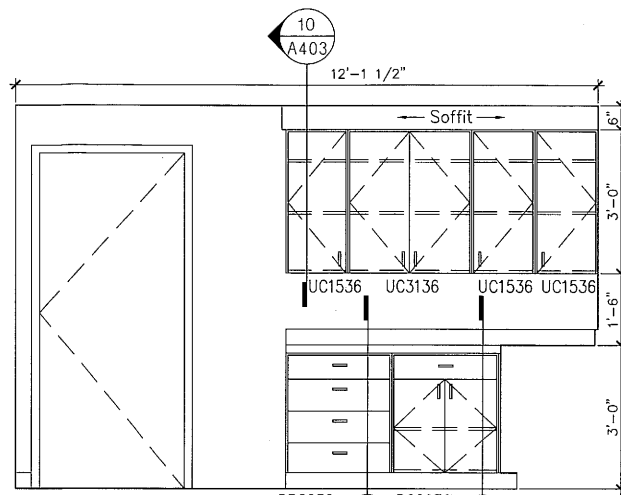


1 LAB-132

A403 GRAPHIC: 0 6" 12" 24" 48"

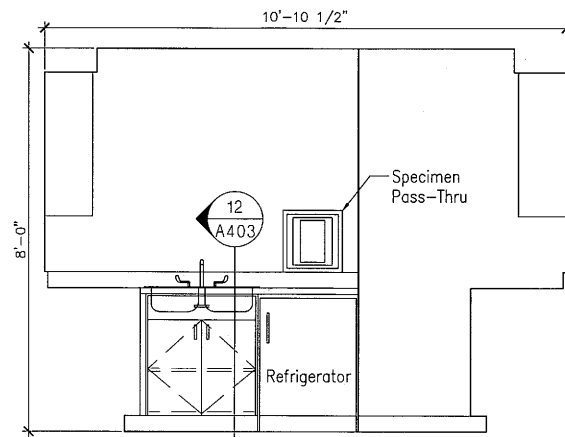


2 LAB-132

A403 GRAPHIC: 0 6" 12" 24" 48"

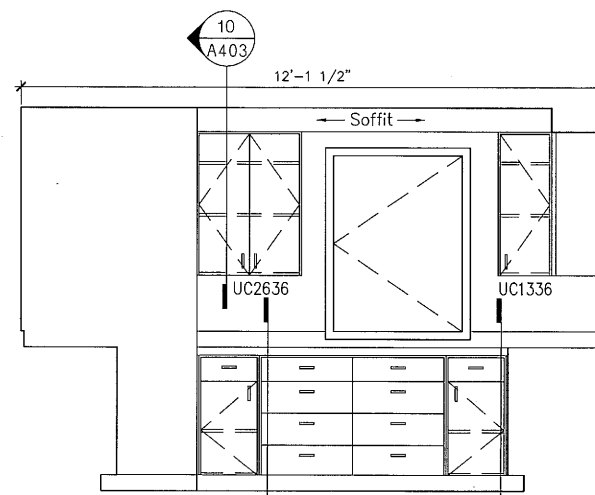

3 LAB-132

A403 GRAPHIC: 0 6" 12" 24" 48"

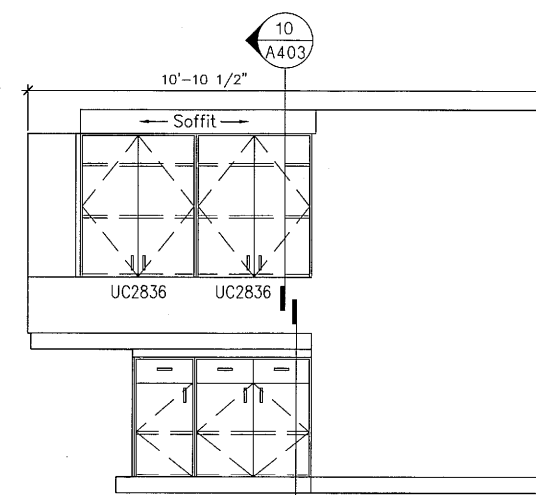


4 LAB-132

A403 GRAPHIC: 0 6" 12" 24" 48"


MILWORK NOTES

- ADJUST CABINET WORK AND HARDWARE SO THAT DOORS AND DRAWERS OPERATE SMOOTHLY WITHOUT WARP OR BIND. LUBRICATE OPERATING HARDWARE AS RECOMMENDED BY MANUFACTURER.
- SEAL ALL WOOD SURFACES NOT RECEIVING PAINT OR PLASTIC LAMINATE TO AVOID MOISTURE PENETRATION.
- ALL STEEL BRACKETS ARE TO BE SECURED TO STUDS OR BLOCKING AND NOT MOLLY BOLTED TO GYPSUM BOARD.
- ALL MILLWORK DIMENSIONS SHALL BE FIELD VERIFIED PRIOR TO COMMENCING WORK. SOME DIMENSIONS WILL VARY DEPENDING ON EXISTING CONDITIONS AND ALIGNMENT OF NEW WORK.
- GENERAL CONTRACTOR TO PROVIDE ALL BLOCKING TO SECURELY ATTACH MILLWORK TO DRYWALL CONSTRUCTION.
- ALL SHELVING GREATER THAN 30" WIDTH SHALL BE MINIMUM 1" HI-DENSITY BOARD. THIS INCLUDES OPEN, BASE AND UPPER CABINETS.

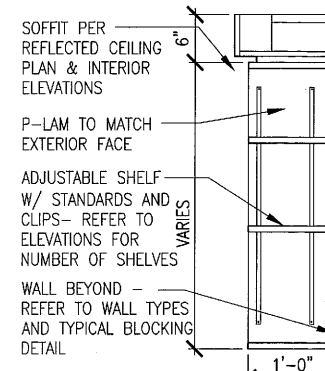


9 Open Shelving

A403 GRAPHIC: 0 10" 20" 30"

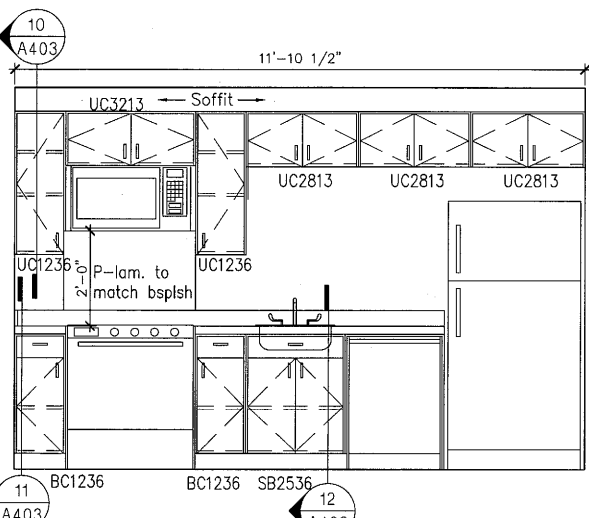


5 STAFF-139

A403 GRAPHIC: 0 6" 12" 24" 48"

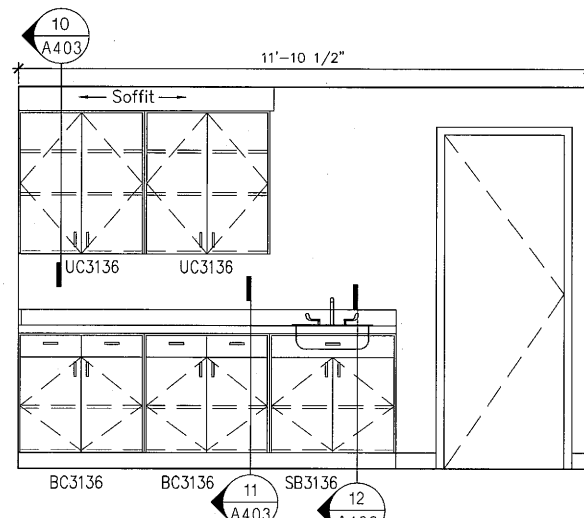


6 CONFERENCE-142

A403 GRAPHIC: 0 6" 12" 24" 48"

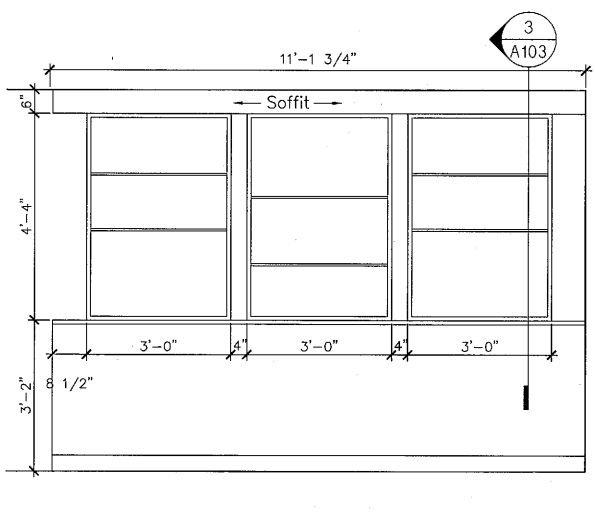

7 WAITING-104


A403 GRAPHIC: 0 6" 12" 24" 48"

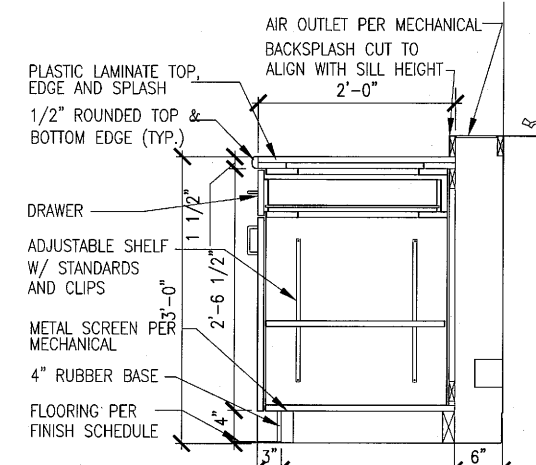

8 Base Cabinet


A403 GRAPHIC: 0 10" 20" 30"

8A DETAIL 8A/A501 ONLY:
A403 LAB-132: SAME BUT A FULL DRAWER BASE

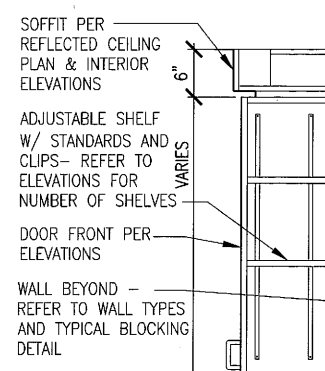

10 Upper Cabinet


A403 GRAPHIC: 0 10" 20" 30"

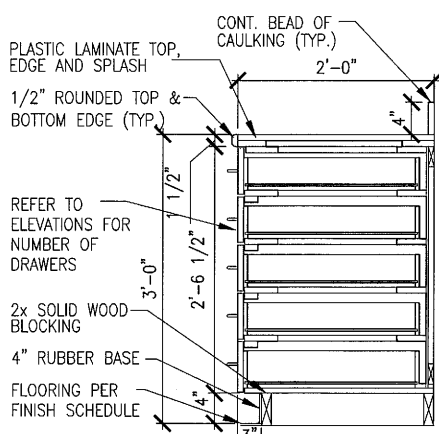

10 Drawer Base Cabinet

A403 GRAPHIC: 0 10" 20" 30"


10A DETAIL 10A/A501 ONLY:
A403 RECEPTION-126: SAME BUT 30" A.F.F. INSTEAD OF 36" A.F.F.

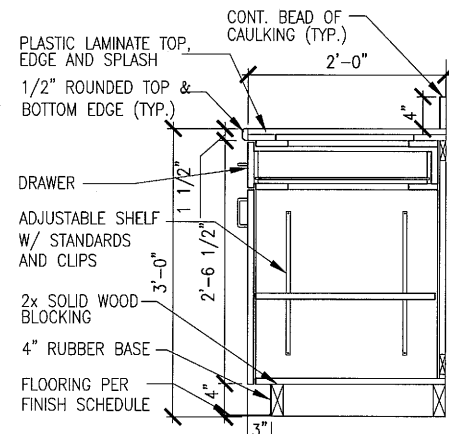

11 Base Cabinet


A403 GRAPHIC: 0 10" 20" 30"

11A DETAIL 11A/A501 ONLY:
A403 LAUNDRY-125: SAME BUT 30" DEPTH INSTEAD OF 24" DEPTH

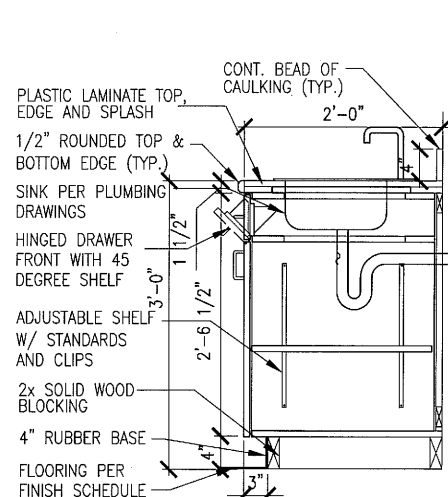


12 Base Sink Cabinet

A403 GRAPHIC: 0 10" 20" 30"

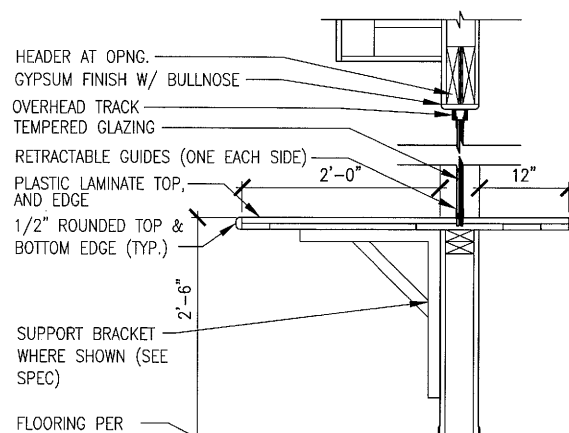

13 Countertop


A403 GRAPHIC: 0 10" 20" 30"

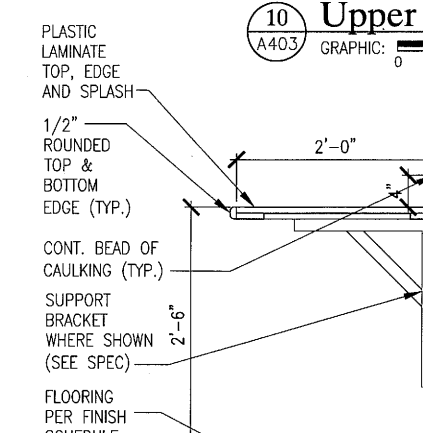


14 Countertop

A403 GRAPHIC: 0 10" 20" 30"

INIT.	DATE	REVISIONS

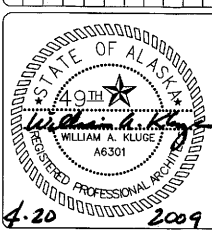

ALASKA NATIVE
TRIBAL HEALTH CONSORTIUM
DIVISION OF ENVIRONMENTAL
HEALTH AND ENGINEERING
1901 SOUTH BRAGAW STREET, SUITE 200
ANCHORAGE, ALASKA, 99508-3440
(907) 729-3600

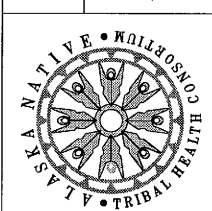


McGrath SUB-REGIONAL
HEALTH CENTER
INTERIOR ELEVATIONS

FILE NAME:
PROJECT NO: 0198
PROJ ARCH: BK


DATE: 4/20/2009
SCALE: AS NOTED
DRAWN BY: CFP CMP

SHEET
A-403
10 OF 13A




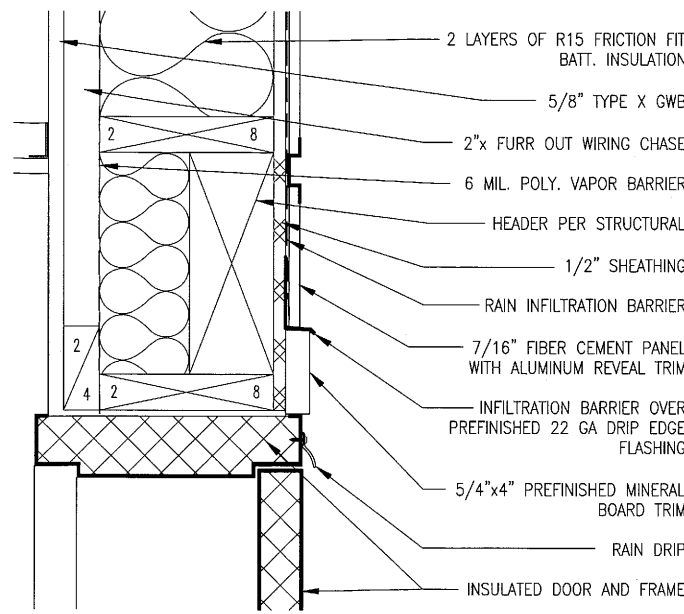


1 Door Head Detail
A501 GRAPHIC: 1" 3" 6"

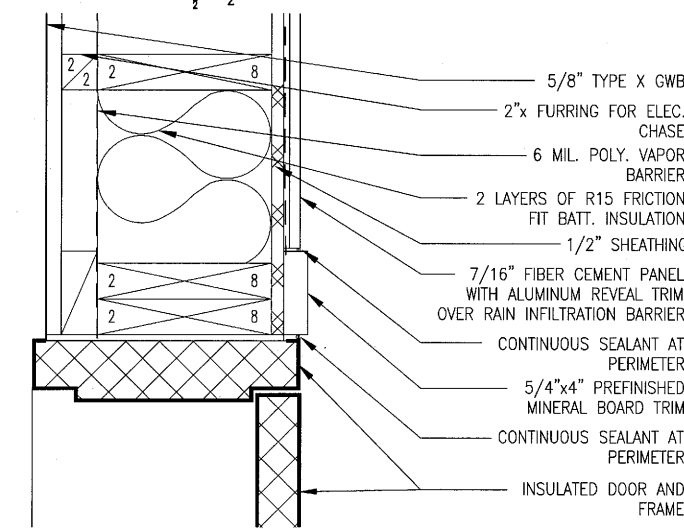


5 Door Jamb Detail
A501 GRAPHIC: 1" 3" 6"

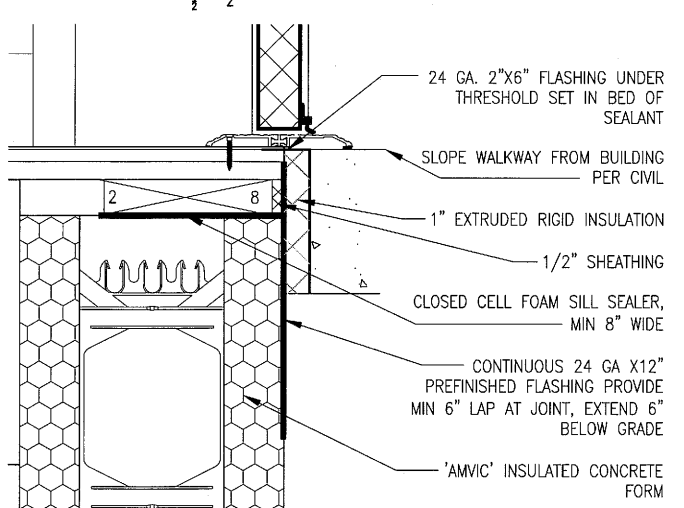


9 Threshold Detail
A501 GRAPHIC: 1" 3" 6"

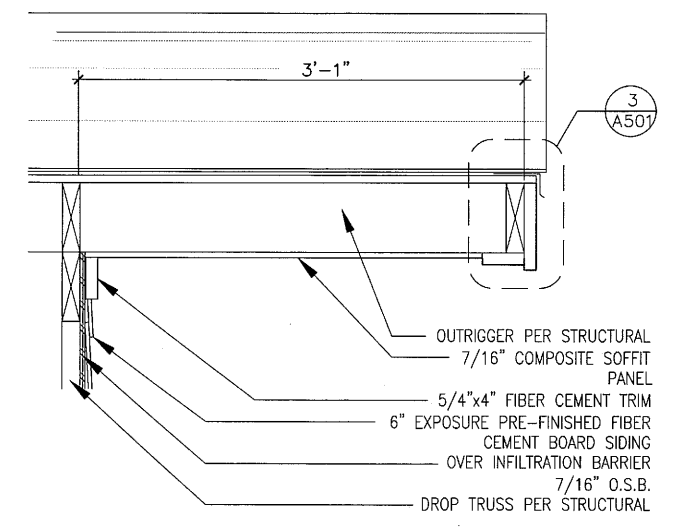


2 Rake Soffit Detail
A501 GRAPHIC: 1" 3" 6" 12"

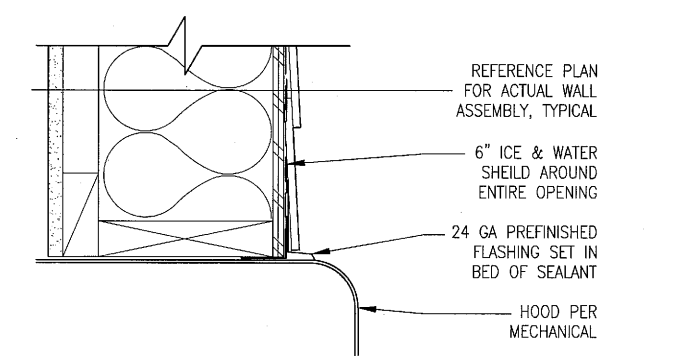


6 Typical Hood Detail
A501 GRAPHIC: 1" 3" 6"

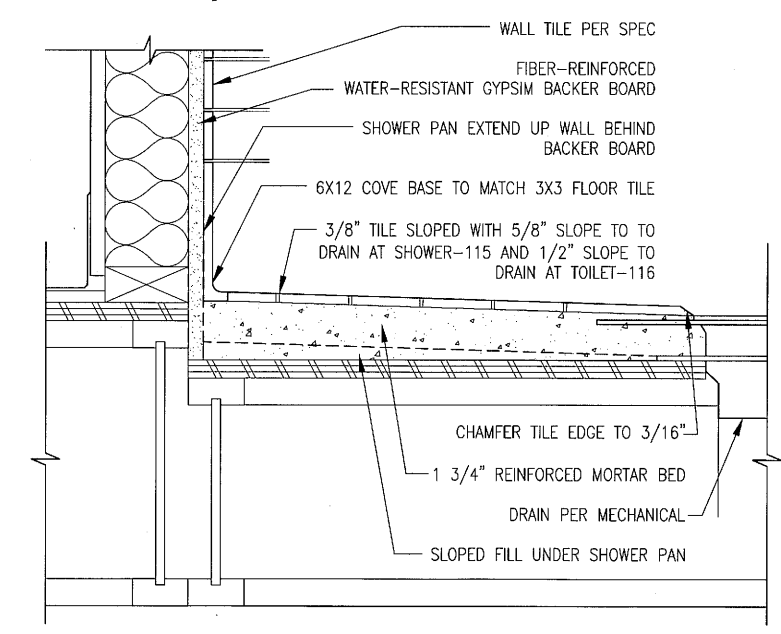


10 Floor Tile Detail
A501 GRAPHIC: 1" 3" 6"

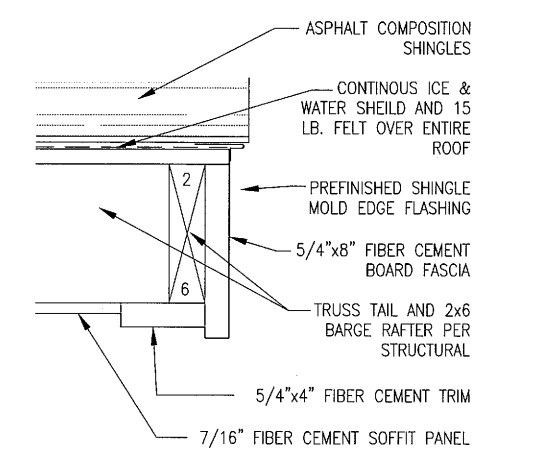


3 Rake Fascia Detail
A501 GRAPHIC: 1" 3" 6"

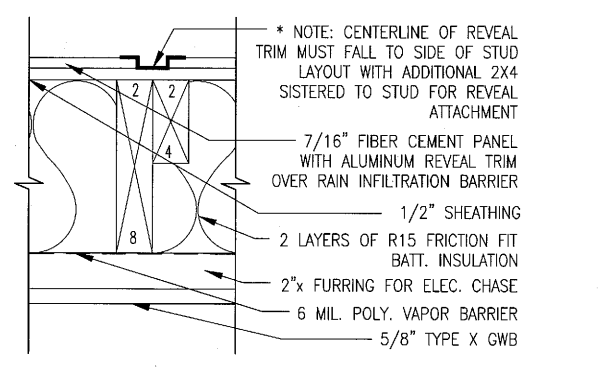


7 Siding Detail
A501 GRAPHIC: 1" 3" 6"

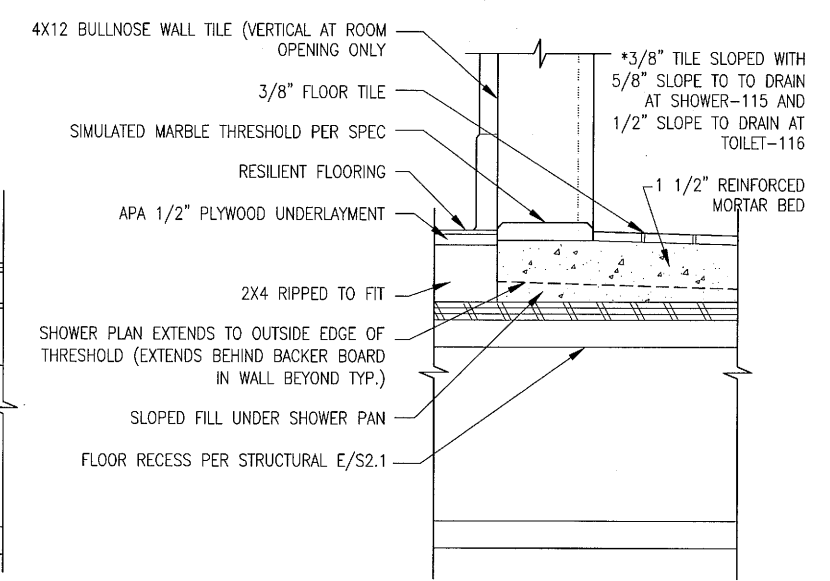


11 Floor Tile Detail
A501 GRAPHIC: 1" 3" 6"

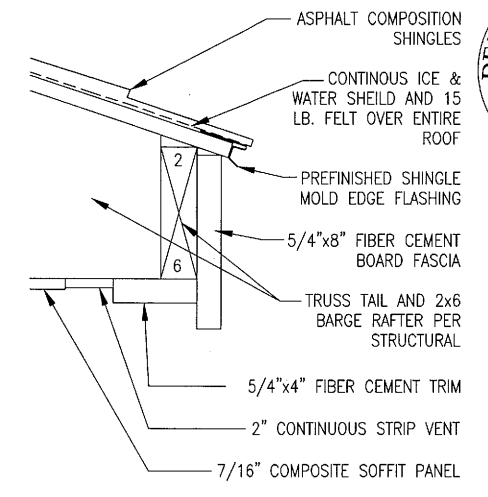

4 Eave Fascia Detail
A501 GRAPHIC: 1" 3" 6"

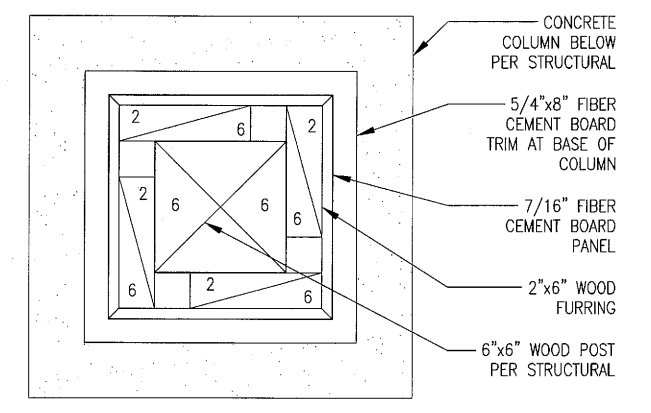


8 Column Detail
A501 GRAPHIC: 1" 3" 6"

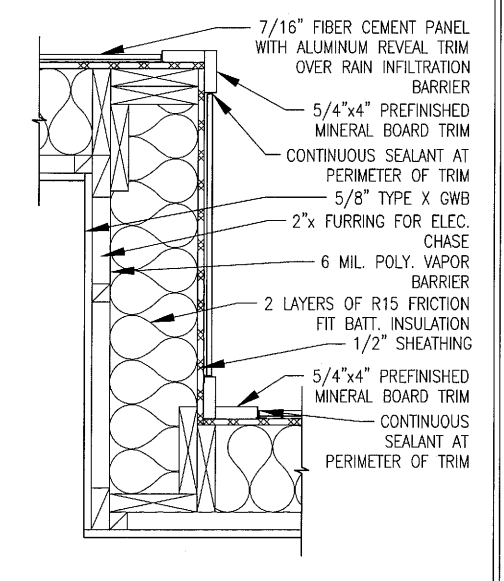

12 Siding Detail
A501 GRAPHIC: 1" 3" 6" 12"




INIT.	
REVISIONS	
DATE	

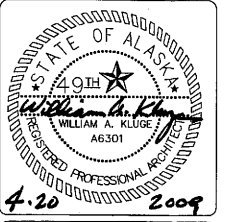

ALASKA NATIVE TRIBAL HEALTH CONSORTIUM

DIVISION OF ENVIRONMENTAL HEALTH AND ENGINEERING

1901 SOUTH BRAGAW STREET, SUITE 200 ANCHORAGE, ALASKA, 99508-3440 (907) 729-3600

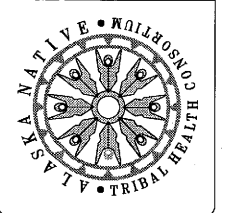

McGRATH SUB-REGIONAL HEALTH CENTER DETAILS

FILE NAME: PROJECT NO: 0198 PROJ ARCH: BK

DATE: 4/20/2009 SCALE: AS NOTED DRAWN BY: CFP CFP

MARK	ROOM NAME	FLOORING	BASE	WALLS				CEILING	CEILING HEIGHT	NOTE
				NORTH	EAST	SOUTH	WEST			
100	ENTRY	F1.1	B1	W1.2	W1.2	W1.2	W1.2	C1	8'-0"	
101	TELE/ELECTRICAL	F1.1	B1	W1.1	W1.1	W1.1	W1.1	C1	8'-0"	
102	H.C. TOILET	F1.1	B2	W1.2/W3	W1.2/W3	W1.2/W3	W1.2/W3	C1	8'-0"	
103	H.C. TOILET	F1.1	B2	W1.2/W3	W1.2/W3	W1.2/W3	W1.2/W3	C1	8'-0"	
104	WAITING	F1.1/F1.2	B1	W1.1/W2	W1.1/W2	W1.1/W2	W1.1/W2	C2	8'-0"	1
105	HEALTH EDUCATOR	F2	B1	W1.3	W1.3	W1.3	W1.3	C2	8'-0"	
106	BH CLINICIAN	F2	B1	W1.3	W1.3	W1.3	W1.3	C2	8'-0"	
107	BH CLINICIAN	F2	B1	W1.3	W1.3	W1.3	W1.3	C2	8'-0"	
108	BH CLINICIAN	F2	B1	W1.3	W1.3	W1.3	W1.3	C2	8'-0"	
109	BH CONFERENCE	F2	B1	W1.3	W1.3	W1.3	W1.3	C2	8'-0"	
110	CORRIDOR	F1.1	B1	W1.1/W2	W1.1/W2	W1.1/W2	W1.1/W2	C2	8'-0"	
111	MECHANICAL	F3	B1	W1.1	W1.1	W1.1	W1.1	C1	8'-0"	
112	LAUNDRY	F1.1	B1	W1.1	W1.1	W1.1	W1.1	C2	8'-0"	
113	CORRIDOR	F1.1	B1	W1.1/W2	W1.1/W2	W1.1/W2	W1.1/W2	C2	8'-0"	
114	TRUAMA EXAM	F1.1	B1/B3	W1.1	W5	W1.1	W5	C2	8'-0"	
115	SHOWER	F4	-	W4	W4	W4	W4	C1	8'-0"	2
116	H.C. TOILET	F4	-	W4	W4	W4	W4	C1	8'-0"	2
117	PHARMACY	F1.1	B1	W1.1	W1.1	W1.1	W1.1	C1	8'-0"	
118	CLEAN/DIRTY	F1.1	B1	W1.1	W1.1	W1.1	W1.1	C1	8'-0"	
119	EXAM	F1.1	B1	W1.1	W1.1	W1.1	W1.1	C2	8'-0"	
120	EXAM	F1.1	B1	W1.1	W1.1	W1.1	W1.1	C2	8'-0"	
121	EXAM	F1.1	B1	W1.1	W1.1	W1.1	W1.1	C2	8'-0"	
122	SPECIALTY PROCEDURE	F1.1	B1	W1.1	W1.1	W1.1	W1.1	C2	8'-0"	
123	FILING/STORAGE	F2	B1	W1.1	W1.1	W1.1	W1.1	C2	8'-0"	
124	BILLING	F2	B1	W1.1	W1.1	W1.1	W1.1	C2	8'-0"	
125	RECORDS	F2	B1	W1.1	W1.1	W1.1	W1.1	C2	8'-0"	
126	RECEPTION	F2	B1	W1.1	W1.1	W1.1	W1.1	C2	8'-0"	
127	WAITING	F1.1/F1.2	B1	W1.1/W2	W1.1/W2	W1.1/W2	W1.1/W2	C2	8'-0"	1
128	ENTRY	F1.1	B1	W1.2	W1.2	W1.2	W1.2	C1	8'-0"	
129	MORGUE/EMS STORAGE	F1.1	B1	W1.1	W1.1	W1.1	W1.1	C1	8'-0"	
130	PATIENT HOLDING/SLEEPING	F2	B1	W1.1	W1.1	W1.1	W1.1	C2	8'-0"	
131	H.C. TOILET	F1.1	B2	W1.2/W3	W1.2/W3	W1.2/W3	W1.2/W3	C1	8'-0"	
132	LAB	F1.1	B1	W1.1	W1.1	W1.1	W1.1	C2	8'-0"	
133	DENTAL	F1.1	B1	W1.1	W1.1	W1.1	W1.1	C2	8'-0"	
134	ADMIN	F2	B1	W1.3	W1.3	W1.3	W1.3	C2	8'-0"	
135	OFFICE	F2	B1	W1.3	W1.3	W1.3	W1.3	C2	8'-0"	
136	OFFICE	F2	B1	W1.3	W1.3	W1.3	W1.3	C2	8'-0"	
137	CORRIDOR	F1.1	B1	W1.1/W2	W1.1/W2	W1.1/W2	W1.1/W2	C2	8'-0"	
138	H.C. TOILET	F1.1	B2	W1.2/W3	W1.2/W3	W1.2/W3	W1.2/W3	C1	8'-0"	
139	STAFF	F1.1	B1	W1.1	W1.1	W1.1	W1.1	C2	8'-0"	
140	CORRIDOR	F1.1	B1	W1.1/W2	W1.1/W2	W1.1/W2	W1.1/W2	C2	8'-0"	
141	JANITOR	F1.1	B1	W1.1/W2	W1.1/W2	W1.1/W2	W1.1/W2	C1	10'-1/2"	
142	CONFERENCE	F2	B1	W1.1	W1.1	W1.1	W1.1	C2	8'-0"	
143	STORAGE	F2	B1	W1.3	W1.3	W1.3	W1.			

1. THE CONTRACTOR SHALL PROPERLY PREPARE THE SURFACES PER FINISH MANUFACTURER'S SPECIFICATIONS PRIOR TO APPLICATION OF FINISH. ALL FINISHES AND ADJOINING SURFACES SHALL REMAIN FREE OF GLUE, PLASTER AND PAINT EXCESS.

2. THE GENERAL CONTRACTOR SHALL BE RESPONSIBLE FOR ALL COORDINATION BETWEEN TRADES TO INSURE PROPER INSTALLATION OF FINISH FOR COLORS AND QUALITIES.

3. PREPARE FLOOR AREAS AS REQUIRED TO RECEIVE FLOOR FINISHES, INCLUDING FLASH PATCHING REQUIRED TO LEVEL TO 1/4" IN 20' AND SMOOTH FLOOR.

4. ANY CHANGE IN FLOOR FINISH SHALL OCCUR AT CENTERLINE OF DOOR OR CASED OPENING UNLESS OTHERWISE NOTED. E INTERIOR FINISHES, IN MEANS OF 508000, SHALL BE 2-1/2" x 4" GYP BOARD.











5. PROVIDE ACOUSTICAL SEALANT AT ALL EDGES AND PENETRATIONS THROUGH ACOUSTICAL WALLS.

6. ALL WALLS ARE TO EXTEND TO STRUCTURE ABOVE AS APPROPRIATE. REFERENCE WALL SECTIONS SHEETS A4.3 AND A4.4. 3. ALL DIMENSIONS ARE TO FACE OF FRAMING TYPICAL UNLESS OTHERWISE

7. REFER TO SHEET F1.1 FOR MODULAR CABINETRY/FURNISHINGS PROVIDED AND INSTALLED BY OWNER. CONTRACTOR SHALL BE

RESPONSIBLE FOR COORDINATING ALL ROOM FINISHES, PLUMBING AND ELECTRICAL ITEMS IMPACTING SAID ROOM FURNISHINGS.

8. ALL FLOOR BASE SHALL BE SEALED TO FLOORING WITH A FINE BEAD OF SEALANT AT THE BOTTOM EDGE OF THE BASE.

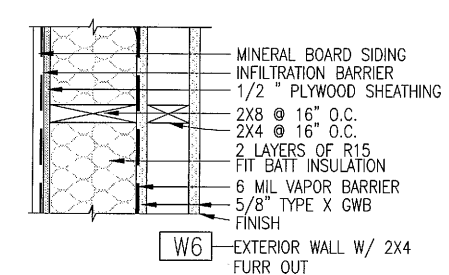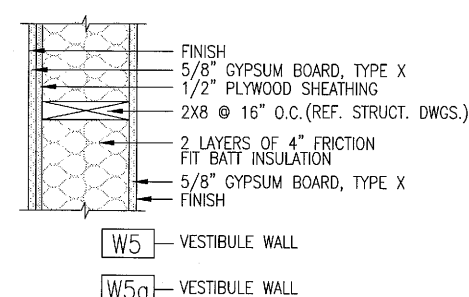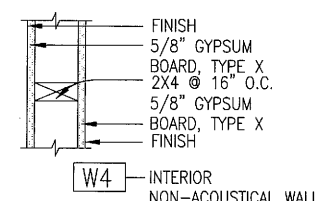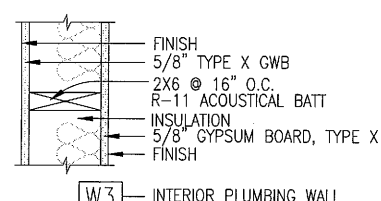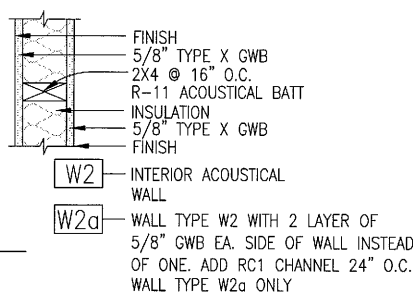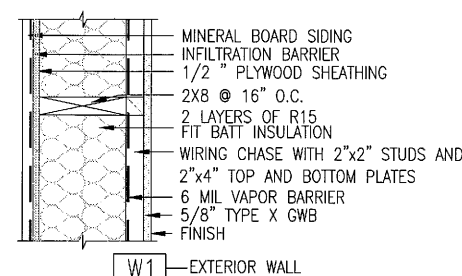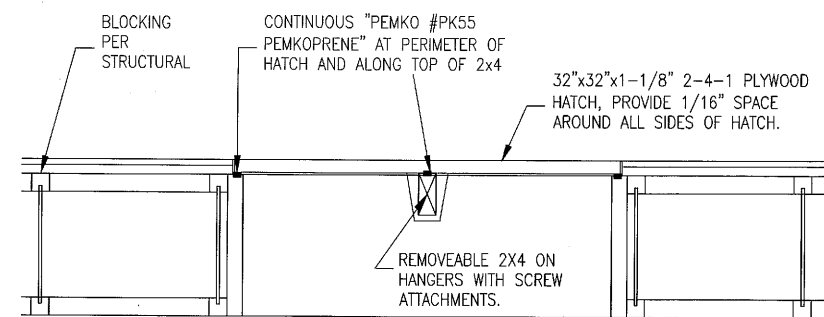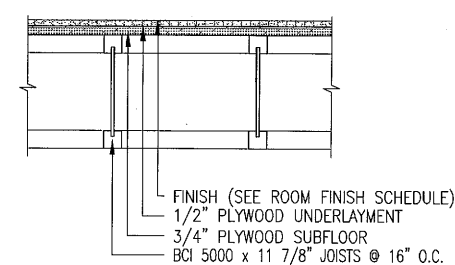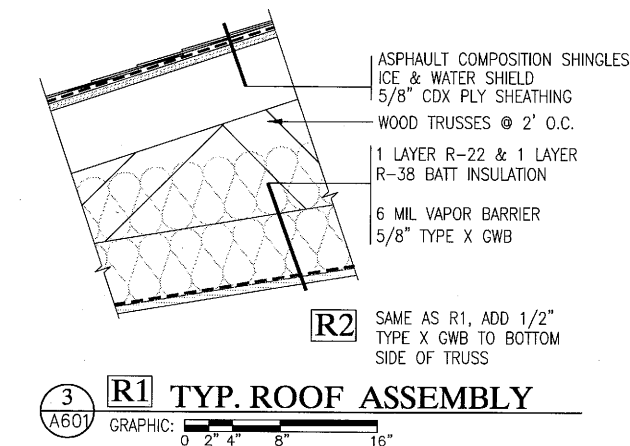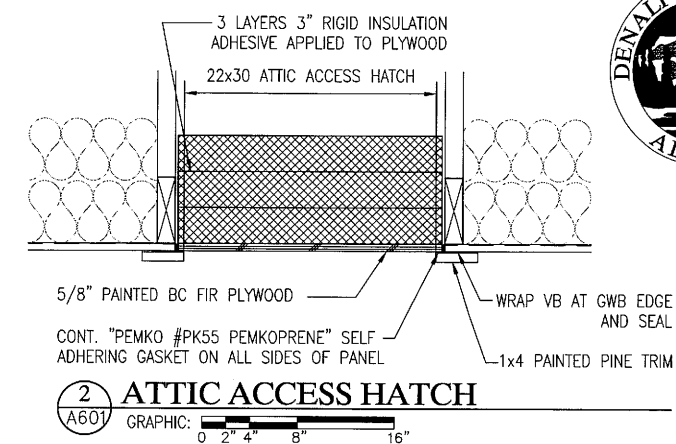


A601 GRAPHIC:

NOTE:
1. ALL WALLS SHALL BE W2 TYPICAL UNLESS OTHERWISE
NOTED PER A-102


DOOR NUMBER	ROOM NAME & NUMBER	DOOR						FRAME		HARDWARE GROUP	RATING	THRESHOLD	HEAD DETAIL	JAMB DETAIL	SILL DETAIL	REMARKS
		WIDTH	HEIGHT	TYPE	THICK.	MAT.	FINISH	MAT.	FINISH							
100A	ENTRY-100	3'-0"	7'-0"	A	1 3/4"	INS ST	EPS 30	INS ST	EPS 30	4	NR	YES	1/A501	5/A501	9/A501	
100B	ENTRY-100	3'-0"	7'-0"	A	1 3/4"	INS ST	IPS 40	INS ST	IPS 40	2	20 MIN	YES	1/A501	5/A501	9/A501	
101	TELE/ELECTRICAL-101	3'-0"	7'-0"	B	1 3/8"	SCW	FACTORY	H.M.	IPS 40	1	NR	----	1/A602	3/A602	----	
102	H.C. TOILET-102	3'-0"	7'-0"	B	1 3/8"	SCW	FACTORY	H.M.	IPS 40	3	20 MIN	----	1/A602	3/A602	----	
103	H.C. TOILET-103	3'-0"	7'-0"	B	1 3/8"	SCW	FACTORY	H.M.	IPS 40	3	20 MIN	----	1/A602	3/A602	----	
105	HEALTH EDUC.-105	3'-0"	7'-0"	B	1 3/8"	SCW	FACTORY	H.M.	IPS 40	1	20 MIN	----	1/A602	3/A602	----	
106	BH CLINICIAN-106	3'-0"	7'-0"	B	1 3/8"	SCW	FACTORY	H.M.	IPS 40	1	20 MIN	----	1/A602	3/A602	----	
107	BH CLINICIAN-107	3'-0"	7'-0"	B	1 3/8"	SCW	FACTORY	H.M.	IPS 40	1	20 MIN	----	1/A602	3/A602	----	
108	BH CLINICIAN-108	3'-0"	7'-0"	B	1 3/8"	SCW	FACTORY	H.M.	IPS 40	1	20 MIN	----	1/A602	3/A602	----	
109	BH CLINICIAN-109	3'-0"	7'-0"	B	1 3/8"	SCW	FACTORY	H.M.	IPS 40	1	20 MIN	----	1/A602	3/A602	----	
111	MECHANICAL-111	3'-0"	7'-0"	B	1 3/4"	INS ST	EPS 30	INS ST	EPS 30	7	NR	YES	1/A501	5/A501	9/A501	
112	LAUNDRY-112	3'-0"	7'-0"	B	1 3/8"	SCW	FACTORY	H.M.	IPS 40	1	20 MIN	----	1/A602	3/A602	----	
113	HALL-113	3'-0"	7'-0"	E	1 3/8"	SCW	FACTORY	H.M.	IPS 40	1	NR	----	1/A602	3/A602	----	
114	TRUAMA EXAM-114	4'-0"	7'-0"	B	1 3/8"	SCW	FACTORY	H.M.	IPS 40	6	20 MIN	----	1/A602	3/A602	----	
116	H.C. TOILET-116	3'-0"	7'-0"	B	1 3/8"	SCW	FACTORY	H.M.	IPS 40	3	NR	----	1/A602	3/A602	----	
117	PHARMACY-117	3'-0"	7'-0"	E	1 3/8"	SCW	FACTORY	H.M.	IPS 40	1	20 MIN	----	1/A602	3/A602	----	
119	EXAM-119	3'-0"	7'-0"	B	1 3/8"	SCW	FACTORY	H.M.	IPS 40	1	20 MIN	----	1/A602	3/A602	----	
120	EXAM-120	3'-0"	7'-0"	B	1 3/8"	SCW	FACTORY	H.M.	IPS 40	1	20 MIN	----	1/A602	3/A602	----	
121	EXAM-121	3'-0"	7'-0"	B	1 3/8"	SCW	FACTORY	H.M.	IPS 40	1	20 MIN	----	1/A602	3/A602	----	
122A	SPEC. PROCD.-122	3'-0"	7'-0"	B	1 3/8"	SCW	FACTORY	H.M.	IPS 40	1	20 MIN	----	1/A602	3/A602	----	
122B	SPEC. PROCD.-122	3'-0"	7'-0"	B	1 3/8"	SCW	FACTORY	H.M.	IPS 40	1	20 MIN	----	1/A602	3/A602	----	
123	FILING/STR.-123	3'-0"	7'-0"	B	1 3/8"	SCW	FACTORY	H.M.	IPS 40	1	20 MIN	----	1/A602	3/A602	----	
124	BILLING-124	3'-0"	7'-0"	E	1 3/8"	SCW	FACTORY	H.M.	IPS 40	1	20 MIN	----	1/A602	3/A602	----	
125	RECORDS-125	3'-0"	7'-0"	B	1 3/8"	SCW	FACTORY	H.M.	IPS 40	1	20 MIN	----	1/A602	3/A602	----	
126	RECEPTION-126	3'-0"	7'-0"	E	1 3/8"	SCW	FACTORY	H.M.	IPS 40	1	NR	----	1/A602	3/A602	----	
128A	ENTRY-128	4'-0"	7'-0"	A	1 3/4"	INS ST	EPS 30	INS ST	EPS 30	4	NR	YES	1/A501	5/A501	9/A501	
128B	ENTRY-128	4'-0"	7'-0"	A	1 3/4"	INS ST	IPS 40	INS ST	IPS 40	2	NR	YES	1/A501	5/A501	9/A501	
129	MORGUE/EMS-129	4'-0"	7'-0"	B	1 3/4"	SCW	IPS 40	H.M.	IPS 40	2	NR	----	1/A602	3/A602	----	
130	PATIENT HOLD.-130	3'-0"	7'-0"	B	1 3/8"	SCW	FACTORY	H.M.	IPS 40	1						

NOTES

1. DOOR NUMBERS 104, 110, 115, 118, 127 & 140 ARE NOT USED.
2. ALL RATED DOORS REQUIRE RATED DOOR/FRAME ASSEMBLY.
3. DOORS 113 & 137 SHALL BE LOCKABLE FROM 127 AND ALWAYS UNLOCKED FROM HALL-110 & HALL-137.

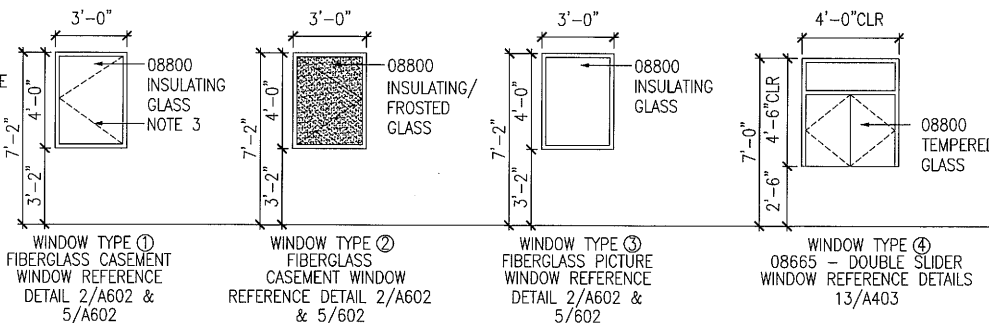

A602 GRAPHIC:

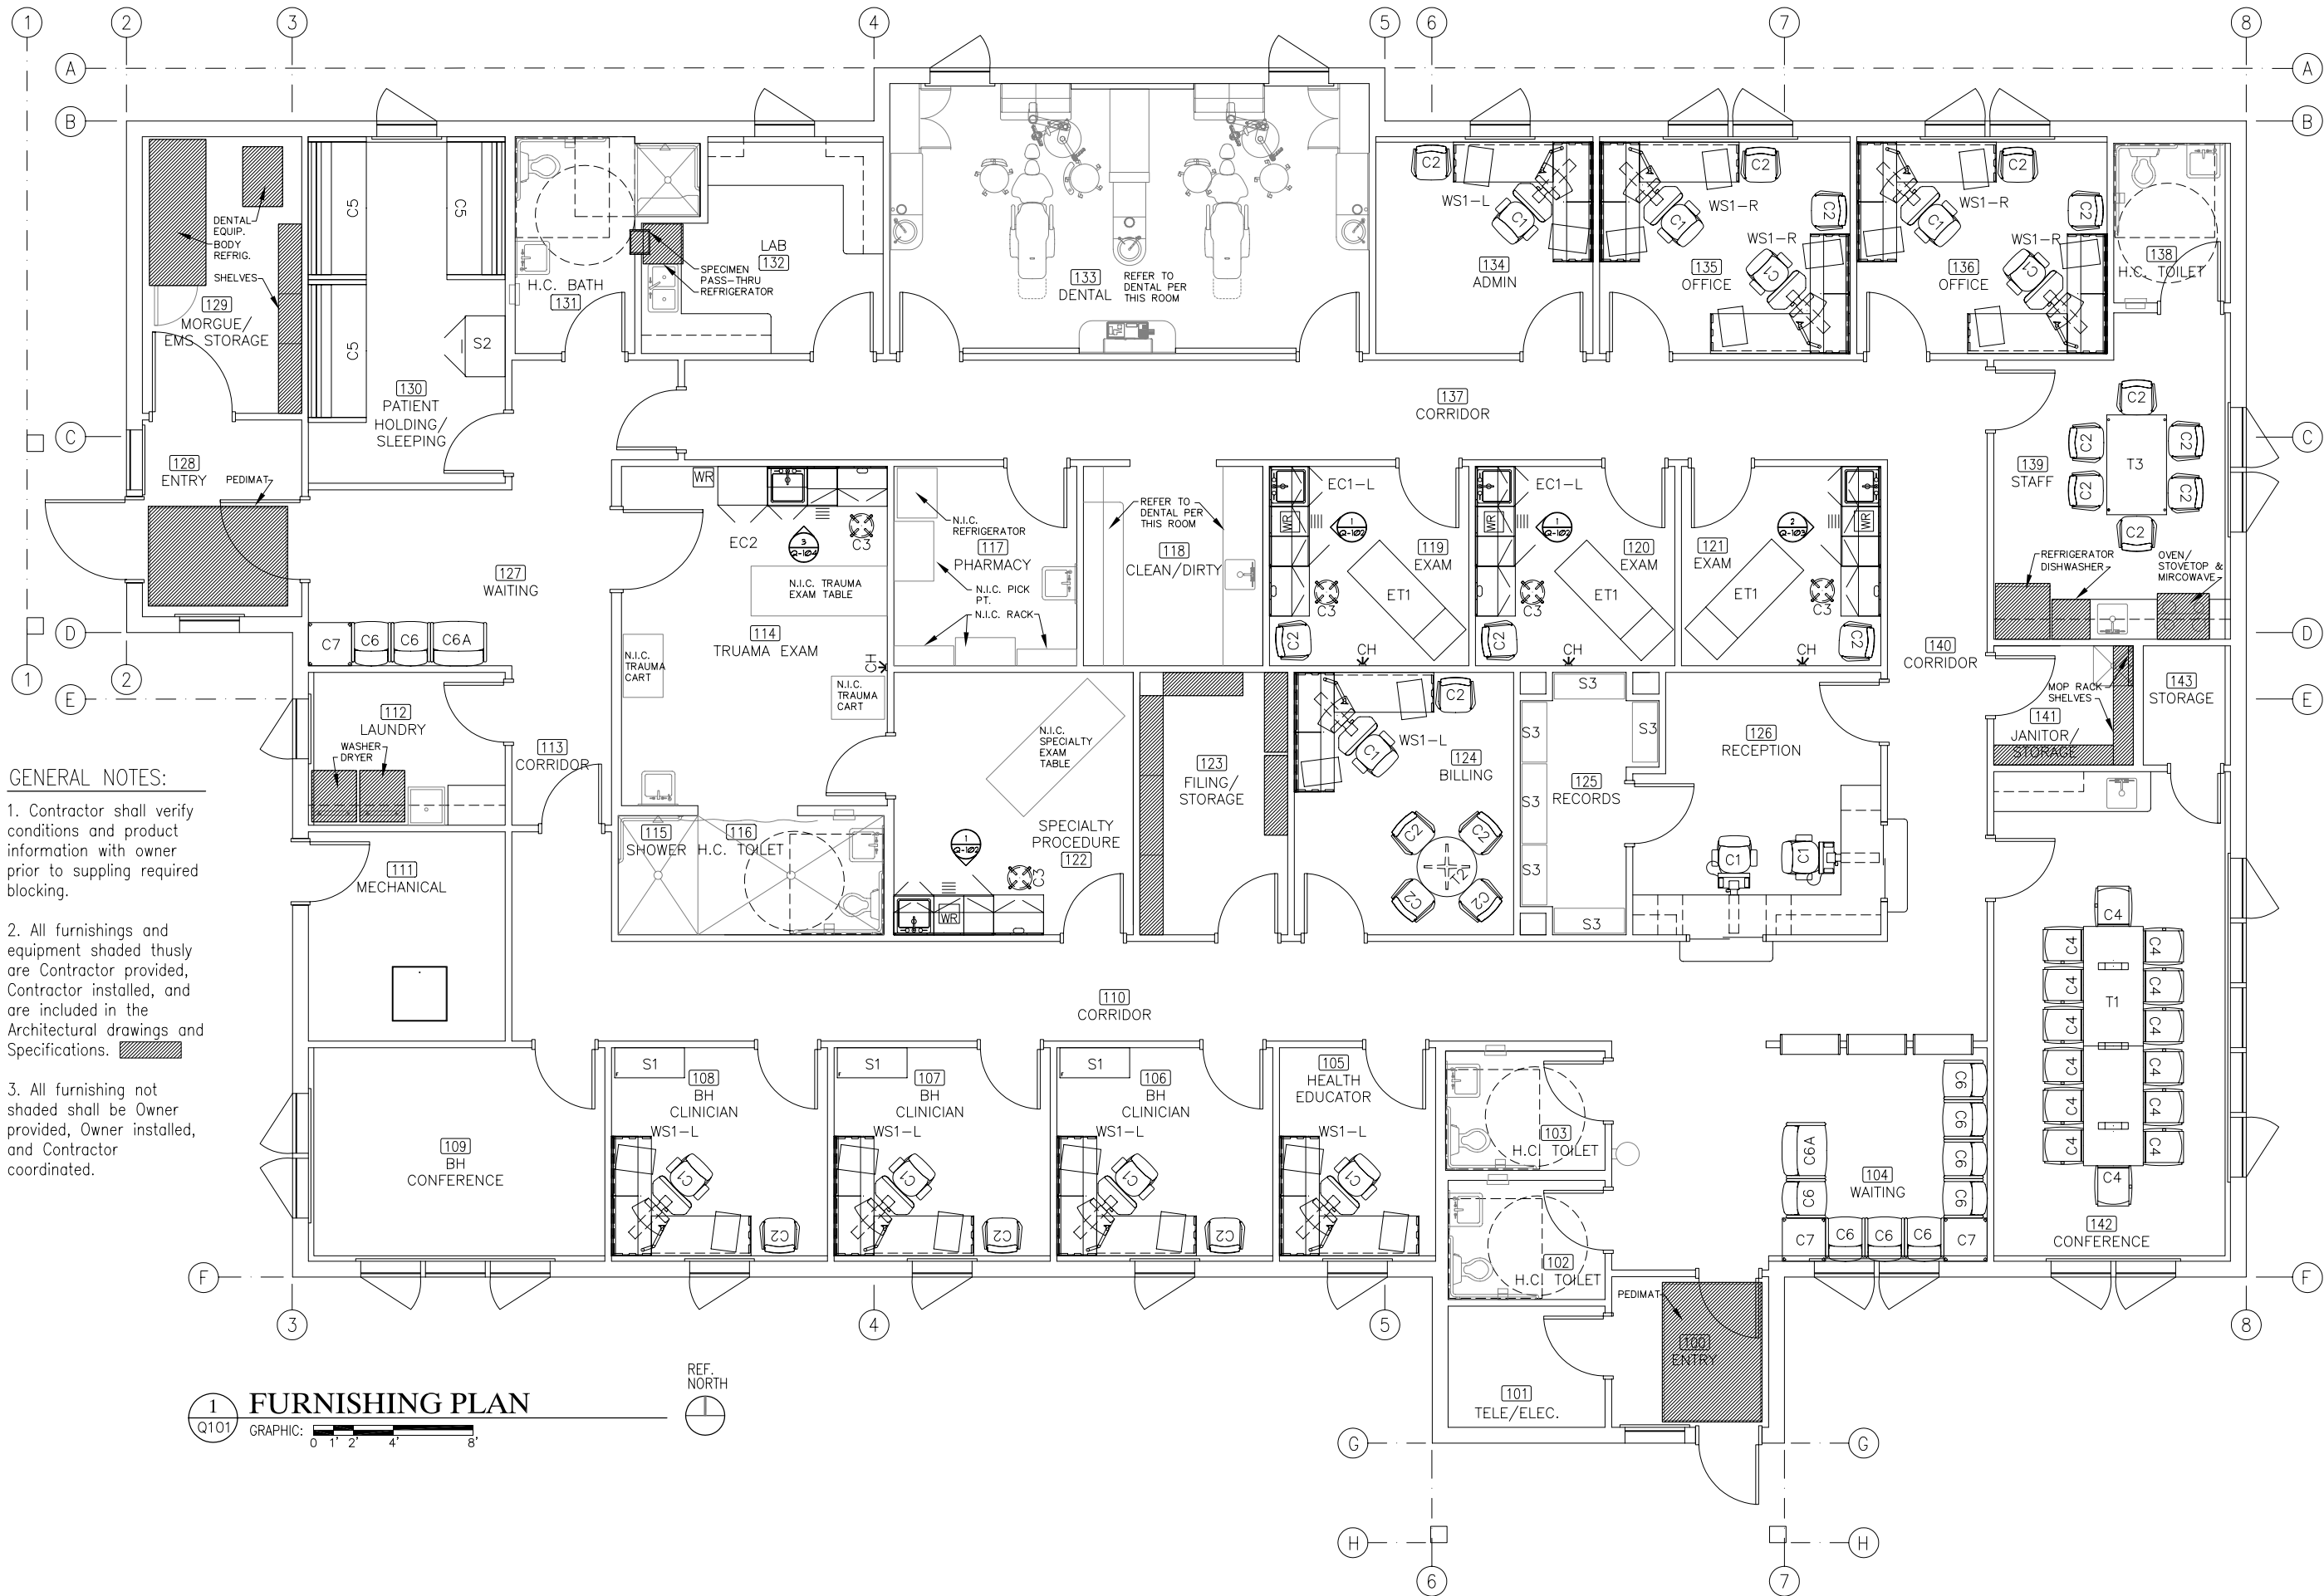

GENERAL NOTES:

1. Contractor shall verify conditions and product information with owner prior to supplying required blocking.
2. All furnishings and equipment shaded thusly are Contractor provided, Contractor installed, and are included in the Architectural drawings and Specifications.
3. All furnishing not shaded shall be Owner provided, Owner installed, and Contractor coordinated.

1 FURNISHING PLAN
Q101 GRAPHIC: 0 1' 2' 4' 8'



INIT.	
REVISIONS	
DATE	



ALASKA NATIVE
TRIBAL HEALTH CONSORTIUM
DIVISION OF ENVIRONMENTAL
HEALTH AND ENGINEERING
1901 SOUTH BRAGAW STREET, SUITE 200
ANCHORAGE, ALASKA, 99508-3440
(907) 729-3600

 


McGRATH SUB-REGIONAL
HEALTH CENTER
FURNISHING PLAN

FILE NAME:
PROJECT NO: 0198
PROJ ARCH: BK
DATE: 4/20/2009
SCALE: AS NOTED
DRAWN BY:


SHEET
Q-101

1 OF 6Q

[illegible]

ALASKA NATIVE
TRIBAL HEALTH CONSORTIUM

DIVISION OF ENVIRONMENTAL
HEALTH AND ENGINEERING
901 SOUTH BRAGAW STREET, SUITE 200
ANCHORAGE, ALASKA, 99508-3440
(907) 270-3600

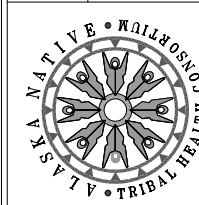


McGRATH SUB-REGIONAL
HEALTH CENTER
FURNISHING PLAN


DATE: 3/25/2009	FILE NAME:
SCALE: AS NOTED	PROJECT NO: 0198
DRAWN BY:	PROJ ARCH BK

SHEET
Q-102


2 OF 6Q

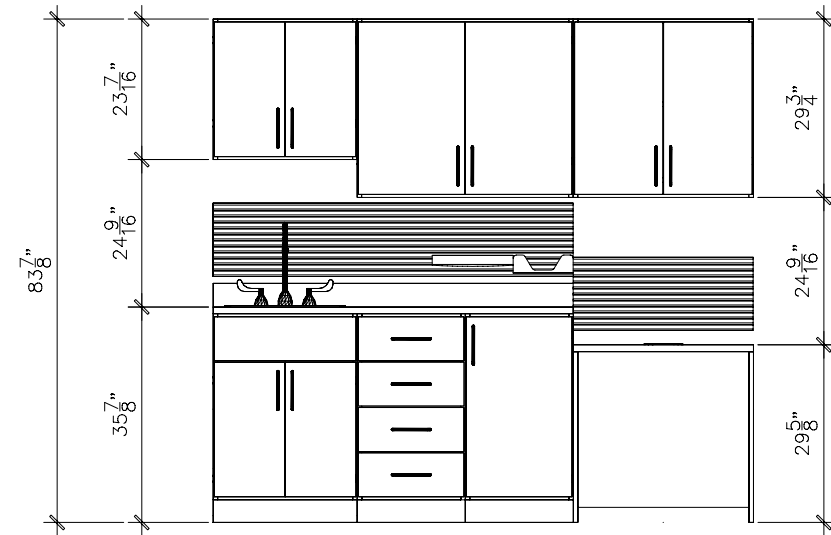

2 ELEVATION - EC1-R
Q-10 SCALE: 3/4"=1'-0"

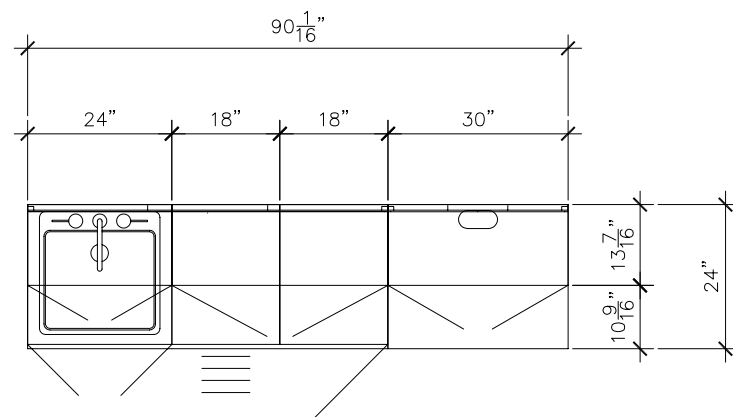

2 PLAN - EC1-R
Q-10 SCALE: 3/4"=1'-0"

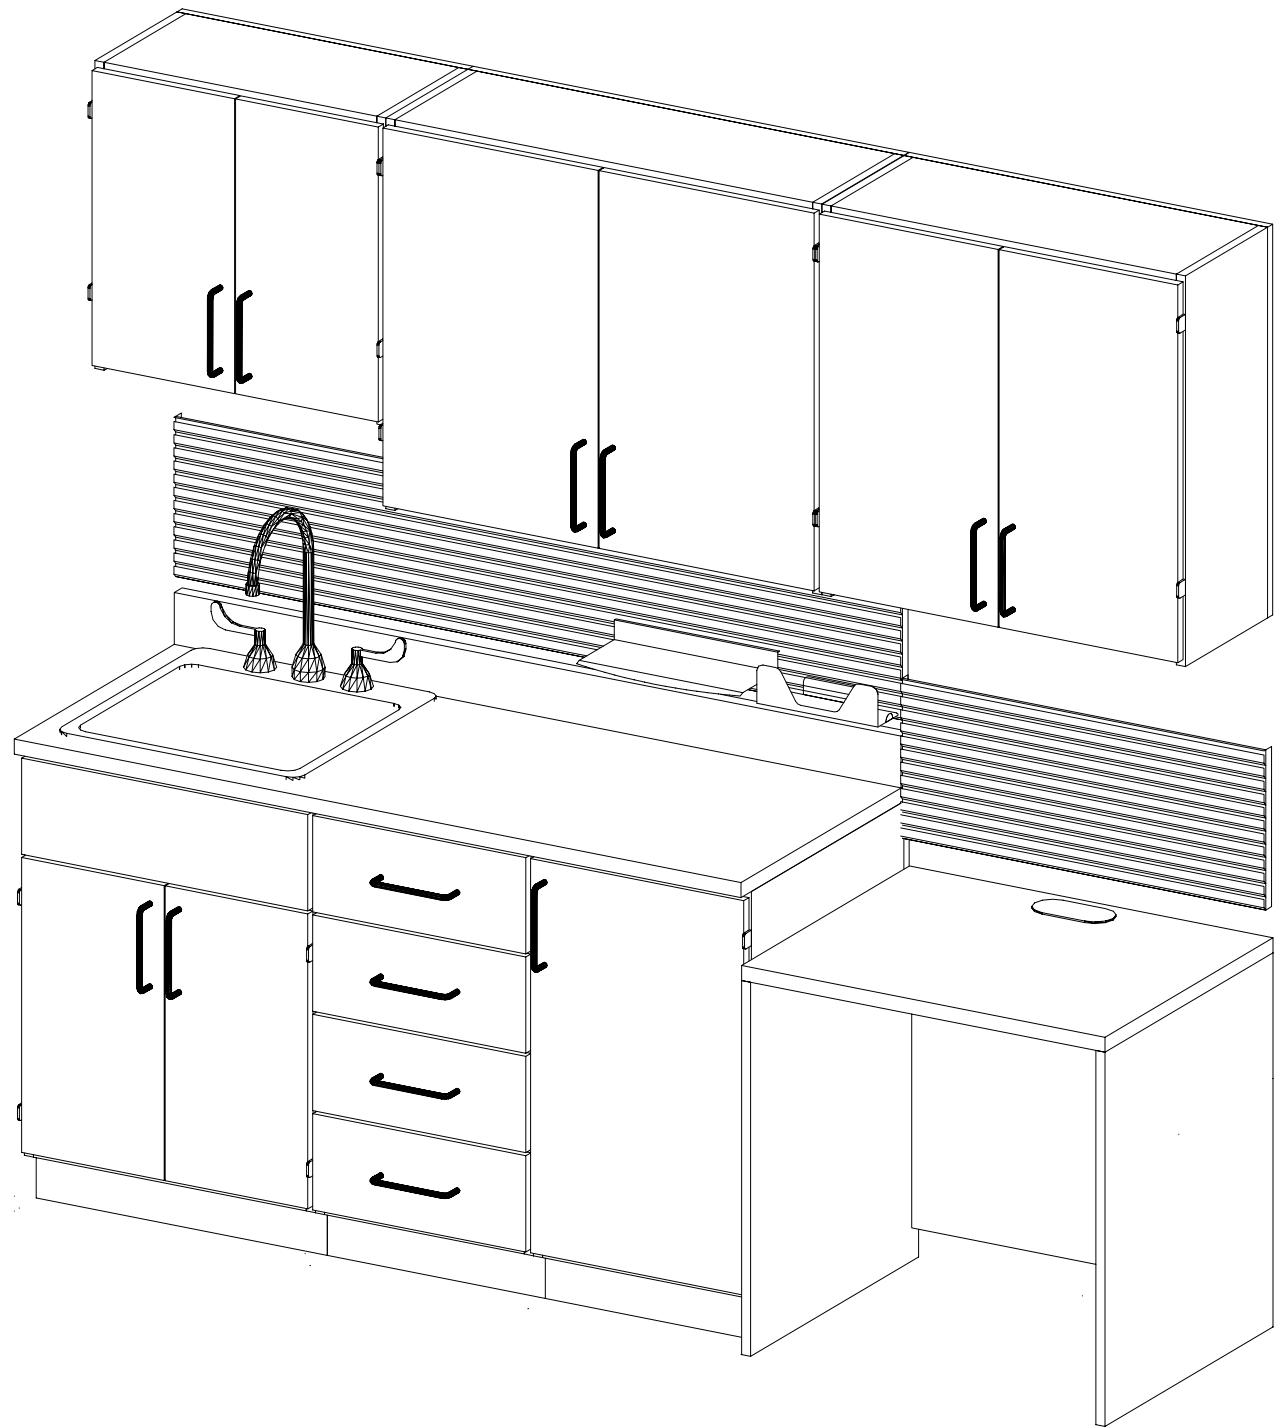

2 3D VIEW - EC1-R

Q-101

SCALE: N.T.S.

[illegible]

ALASKA NATIVE
TRIBAL HEALTH CONSORTIUM

DIVISION OF ENVIRONMENTAL
HEALTH AND ENGINEERING
1901 SOUTH BRAGAW STREET, SUITE 200
ANCHORAGE, ALASKA, 99508-3440
(907) 729-3600




McGRATH SUB-REGIONAL
HEALTH CENTER
FURNISHING PLAN

DATE: 3/25/2009
SCALE: AS NOTED
DRAWN BY: _____


FILE NAME: _____
PROJECT NO: 0198
PROJ ARCH. BK

SHEET
Q-103


3 OF 6Q

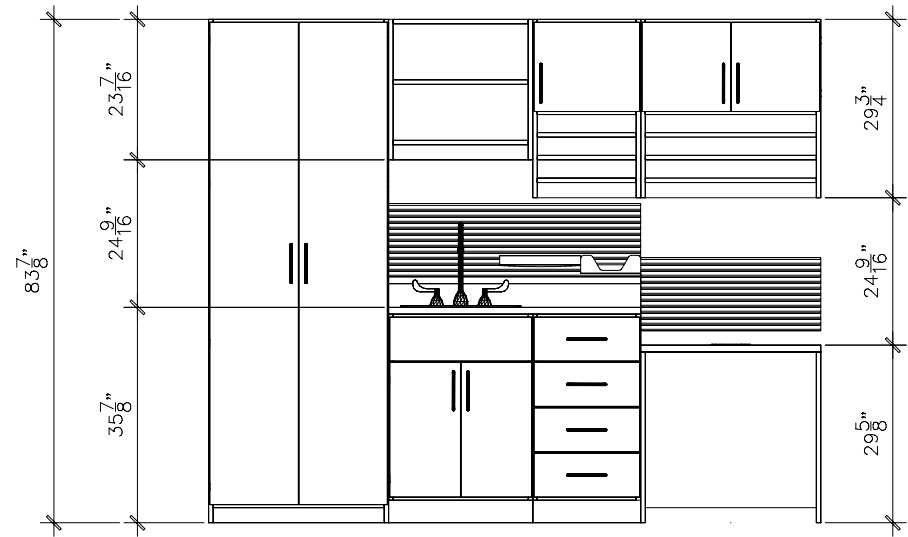

ELEVATION - EC2

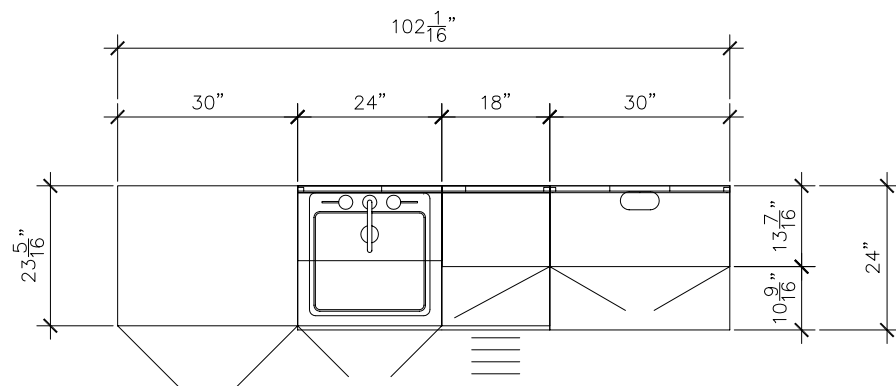


PLAN - EC2
SCALE: 3/4"=1'-0"

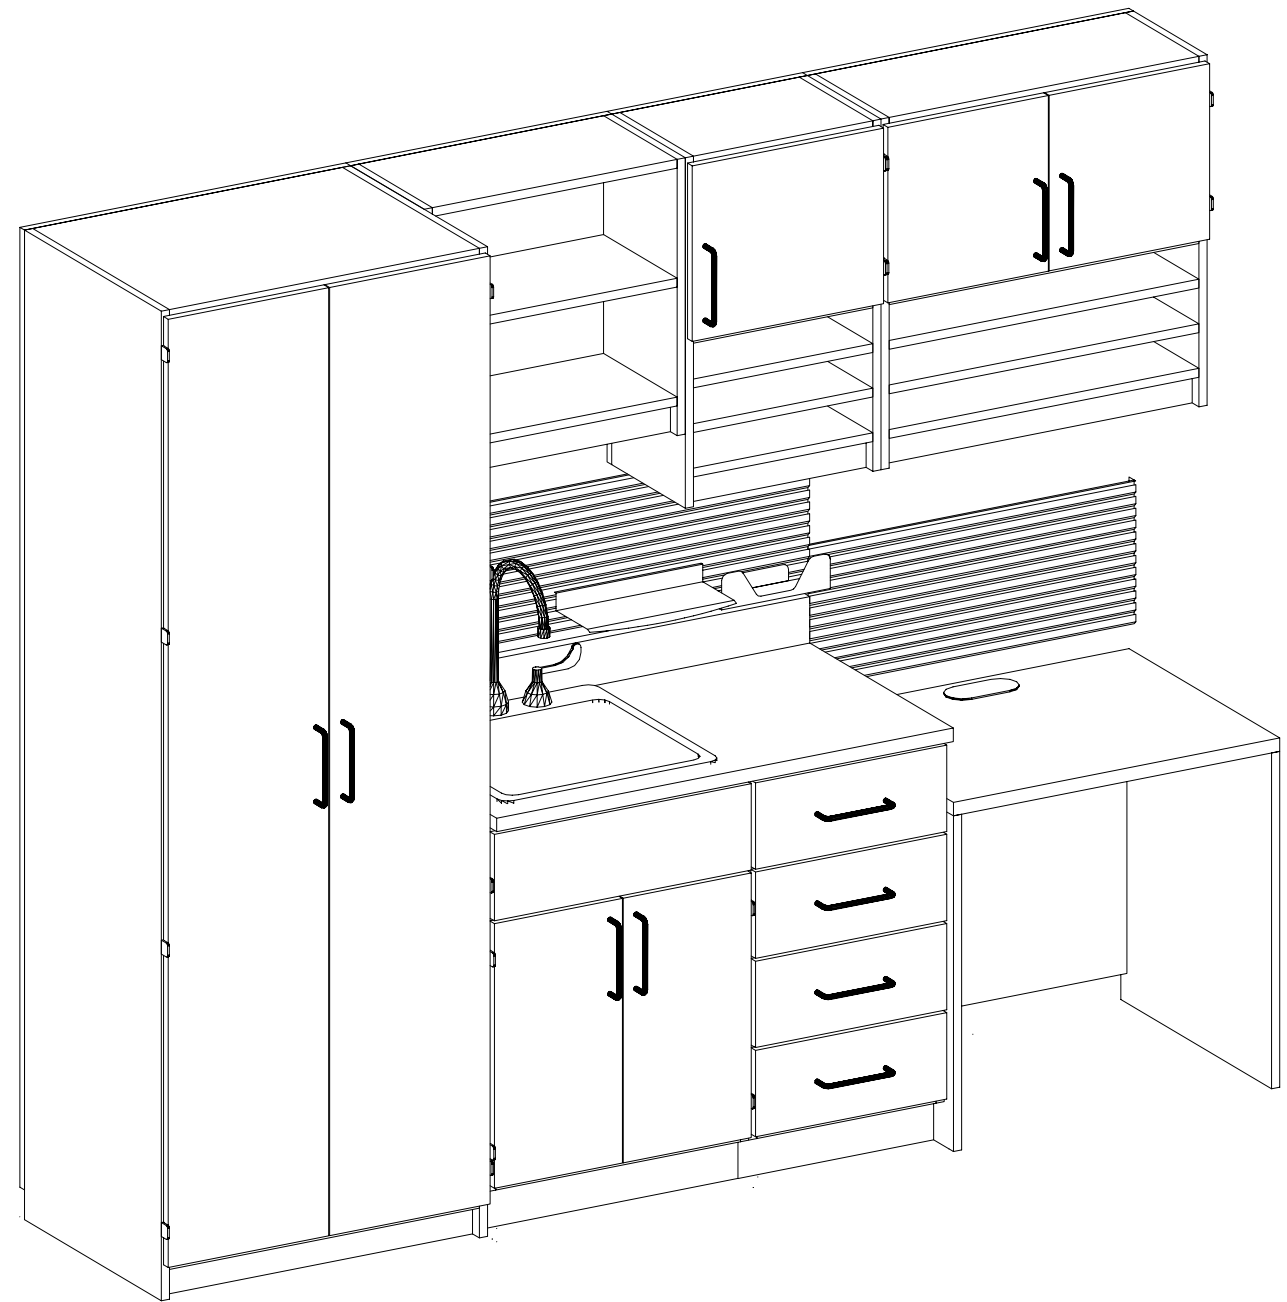

3D VIEW - EC2

Q-107

SCALE: N.T.S.



TRIBAL HEALTH CONSORTIUM
**DIVISION OF ENVIRONMENTAL
HEALTH AND ENGINEERING**
1901 SOUTH BRAGAW STREET, SUITE 200
ANCHORAGE, ALASKA, 99508-3440
(907) 729-3600



2009	FILE NAME:
TOTED	PROJECT NO: 0198
	PROJ ARCH: BK

DATE: 3/25/2009
SCALE: AS NOTED
DRAWN BY: _____

SHEET
Q-104
4 OF 6Q

[illegible]



WSI 3D VIEW - OFFICE WORKSTATION
Q-101 SCALE: N.T.S.

[illegible]

ALASKA NATIVE
TRIBAL HEALTH CONSORTIUM

DIVISION OF ENVIRONMENTAL
HEALTH AND ENGINEERING
1901 SOUTH BRAGAW STREET, SUITE 200
ANCHORAGE, ALASKA. 99508-3440
(907) 729-3600



McGRATH SUB-REGIONAL
HEALTH CENTER
FURNISHING PLAN

DATE: 3/25/2009
SCALE: AS NOTED
DRAWN BY: _____

SHEET
Q-105

5 OF 6Q

FURNITURE LEGEND:

C1	'LEAP' TASK CHAIR
C2	'PLAYER' GUEST CHAIR
C3	'VERGE' STOOL
C4	'REINHARD' CONFERENCE CHAIR
C5	'Siesta' SLEEPER
C6	OUTLOOK 'HAWTHORNE' SINGLE SEAT, ARM, CHAIR
C6A	OUTLOOK 'HAWTHORNE' BARIATRIC, SINGLE SEAT CHAIR
C7	OUTLOOK 'HAWTHORNE' TABLE, WD EDGE
T1	'CONVENE' CONFERENEC TABLE, LAMINATE, WD EDGE WITH TWO POWER UNITS
T2	'AU LAIT' TABLE, LAMINATE, WD EDGE
T3	'ARRIVA' TABLE, LAMINATE
S1	LATERAL FILE, 4 DRAWER
S2	'SHAKER' WARDROBE, WOOD, DOUBLE DOOR W/DRAWER
S3	HIGH DENSITY FILING, OPEN SHELF, LEGAL
ET1	'ACCESS' HIGH-LOW EXAM TABLE
WR	WASTE CAN, SQUARE STEEL
CH	COAT HOOK

FURNITURE LEGEND:


[illegible]

FURNITURE LEGEND

[illegible]

ALASKA NATIVE
TRIBAL HEALTH CONSORTIUM

DIVISION OF ENVIRONMENTAL
HEALTH AND ENGINEERING
1901 SOUTH BRAGAW STREET, SUITE 2000
ANCHORAGE, ALASKA, 99508-3440
(907) 729-3600

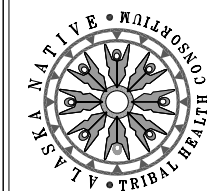


McGRATH SUB-REGIONAL
HEALTH CENTER
FURNISHING PLAN


DATE: 3/25/2009
SCALE: AS NOTED
DRAWN BY: _____

SHEET
Q-106

6 OF 6Q

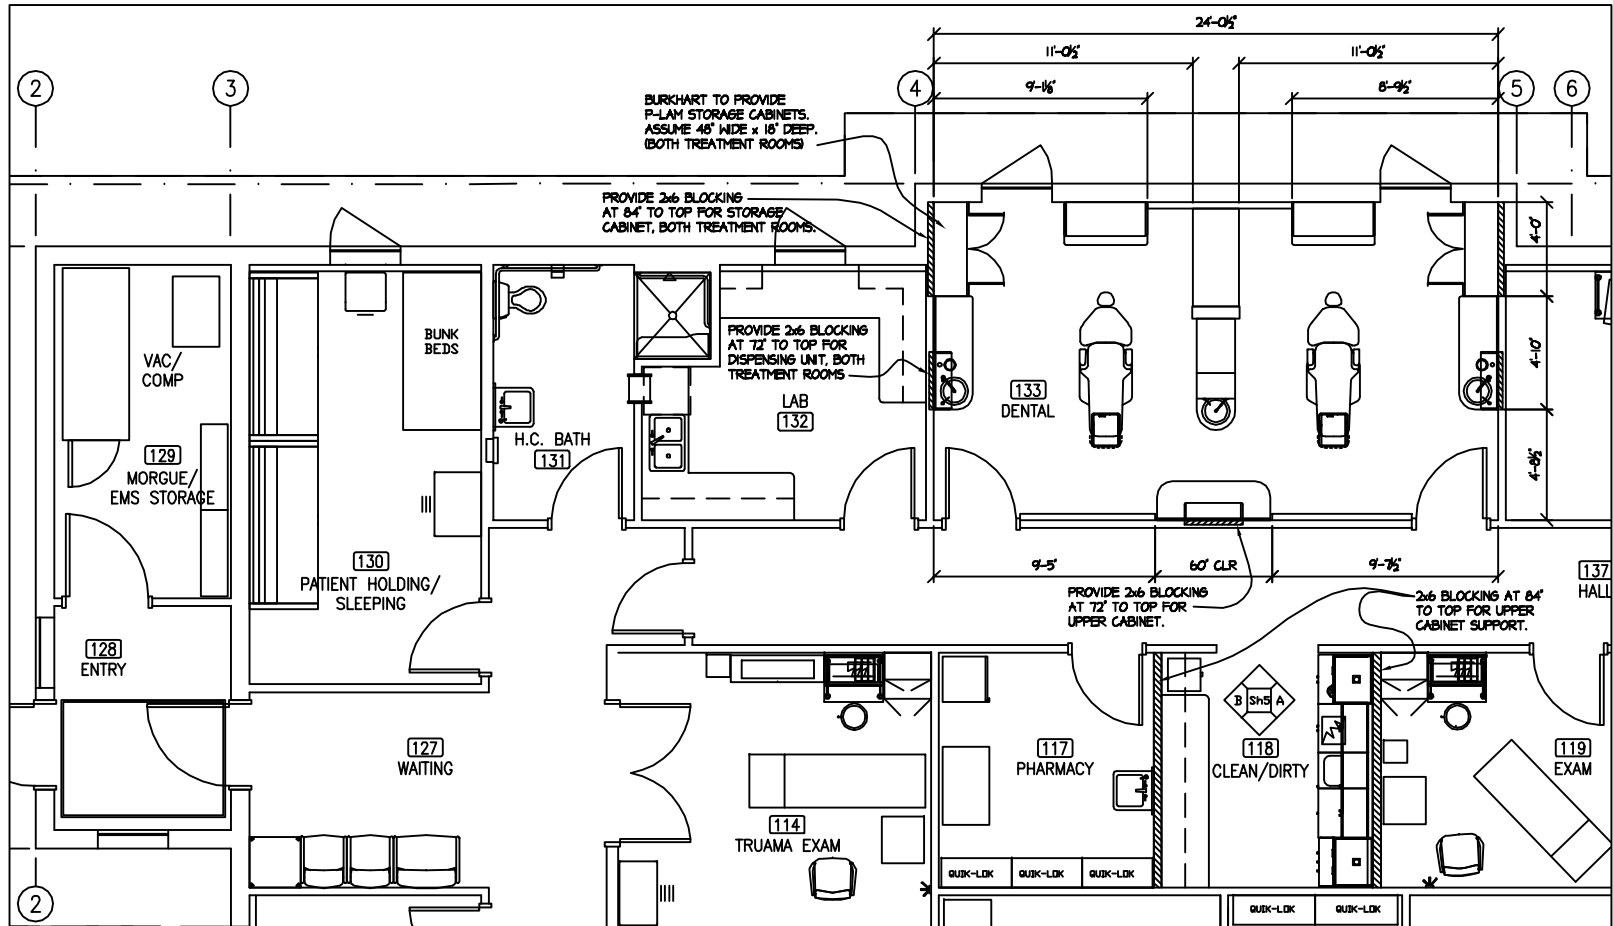

FLOOR & BRACING PLAN
APPROX. 600 USEABLE SQ. FT. (LEASEHOLD AREA MAY VARY)

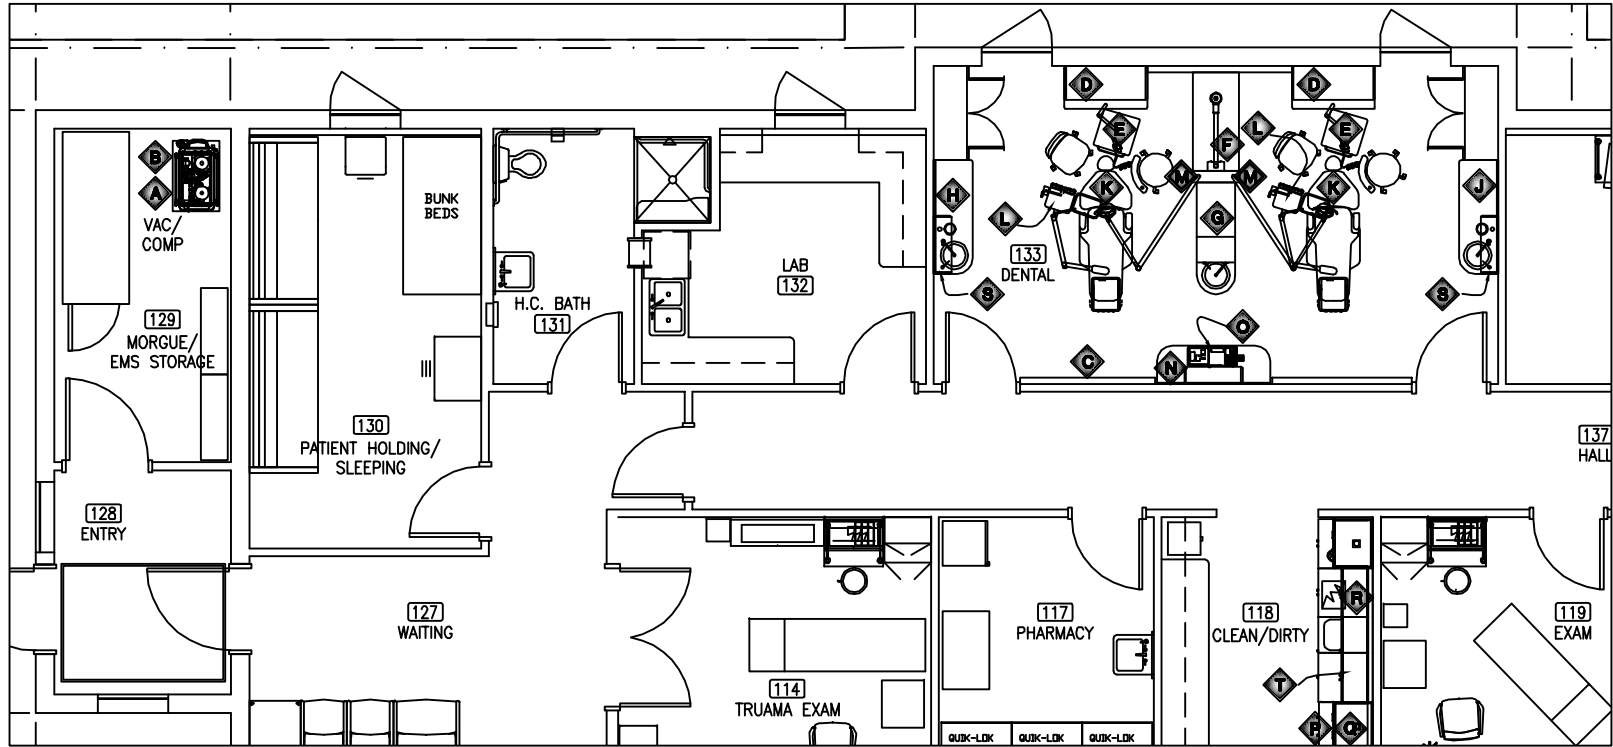

EQUIPMENT SCHEDULE PLAN

DENTAL EQUIPMENT PLACEMENT SCHEDULE

ITEM #	MANUFACTURER/DESCRIPTION	MODEL #	QUANTITY	FURNISHED & INSTALLED BY: B=BURKHART O=OTHERS	ANCHORED TO: FLOOR, WALL, OR CEILING	REMARKS/DETAILS
A	AIR TECHNIQUES DENTAL VACUUM SYSTEM	STS 6	1	FB IB	MECH ROOM	
B	AIR TECHNIQUES DENTAL AIR SYSTEM	AIRSTAR 30	1	FB IB	MECH ROOM	
C	AIR TECHNIQUES REMOTE CONTRAL PANEL	-	1	FB IB	WALL MOUNT	
D	ADEC TREATMENT CONSOLE	5580.42	2	FB IB	SITS ON FLOOR	
E	ADEC ASSISTANT'S DELIVERY UNIT	4635	2	FB IB	ATTACH TO 5580	
F	PLANMECA INC. INTRAORAL X-RAY SYSTEM	INTRA	1	FB IB	CABINET MOUNT	
G	ADEC CENTRAL CONSOLE	5543.1B	1	FB IB	SITS ON FLOOR	
H	ADEC ACCESSORY CONSOLE	5531.58	1	FB IB	SITS ON FLOOR	SINK LEFT
J	ADEC ACCESSORY CONSOLE	5531.58	1	FB IB	SITS ON FLOOR	SINK RIGHT
K	ADEC CASCADE DENTAL CHAIR	1040	2	FB IB	SITS ON FLOOR	
L	ADEC RADIUS DELIVERY SYSTEM	2122	2	FB IB	ATTACH TO CHAIR	
M	ADEC PREFERENCE MOUNT CABINET LIGHT	6300	2	FB IB	ATTACH TO CENTRAL	
N	ADEC ACCESSORY CONSOLE	5531.58	1	FB IB	SITS ON FLOOR	ROUNDED BOTH ENDS NO SINK PACKAGES
O	AIR TECHNIQUES FILM PROCESSOR	PERIPRO	1	FB IB		
P	SOICAN STERILIZER	STATIM 2000	1	FB IB		
Q	ADEC STERILIZER	LIZA	1	FB IB		
R	WHALEDENT RECESSED ULTRASONIC CLEANER	UC300R	1	FB IB		
S	ADEC DISPENSING UNIT	5730.29	2	FB IB		
T	SOICAN DISTILLER SYSTEM	AQUASTATIC	1	FB IB	VERIFY LOCATION	

GENERAL NOTES

Listed requirements show only the services, connections and fixtures required for the dental office equipment shown; and these drawings do not provide for the electrical, mechanical and structural requirements for the building or office as a whole.

- These drawings are going to be used as coordination drawings for the General contractor. The general is obligated to coordinate rough-in dimensions with Burkhardt.
- General contractor to schedule walk-through meeting with all applicable contractors and a Burkhardt representative to review dental equipment details, manufacturer's specification sheets and manufacturer's templates before commencing construction. The personnel actually doing the work must be present at this meeting. This usually takes place after the framing has been completed and before any mechanical has been run. If pouring of a concrete slab is involved, then this meeting must take place prior to that event.

At this meeting we will furnish or make available any templates and plans necessary for the placement of electrical, plumbing and backing for the dental equipment we will be providing. If the doctor is reusing some of his or her existing equipment, then the contractor is responsible for making sure that the appropriate connections are provided. Although we will help as much as possible, it will most likely require a trip by the contractor to the doctor's existing office.

- General contractor to schedule rough-in inspection with all applicable contractors and a Burkhardt representative to inspect all dental plumbing and wiring prior to sheetrocking or pouring of concrete. Our office needs to be notified at least 72 hours in advance for the Burkhardt branch office city area and 72 hours for all areas outside city limits. If the general contractor elects to continue without an inspection by our office, then he assumes all responsibilities for missing or incorrectly installed mechanical services.
- Any Burkhardt or tenant provided items requiring installation by contractor during construction will be delivered to job site. When the contractor or his representative takes possession of these items, he becomes responsible for their safekeeping and condition.
- Burkhardt equipment installation requires approximately 1-2 days for each operator, however time may vary depending on the configuration of equipment. Contractor to schedule with Burkhardt the number of days needed at least thirty days in advance. Schedule required days for after completion of construction and before occupancy of tenant.
- The contractor shall obtain and pay for all permits. The contractor shall coordinate and schedule all required code official inspections.
- Contractor to verify with tenant all items (including their dimensions and their mechanical requirements) that are not supplied by Burkhardt. These items might include but are not limited to: dishwasher, trash compactor, clothes washer and dryer, etc.
- Notify Burkhardt if ceiling height in the operatories is less than 7'-8" (92"). Ceiling height may effect equipment installation.

LEGEND

- (A) All wood backing and bracing to be of fire resistant or substitute for other material if required by local code. Verify structural application with Burkhardt and architect / designer.
- (B) Notify Burkhardt if ceiling height in the operatories is less than 7'-8" (92"). Ceiling height may effect equipment installation.
- Miscellaneous wood backing, see notes for details. Verify size and location with Burkhardt Dental. All dental x-rays require backing.
- See manufacturer's templates provided by Burkhardt.

NOTE:

All framing, bracing, door sizes, floor levels, cabinet heights, rest room and lunch room facilities (if any) and other design details should be modified to comply with latest Americans With Disabilities Act (A.D.A.) guidelines and similar State requirements. Architect or Contractor must submit plans to building and other local officials as necessary for compliance with all Federal, State and Local building codes, including A.D.A. guidelines, before commencing work. Notify Burkhardt of any changes that would modify any dental treatment rooms and/or any dental cabinet layout.

The Contractor should furnish all electrical, plumbing, and structural requirements listed, as this is necessary before the dental equipment can be installed. Burkhardt will furnish the dental equipment. Check all measurements with the actual building dimensions, or Architect's plans. The specifications shown on this plan have not been checked for compliance with Federal, State or Local building codes and regulations.

Listed requirements show only the services, connections and fixtures required for the dental office equipment shown; and these drawings do not provide for the electrical, mechanical and structural requirements for the building or office as a whole.

See Mechanical and Electrical Sheets for further information.

THIS IS A SUGGESTED PLAN WITH SPECIFICATIONS FOR THE DENTAL EQUIPMENT ONLY.

DO NOT SCALE FROM THESE DRAWINGS.
USE CALLED-OUT DIMENSIONS ONLY.

DENTAL EQUIPMENT SPECIFIC
TO THESE SPECIFICATIONS
CAN BE ACQUIRED FROM:

BURKHART
DENTAL SUPPLY COMPANY

2502 South 78th Street
Tacoma, Washington 98409

12000 Industry Way, Unit N-1
Anchorage, Alaska 99515
Attn: Carter Barnes
Phone: 1-866-324-1983
Fax: 1-866-947-2978



INIT.	
REVISIONS	
DATE	

ALASKA NATIVE
TRIBAL HEALTH CONSORTIUM
DIVISION OF ENVIRONMENTAL
HEALTH AND ENGINEERING
1901 SOUTH BRAGAW STREET, SUITE 200
ANCHORAGE, ALASKA 99508-3440
(907) 729-3600



McGRATH SUB-REGIONAL
HEALTH CENTER
DENTAL PLAN

FILE NAME:
PROJECT NO: 0198
PROJ ARCH: BK

DATE: 4/20/2009
SCALE: AS NOTED
DRAWN BY: TWS

STS-6
P/N 54910

SINGLE STS-6
P/N 54920



STS-6
P/N 54910 (4 Gallon CAS)
P/N 54920 (8 Gallon CAS)

When the CAS is stacked onto a single or dual STS the resulting configuration must be bolted or secured to the floor or wall.

SITE REQUIREMENTS		
ELECTRICAL	STS-6 54910 54920	STS-6 54910 54920
Minimum circuit breaker rating	20A	2 each 20A 1 each 40A
Wire size AWG minimum gauge	#12	2 each #12 1 each #8
Receptacle	Nema 6-15R	2 Nema 6-15 R
PLUMBING	STS-3	2 STS-3 in Tandem
Exhaust	2" sch. 40 pipe	2" sch. 40 pipe
Ambient Temperature	40° - 104° F (5° - 40° C)	40° - 104° F (5° - 40° C)
Main Line Diameter I.D. in Inches (min)	1-1/2"	1-1/2"
End Fitting At STS	1-1/2" FNPT	1-1/2" FNPT
Riser Diameter ID	1-1/2"	1-1/2"
Branch Line Dia. I.D. (min)	1"	1"
Drain Line	1-1/2" Schedule 40 Pipe	1-1/2" Schedule 40 Pipe
Wash-Out Line	2" Garden Hose	3/4" Garden Hose


NOTE: Suction piping must slope at least 1/4" for each 10 feet of run towards the pump.
Use PVC Schedule 40 or Copper Type M.

PRODUCT SPECIFICATION/DIMENSIONS		Branch Line Dia. I.D. (min)
ELECTRICAL	STS-3	STS-6
VOLTAGE (MIN/MAX)	200/250	200/250
FULL LOAD AMPS	12	26
STARTING AMPS	30	130
FREQUENCY	60Hz	60Hz
MAXIMUM VACUUM In Hg	15	14
VACUUM LEVEL (PRESET) In Hg	20	10
WEIGHT Lbs.	115	220
STS™ DIMENSIONS in.(WxDxH)	20-1/2 x 16-3/4 x 46-1/2"	20-1/2 x 16-3/4 x 46-1/2"
CAS™ DIMENSIONS in.(WxDxH)	22-5/8 x 18-1/4 x 46"	22-5/8 x 18-3/4 x 46"

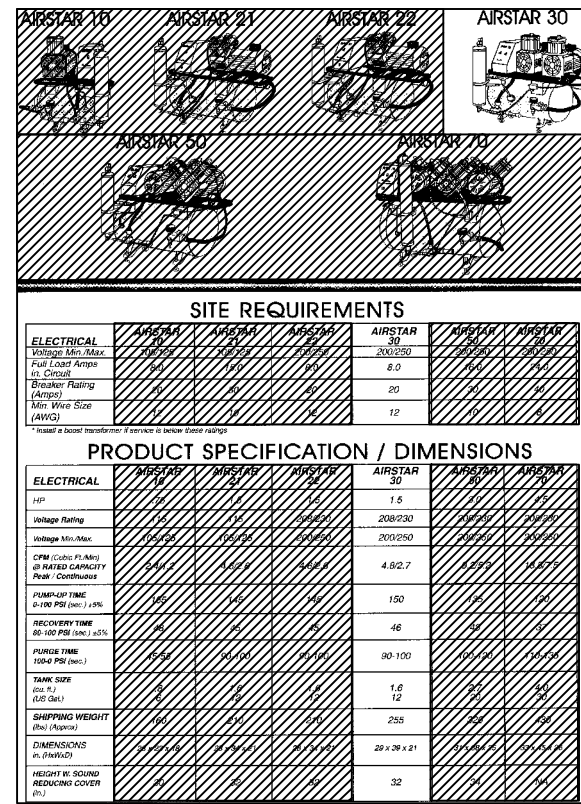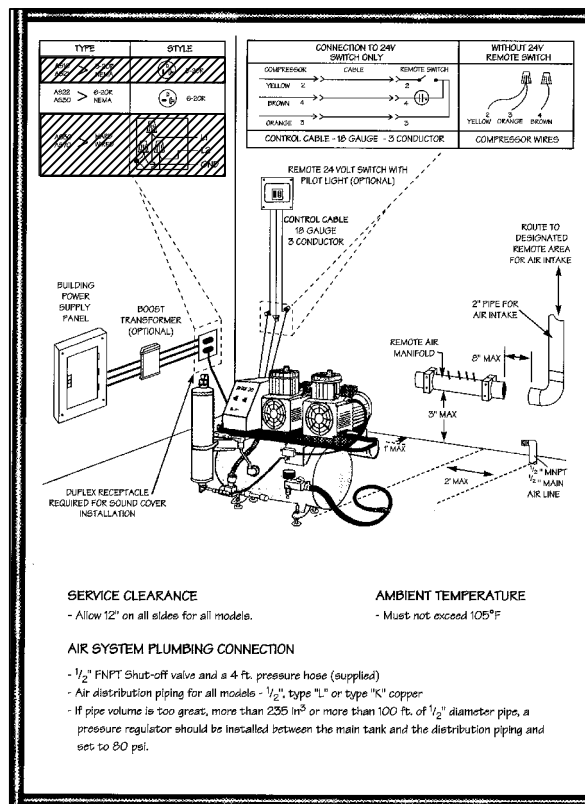

1 AIR TECHNIQUES STS 6 VACUUM
NOT TO SCALE - SEE FULL SIZE TEMPLATES

2 AIR TECHNIQUES AIRSTAR 30 COMPRESSOR
NOT TO SCALE - SEE FULL SIZE TEMPLATES

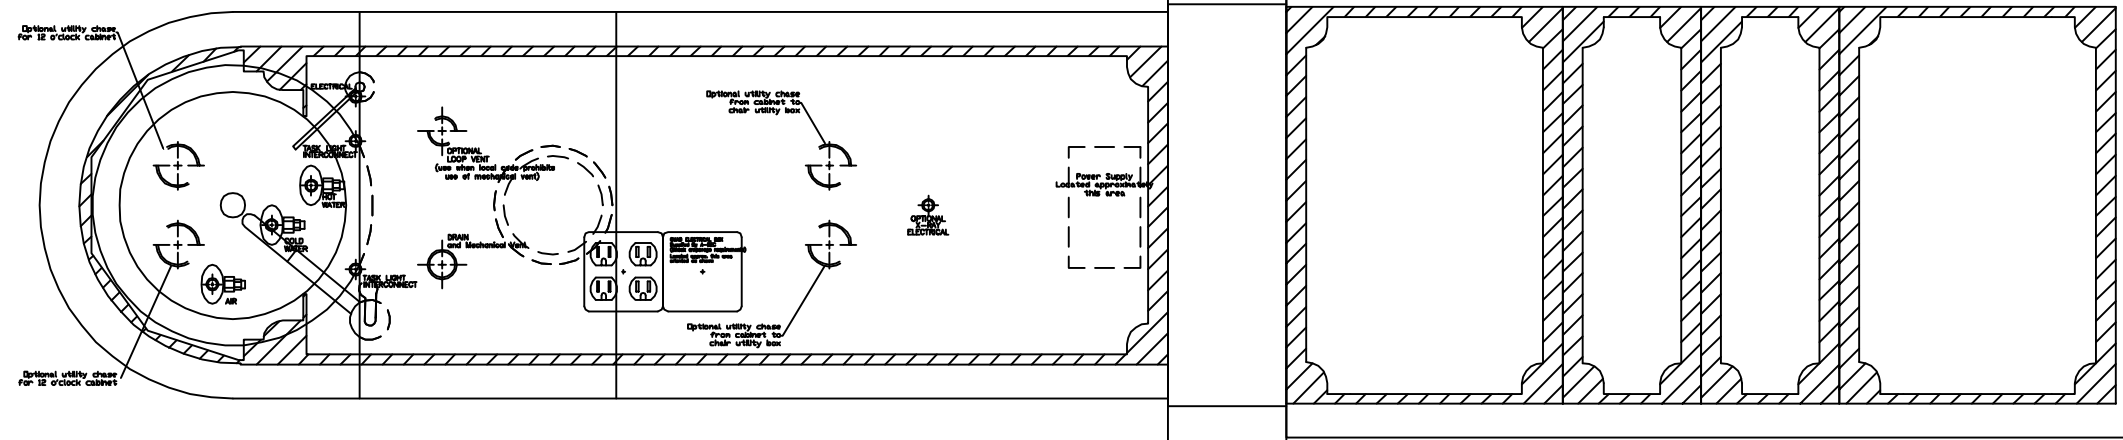

3 ADEC 5543 CENTRAL CONSOLE
NOT TO SCALE - SEE FULL SIZE TEMPLATE

DENTAL EQUIPMENT SPECIFIC
TO THESE SPECIFICATIONS
CAN BE ACQUIRED FROM:



DENTAL SUPPLY COMPANY
2502 South 78th Street
Tacoma, Washington 98409

12000 Industry Way, Unit N-1
Anchorage, Alaska 99515
Attn: Carter Barnes
Phone: 1-866-324-1983
Fax: 1-253-212-4981

DO NOT SCALE FROM THESE DRAWINGS.
USE CALLED-OUT DIMENSIONS ONLY.

NOTE:

All framing, bracing, door sizes, floor levels, cabinet heights, rest room and lunch facilities (if used) and other design details should be modified to comply with latest Americans With Disabilities Act (A.D.A.) guidelines and similar State requirements. Architect or Contractor must submit plans to building and other local officials as necessary for compliance with all Federal, State and Local building codes, including A.D.A. guidelines, before commencing work. Notity Burkhart of any changes that would modify any dental treatment rooms and/or any dental cabinet layout.

The Contractor should furnish all electrical, plumbing, and structural requirements, if this is necessary before the dental equipment can be installed. Burkhart, will furnish the dental equipment. Check all measurements with the building dimensions, or Architect's plans. The specifications shown on this plan have not been checked for compliance with Federal, State or Local building codes and regulations.

Listed requirements show only the services, connections and fixtures required for the dental office equipment shown; and these drawings do not provide for the electrical, mechanical and structural requirements for the building or office as a whole.

See Mechanical and Electrical Sheets for further information.

THIS IS A SUGGESTED PLAN WITH SPECIFICATIONS FOR THE DENTAL EQUIPMENT ONLY.

[illegible]

**ALASKA NATIVE
TRIBAL HEALTH CONSORTIUM**

**DIVISION OF ENVIRONMENTAL
HEALTH AND ENGINEERING**
901 SOUTH BRAGAW STREET, SUITE 200
ANCHORAGE, ALASKA 99508-3440
(907) 729-3600



**McGRATH SUB-REGIONAL
HEALTH CENTER**
DENTAL DETAILS

DATE: 4/20/2009	FILE NAME: _____
SCALE: AS NOTED	PROJECT NO: 0198
DRAWN BY: _____ CFP	PROJ ARCH: BK

SHEET
D-301

3 OF 4D

4 PLANMECA INTRAORAL X-RAY
NOT TO SCALE - SEE FULL SIZE TEMPLATES



THIS IS A SUGGESTED PLAN WITH SPECIFICATIONS FOR THE DENTAL EQUIPMENT ONLY.



SHEET
D-401
4 OF 5D

Figure 23 Templates and Utilities - 5531 Floor-Mounted Utilities



7

- Mounts in countertop providing more open space above the cabinet.
- Two part construction maximizes installation flexibility.
- Above counter engineering grade plastic provides an ergonomic look.
- Below counter stainless steel housings are easy to maintain and durable.
- Separate electronic control unit can be positioned for accessibility or out of harm's way.
- Hinge action lid reduces airborne particles.



Remote Timer
Optional Remote Digital Timer for increased user-friendly operation




UC322 Rack
holds ten UC70 Cassettes
(70 Instruments)

Racks for other popular cassettes available.

Technical Information	
Tank Capacity	3.8 Gallons (14.4 liters)
Fill Capacity	3.0 Gallons (11.0 liters)
Overall Dimensions	17.125 x 12.125 x 2.25 inches
Above Countertop Surface	(43.5 x 30.8 x 5.4 cm)
Below Countertop Surface	14.125 x 10.5 x 14 inches (36.8 x 26.7 x 35.6 cm)
Tank Dimensions	14 x 9 x 6.75 inches (35.6 x 22.9 x 17.1 cm)
Output	300 watts
Operating Frequency	40 kHz

 8



(B) CLEAN SIDE ROOM 118

DENTAL EQUIPMENT SPECIFIC
TO THESE SPECIFICATIONS
CAN BE ACQUIRED FROM:

BURKHART

DENTAL SUPPLY COMPANY
2502 South 78th Street
Tacoma, Washington 98409

12000 Industry Way, Unit N-1
Anchorage, Alaska 99515

Attn: Carter Barnes
Phone: 1-866-324-1983
Fax: 1-253-212-4981

DO NOT SCALE FROM THESE DRAWINGS.
USE CALLED-OUT DIMENSIONS ONLY.

NOTE:

All framing, bracing, door sizes, floor levels, cabinet heights, rest room and lunch room facilities (if any) and other design details shall be modified to comply with latest Americans With Disabilities Act (A.D.A.) guidelines and similar State requirements. Architect or Contractor must submit plans to building and other local officials as necessary for compliance with all Federal, State and Local building codes, including A.D.A. guidelines, before commencing work. Notify Burkhart of any changes that would modify any dental treatment rooms and/or any dental cabinet layout.

The Contractor should furnish all electrical, plumbing, and structural requirements listed, as this is necessary before the dental equipment can be installed. Burkhardt, will furnish the dental equipment. Check all measurements with the actual building dimensions, or Architect's plans. The specifications shown on this plan have not been checked for compliance with Federal, State or Local building codes and regulations.

Listed requirements show only the services, connections and fixtures required for the dental office equipment shown; and these drawings do not provide for the electrical, mechanical and structural requirements for the building or office as a whole.

See Mechanical and Electrical Sheets for further information

THIS IS A SUGGESTED PLAN WITH SPECIFICATIONS FOR THE DENTAL EQUIPMENT ONLY.

[illegible]

ALASKA NATIVE
TRIBAL HEALTH CONSORTIUM
DIVISION OF ENVIRONMENTAL
HEALTH AND ENGINEERING
1901 SOUTH BRAGAW STREET, SUITE 200
ANCHORAGE, ALASKA, 99508-3440
(907) 729-3600



**McGRATH SUB-REGIONAL
HEALTH CENTER**
DENTAL DETAILS

DATE: 4/20/2009	FILE NAME:
SCALE: AS NOTED	PROJECT NO: 0198
DRAWN BY: CFP	PROJ ARCH: BK

SHEET
D-501
5 OF 5D

GENERAL STRUCTURAL NOTES AND SPECIFICATIONS

GENERAL
ALL MATERIALS AND CONSTRUCTION SHALL CONFORM TO REQUIREMENTS OF THE INTERNATIONAL CODE COUNCIL INTERNATIONAL BUILDING CODE (IBC) 2006 EDITION. WHERE EXPLICIT DETAILS ARE NOT SHOWN OR DESCRIBED, THE MINIMUM REQUIREMENTS OF THE ABOVE CODE SHALL APPLY. UNLESS OTHERWISE NOTED, ALL CODES, STANDARDS AND OTHER PUBLICATIONS CITED SHALL REFER TO THE LATEST EDITION.

LOCATION
THESE PLANS ARE FOR THE CONSTRUCTION OF THE MCGRATH SUBREGIONAL HEALTH CENTER IN MCGRATH, ALASKA.

DESIGN LOADS
IN ADDITION TO DEAD LOADS, THE FOLLOWING LIVE LOADS WERE USED FOR DESIGN:

ROOF: 60 P.S.F. (SNOW – 2 MONTH DURATION) PLUS DRIFTING
WIND: 100 MPH, EXPOSURE C
SEISMIC: Ss=0.373, S1=0.13, SITE CLASS D. SEISMIC DESIGN CATAGORY C

LATERAL LOADS ARE RESISTED BY WOOD SHEAR WALLS AND DIAPHRAGMS.

SITE WORK
PREPARATION OF A SAFE AND SUITABLE BUILDING SITE SHALL BE COMPLETED PRIOR TO CONSTRUCTION OF FOUNDATIONS AND SLABS. NO SITE INVESTIGATION OR SOILS BORINGS WERE PERFORMED BY THE ENGINEER. THE FOUNDATION DESIGN IS BASED ON THE "GEOTECHNICAL REPORT FOR THE PROPOSED MCGRATH HEALTH CENTER" PREPARED BY NORTHERN GEOTECHNICAL ENGINEERING FOR CRW ENGINEERING GROUP OF ANCHORAGE, ALASKA. IN THIS REPORT IT IS STATED THAT PERMAFROST IS PRESENT ON THE SITE, AND A DIAGRAM ROUGHLY DELINEATES THE EXTENT OF PERMANENTLY FROZEN SOILS. IN ORDER TO REDUCE THE POSSIBILITY OF DIFFERENTIAL SETTLEMENT, THE BUILDING HAS BEEN LOCATED ON A PORTION OF THE SITE THAT IS ASSUMED TO HAVE NO PERMAFROST PRESENT. A CONVENTIONAL STRIP FOOTING FOUNDATION SYSTEM HAS BEEN USED, WITH 3000 PSF BEARING CAPACITY AS RECOMMENDED IN THE GEOTECH REPORT. CONTACT OWNERS REPRESENTATIVE AND ENGINEER FOR DIRECTION IF PERMAFROST OR FROZEN SOILS ARE ENCOUNTERED WITHIN THE LIMITS OF THE BUILDING EXCAVATION.

FOUNDATIONS
EXCAVATE AND REMOVE ALL ORGANIC MATTER, DEBRIS AND FROST SUSCEPTIBLE SOILS FROM UNDER THE BUILDING FOOTPRINT AND TO 24" BEYOND THE BUILDING FOOTPRINT. PLACE ALL INTERIOR AND EXTERIOR FOOTINGS ON NATURAL UNDISTURBED, NON-FROST SUSCEPTIBLE (N.F.S.) SOIL OR ON COMPACTED NON-FROST SUSCEPTIBLE GRAVEL BACKFILL FREE OF ORGANIC MATTER AND DEBRIS, AND CONFORMING TO THE FOLLOWING GRADATION:

NON-FROST SUSCEPTIBLE GRAVEL BACKFILL	
SIEVE:	PERCENT PASSING:
3"	100
1"	80 – 100
#4	30 – 70
#200	0 – 5

NO MORE THAN 3% OF PARTICLES BY WEIGHT SHALL BE FINER THAN 0.02 MM. BACKFILL SHALL BE PLACED IN LIFTS NOT EXCEEDING 12 INCHES IN LOOSE THICKNESS AND COMPACTED TO 95% OF MAXIMUM DENSITY IN ACCORDANCE WITH ASTM SPECIFICATION D-1557.

FOUNDATION INSULATION
FOUNDATION INSULATION SHALL BE "DOW HIGHLOAD 40" EXTRUDED POLYSTYRENE INSULATION, "BLUEBOARD" OR "INSULFOAM" HIGH DENSITY EXPANDED POLYSTYRENE. WITH 40 PSI MINIMUM COMPRESSIVE STRENGTH.

SLABS ON GRADE
INTERIOR SLABS: PREPARE THE SITE BY REMOVING ALL ORGANIC SOILS AND DEBRIS. AFTER EXCAVATION, COMPACT THE EXISTING SOIL TO 95% OF MAXIMUM DENSITY AND BACKFILL WITH A MINIMUM OF 8" OF NON-FROST SUSCEPTIBLE GRAVEL AND COMPACT AS DESCRIBED ABOVE. PLACE REINFORCING STEEL AT MID-DEPTH OF SLAB AND SUPPORT AT 4"O/C MAXIMUM WITH WELL CURED CONCRETE BLOCKS OR APPROVED METAL CHAIRS. DO NOT SUPPORT ON STONES. PROVIDE PREFORMED CONTROL OR CONSTRUCTION JOINTS (C.J.) AT LOCATIONS SHOWN ON THE PLANS AND AT 20' O/C MAXIMUM.

EXTERIOR SLABS: PROVIDE A MINIMUM OF 72 INCHES OF NON-FROST SUSCEPTIBLE GRAVEL BELOW SLAB CONFORMING TO THE GRADATION AND COMPACTION REQUIREMENTS DESCRIBED ABOVE FOR FOUNDATIONS.

DRAINAGE: SLOPE ALL EXTERIOR SLABS ADJACENT TO BUILDINGS TO DRAIN AWAY FROM BUILDING PERIMETER AT 1/8" PER FOOT MINIMUM SLOPE.

CONCRETE
MIXING, SELECTION OF MATERIALS, AND PLACING OF ALL CONCRETE SHALL CONFORM TO THE REQUIREMENTS OF THE IBC, CHAPTER 19. AN AIR ENTRAINING AGENT SHALL BE USED IN ALL CONCRETE MIXES FOR CONCRETE WORK WHICH IS TO BE EXPOSED TO EARTH OR WEATHER.
AIR ENTRAINMENT SHALL BE 5% +/- 1% BY VOLUME. ALL CONCRETE SHALL HAVE A MINIMUM 28 DAY COMPRESSIVE STRENGTH (F'C) = 3000 P.S.I. EXCEPT CONCRETE GROUT FOR MASONRY WALLS WHICH SHALL HAVE A MINIMUM 28 DAY COMPRESSIVE STRENGTH (F'C)= 2000 P.S.I.. CONCRETE FOR INTERIOR AND EXTERIOR SLABS SHALL CONTAIN 1.6 POUNDS OF "FORTA FIBRE D15" COLLATED FIBRILLATED POLYPROPYLENE FIBER PER CUBIC YARD OF CONCRETE. THE FIBER SHALL BE THOROUGHLY MIXED INTO THE CONCRETE IN TRANSIT TO THE SITE, IN ACCORDANCE WITH THE FIBER MANUFACTURER'S RECOMMENDATIONS.

REINFORCING STEEL
UNLESS NOTED OTHERWISE, ALL REINFORCING STEEL SHALL BE DEFORMED BARS CONFORMING TO IBC CHAPTER 19. REINFORCING BARS SHALL BE GRADE 60. REINFORCING STEEL SHALL BE SECURELY TIED IN PLACE WITH #16 DOUBLE ANNEALED IRON WIRE. REINFORCING IN FOOTINGS SHALL BE SUPPORTED ON WELL CURED CONCRETE BLOCKING OR APPROVED METAL CHAIRS. REINFORCING BARS SHALL BE SPLICED BY A LAP OF AT LEAST 30 BAR DIAMETERS. A MINIMUM LAP FOR ALL BARS SHALL BE 24". CONCRETE COVER OVER REINFORCING SHALL BE 3" FOR CONCRETE CAST AGAINST EARTH. CONCRETE COVER FOR FORMED CONCRETE THAT WILL BE EXPOSED TO WEATHER OR EARTH SHALL BE 2" MINIMUM FOR #6 THROUGH #18 BARS AND 1 1/2" MINIMUM FOR #5 BARS AND SMALLER, INCLUDING WELDED WIRE FABRIC (WWF). OTHER REINFORCEMENT SHALL HAVE A MINIMUM COVERAGE OF NOT LESS THAN 3/4".

ANCHOR BOLTS AND CONCRETE EXPANSION ANCHORS
ANCHOR BOLTS, THREADED RODS AND CONCRETE EXPANSION ANCHORS SHALL CONFORM TO ASTM A 307. CONCRETE EXPANSION ANCHORS (KB) SHALL BE "HILTI KWIK BOLT II" CONCRETE EXPANSION ANCHORS OR STRUCTURAL EQUIVALENT, INSTALLED IN ACCORDANCE WITH MANUFACTURER'S RECOMMENDATIONS. ANCHOR BOLTS SHALL BE PROVIDED WITH HEX HEAD NUTS AND 2"x2"x1/4" STEEL PLATE WASHERS. WHERE BOLTS OR RODS ARE USED WITH CEDAR SILL PLATES, BOLTS, NUTS AND WASHERS SHALL BE GALVANIZED. ALL FASTENERS IN CONTACT WITH PRESSURE TREATED WOOD SHALL BE HOT DIPPED GALVANIZED OR SHALL BE STAINLESS STEEL. PROVIDE 5/8" X 10" ANCHOR BOLTS AT 48" O/C SPACING UNLESS NOTED OTHERWISE AND WITHIN 6" OF WALL OPENINGS AND BUILDING CORNERS.

POWER FASTENERS
POWER FASTENERS FOR CONNECTION TO CONCRETE, GROUTED MASONRY, OR STEEL SHALL BE POWDER ACTUATED HILTI X-AL-H HEAVY DUTY DOME HEAD NAILS WITH 0.177 INCH SHANK DIAMETER. MINIMUM FASTENER EMBEDMENT SHALL BE 1 3/8". NAIL LENGTH SHALL BE AS REQUIRED TO ACHIEVE SPECIFIED MINIMUM PENETRATION INTO SUBSTRATE.

ADHESIVE ANCHORING SYSTEM
THREADED ROD ANCHORS AND REINFORCING BAR DOWELS SHALL BE SET IN SIMPSON ACRYLIC TIE ADHESIVE OR STRUCTURAL EQUIVALENT. ADHESIVE ANCHORS SHALL BE INSTALLED IN ACCORDANCE WITH THE ADHESIVE MANUFACTURER'S RECOMMENDED INSTALLATION PROCEDURES. MINIMUM EMBEDMENT IN CONCRETE FOR ALL ANCHORS SHALL BE 31/2" UNLESS NOTED OTHERWISE.

SAWN LUMBER AND TIMBER
LUMBER SHALL CONFORM TO THE CLASSIFICATION, DEFINITION, AND GRADING REQUIREMENTS OF IBC CHAPTER 23 WITH ALLOWABLE UNIT STRESSES AS GIVEN IN THE AMERICAN FOREST & PAPER ASSOCIATION "NATIONAL DESIGN SPECIFICATION 2001 SUPPLEMENT", TABLE 4A. LUMBER SHALL BE GRADE MARKED BY THE WEST COAST LUMBER INSPECTION BUREAU /WESTERN WOOD PRODUCTS ASSOCIATION.

ITEM	SPECIES
4 X AND LARGER	DOUGLAS FIR #2
BEARING WALL PLATES	HEM FIR #2
BEARING WALL STUDS	HEM FIR #2
ALL OTHER LUMBER	HEM FIR #2

ALL LUMBER SHALL BE FASTENED IN CONFORMANCE WITH TABLE 2304.9.1 OF THE IBC, UNLESS NOTED OTHERWISE. FASTENERS SHALL BE GALVANIZED UNLESS OTHERWISE NOTED. FASTEN ALL JOIST BLOCKING TO PLATES WITH (4) 16D MINIMUM AND FASTEN ALL WALL PLATES TO WOOD FLOORS WITH 16D AT 6" ON CENTER TYPICAL. DOUBLE TOP PLATES SHALL OVERLAP 10" – 0" MINIMUM AND SHALL BE SPLICED TOGETHER WITH 16D NAILS AT 6" ON CENTER MINIMUM UNLESS NOTED OTHERWISE.

PROVIDE JOIST/BEAM HANGERS WITH LOAD CAPACITY EQUAL TO SUPPORTED MEMBER SHEAR LOAD CAPACITY FOR ALL MEMBERS NOT OTHERWISE PROVIDED WITH DIRECT BEARING SUPPORT. PROVIDE A MINIMUM OF (2) KING STUDS AND (2) CRIPPLE STUDS FOR ALL BEARING WALL HEADERS. PROVIDE A MINIMUM OF (1)KING STUD AND (1) CRIPPLE STUD AT NON-BEARING WALL HEADERS. PROVIDE SOLID BLOCKING SUPPORT FOR BEAMS AND HEADERS CONTINUOUS DOWN TO FOUNDATIONS. MINIMUM HEADER OVER OPENINGS IN BEARING WALLS SHALL BE 4X12 DF#1 UNLESS NOTED OTHERWISE.

BOLT HEADS AND NUTS BEARING AGAINST WOOD TO BE PROVIDED WITH FLAT WASHERS. SOLID BLOCKING OF NOT LESS THAN 2" NOMINAL THICKNESS SHALL BE PROVIDED AT ENDS AND AT ALL SUPPORTS OF JOISTS AND RAFTERS, UNLESS SHOWN OTHERWISE. BEAM AND JOIST HANGERS SHALL HAVE A CAPACITY EQUAL TO THE SHEAR STRENGTH OF THE BEAM OR JOIST WHICH IT IS SUPPORTING, UNLESS NOTED OTHERWISE. ALL METAL FRAMING ANCHORS AND HANGERS SHOWN ON DRAWINGS SHALL BE "STRONG TIE CONNECTORS" AS MANUFACTURED BY SIMPSON COMPANY OR APPROVED EQUAL. ALL SIMPSON CONNECTORS IN CONTACT WITH PRESSURE TREATED WOOD SHALL BE TYPE 304 OR TPYE 316 STAINLESS STEEL.

PRESSURE TREATED WOOD
ALL WOOD INDICATED AS PRESSURE TREATED, (PT) SHALL BE PRESSURE TREATED (PT) IN ACCORDANCE THE AMERICAN WOOD PRESERVER'S ASSOCIATION STANDARD U1-02. THE PRESERVATIVE SHALL BE ALKALINE COPPER QUAT (ACQ). ALL WOOD SHLL BE TREATED TO A RETENTION OF 0.60 PCF AS REQUIRED FOR "GROUND CONTACT" ALL PRESSURE TREATED WOOD SHALL BE APPROPRIATELY MARKED ATTESTING TO COMPLIANCE WITH THESE REQUIREMENTS. LUMBER SHALL BE DRIED AFTER TREATMENT TO A MOISTURE CONTENT OF 19% OR LESS. ALL BOLTS, NAILS AND SIMPSON CONNECTORS IN CONTACT WITH PRESSURE TREATED WOOD SHALL BE TYPE 304 OR TYPE 316 STAINLESS STEEL.

GLUED LAMINATED STRUCTURAL UNITS
MATERIALS, MANUFACTURE, AND QUALITY CONTROL OF GLUED LAMINATED STRUCTURAL UNITS (GLULAM) SHALL CONFORM TO IBC CHAPTER 23 WITH ALLOWABLE STRESSES AS DEFINED IN AMERICAN FOREST & PAPER ASSOCIATION "NATIONAL DESIGN SPECIFICATION 2001 SUPPLEMENT", TABLE 5A, AND SHALL BE DOUGLAS FIR, COMBINATION 24F-V8, DF/DF. GLUE LAMINATED STRUCTURAL UNITS SHALL BE GRADE MARKED BY THE AMERICAN INSTITUTE OF TIMBER CONSTRUCTION, AITC.

WOOD TRUSSES
WOOD TRUSSES SHALL BE DESIGNED FABRICATED AND INSTALLED IN ACCORDANCE WITH THE TRUSS PLATE INSTITUTE'S DESIGN SPECIFICATION FOR METAL PLATE CONNECTED WOOD TRUSSES (TPI-78). TRUSS PROFILES SHALL BE AS SHOWN ON THE DRAWINGS. INSTALL AND BRACE TRUSSES IN ACCORDANCE WITH MANUFACTURERS RECOMMENDATIONS. TRUSS SHOP DRAWINGS SHALL BE PROVIDED BY THE TRUSS SUPPLIER AND SHALL BEAR THE SEAL OF A PROFESSIONAL ENGINEER LICENSED TO PRACTICE CIVIL ENGINEERING IN THE STATE OF ALASKA.

PLYWOOD
ALL PLYWOOD SHALL CONFORM TO UBC STANDARD 23-2 AND SHALL BE AMERICAN PLYWOOD ASSOCIATION GRADE TRADE MARKED. PLYWOOD SHALL BE GROUP I OR GROUP II DOUGLAS FIR. ALL PANELS SHALL BE NOMINAL 4' X 8' PANELS. UTILIZE FULL SHEETS WHEREVER POSSIBLE. LAY FACE GRAIN OF ROOF AND FLOOR SHEATHING PANELS PERPENDICULAR TO JOISTS AND WITH PANEL CONTINUOUS OVER THREE OR MORE SPANS. STAGGER END JOINTS OF SUCCESSIVE COURSES 4' – 0". WALL SHEATHING SHALL BE INSTALLED WITH THE FACE GRAIN PARALLEL TO STUDS, (LONG DIMENSION VERTICAL).

ROOF SHEATHING: SHALL BE 5/8" THICK GRADE APA 40/20 SPAN RATED PLYWOOD WITH EXTERIOR GLUE. ROOF SHEATHING SHALL BE FASTENED TO END SUPPORTS WITH 10D GALVANIZED NAILS AT 6" O/C. AT BLOCKED DIAPHRAGM LOCATIONS, FASTEN PLYWOOD TO FRAMING AT ALL PANEL EDGES WITH 10D GALVANIZED NAILS @ 4" O/C. AT ALL LOCATIONS, FASTEN PLYWOOD TO INTERMEDIATE SUPPORTS WITH 10D GALVANIZED NAILS AT 12 INCHES ON CENTER. PROVIDE 2X4 BLOCKING ALONG ALL PANEL EDGES WHERE SHOWN ON THE DRAWINGS. FASTEN ROOF SHEATHING TO BLOCKING OVER EXTERIOR WALLS WITH 10D GALVANIZED NAILS AT 4" O/C.

ORIENTED STRAND BOARD (OSB)
ALL ORIENTED STRAND BOARD SHALL CONFORM TO UBC STANDARD 23-3 AND SHALL BE AMERICAN PLYWOOD ASSOCIATION GRADE TRADE MARKED. ALL PANELS SHALL BE NOMINAL 4' X 8' PANELS. UTILIZE FULL SHEETS WHEREVER POSSIBLE. LAY STRENGTH AXIS OF ROOF AND FLOOR SHEATHING PANELS PERPENDICULAR TO SUPPORTS AND WITH PANEL CONTINUOUS OVER THREE OR MORE SPANS. STAGGER END JOINTS OF SUCCESSIVE COURSES 4'.

OSB WALL SHEATHING: SHALL BE 7/16" PANELS WITH EXTERIOR GLUE. UNLESS NOTED OTHERWISE ON THE DRAWINGS, WALL SHEATHING SHALL BE FASTENED TO FRAMING WITH 8D GALVANIZED NAILS 3" O/C ALONG PANEL EDGES AND 12" O/C ALONG INTERMEDIATE SUPPORTS. WALL SHEATHING SHALL BE BLOCKED AT ALL EDGES WITH NOMINAL 2" SOLID BLOCKING.

MANUFACTURED WOOD JOISTS
FABRICATED WOOD JOISTS SHALL BE OF THE SIZE INDICATED ON THE DRAWINGS AND AS MANUFACTURED BY BOISE CASCADE OR APPROVED EQUAL. FOLLOW MANUFACTURER'S RECOMMENDATIONS FOR INSTALLATION, HANDLING AND ERECTION OF FLOOR JOISTS. PROVIDE WEB STIFFENERS PER MANUFACTURER'S RECOMMENDATIONS AND ON BOTH SIDES OF WEBS WHERE JOISTS ARE SUPPORTED BY JOIST HANGERS. PROVIDE BLOCKING PANELS AT SUPPORTS AND ENDS OF JOISTS. PROVIDE FULL THICKNESS BACKER PLATE BETWEEN DOUBLE JOISTS WHERE JOIST IS FRAMED PERPENDICULAR INTO A DOUBLE JOIST. PROVIDE SOLID RIM JOISTS AROUND FULL PERIMETER OF FLOOR SYSTEM. UNLESS NOTED OTHERWISE ON THE DRAWINGS, PROVIDE LAMINATED VENEER LUMBER HEADERS, WITH DEPTH EQUAL TO JOIST DEPTH, AT ALL OPENINGS IN FLOOR AND ROOF SYSTEMS, UNLESS NOTED OTHERWISE. PROVIDE FACE MOUNT JOIST HANGERS WITH CAPACITY EQUAL TO THE FULL SHEAR CAPACITY OF THE JOIST AT ALL JOISTS WHERE JOIST IS NOT SUPPORTED BY DIRECT BEARING.

STRUCTURAL STEEL AND CONNECTORS
STRUCTURAL STEEL SHALL CONFORM TO UBC CHAPTER22. FOR ASTM SPECIFICATION A-36, FY = 36 K.S.I. EXCEPT WHERE NOTED OTHERWISE. STEEL TUBING (TS) SHALL CONFORM TO ASTM A500, GRADE B, FY = 46 K.S.I. DESIGN, FABRICATION AND ERECTION SHALL BE IN ACCORDANCE WITH THE IBC CHAPTER 22, DIVISION IX. ALLOWABLE STRESS DESIGN. MACHINE BOLTS (MB) SHALL CONFORM TO ASTM 307 AND SHALL BE PROVIDED WITH STANDARD HEX HEAD NUTS CONFORMING TO ASTM A563, GRADE A AND HARDENED STEEL CIRCULAR WASHERS CONFORMING TO ASTM F436. ALL WELDING SHALL CONFORM TO AMERICAN WELDING SOCIETY D1.1. WELD ALL FAYING SURFACES WITH CONTINUOUS 3/16" FILLET WELD (MINIMUM) UNLESS OTHERWISE NOTED. ELECTRODES SHALL BE A.W.S. E-70. ANCHOR ALL COLUMNS WITH MINIMUM (4) 3/4" X 10" ANCHOR BOLTS UNLESS SHOWN OTHERWISE. PROVIDE ADEQUATE LATERAL BRACING FOR STRUCTURE DURING CONSTRUCTION.

SPECIAL INSPECTION
OWNER SHALL PROVIDE A SPECIAL INSPECTION PROGRAM IN ACCORDANCE WITH IBC CHAPTER 17. SPECIAL INSPECTIONS SHALL INCLUDE:

STEEL
1. PERIODIC INSPECTION OF FILLET WELDS SINGLE PASS FILLET WELDS NOT EXCEEDING 3/16 INCH IN SIZE.
2. PERIODIC INSPECTION OF FLOOR AND ROOF DECK WELDING.
3. VISUAL INSPECTION OF ALL WELDS PRIOR TO COMPLETION.

CONCRETE
1. INSPECTION OF REINFORCING STEEL AND PLACEMENT, PRIOR TO POURING CONCRETE.
2. SUBMITTAL OF CONCRETE MIX DESIGN TO VERIFY CONFORMANCE TO SPECIFICATIONS.
3. TESTING OF CONCRETE MATERIALS FOR CONCRETE USED IN THE CONSTRUCTION OF THE UNDERGROUND WATER STORAGE TANK WALLS AND LID. PROVIDE CONCRETE TEMPERATURE, SLUMP, ENTRAINED AIR CONTENT AND COMPRESSIVE STRENGTH TESTS FOR EACH TRUCKLOAD BATCH OF CONCRETE.

DATE	REVISIONS						INIT.





ALASKA NATIVE TRIBAL HEALTH CONSORTIUM
DIVISION OF ENVIRONMENTAL HEALTH AND ENGINEERING
1901 SOUTH BRAGAW STREET, SUITE 200
ANCHORAGE, ALASKA, 99508-3440
(907) 729-3600



McGRATH SUB--REGIONAL HEALTH CENTER
GENERAL STRUCTURAL NOTES

DATE: 4/20/2009	FILE NAME: _____
SCALE: AS NOTED	PROJECT NO: 0198
DRAWN BY: MJD	PROJ ARCH: BK

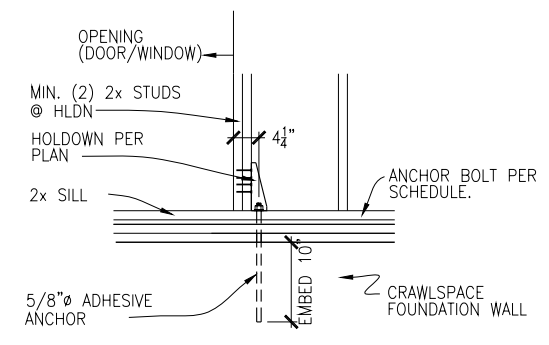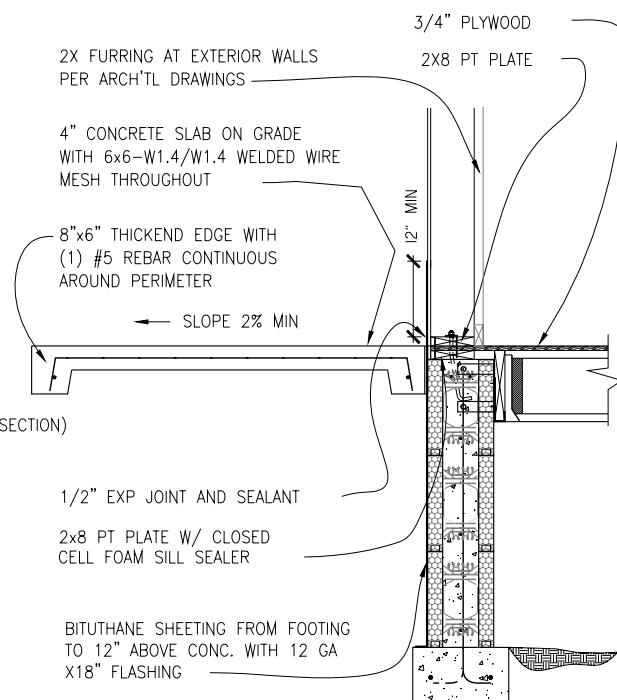

**TYPICAL FOOTING DETAIL
AT EXTERIOR SLAB**

0 6" 1' 2' 4'


GRAPHIC SCALE

D
S2.1

TYPICAL HOLDOWN DETAIL

0 6" 1' 2' 4'

GRAPHIC SCALE

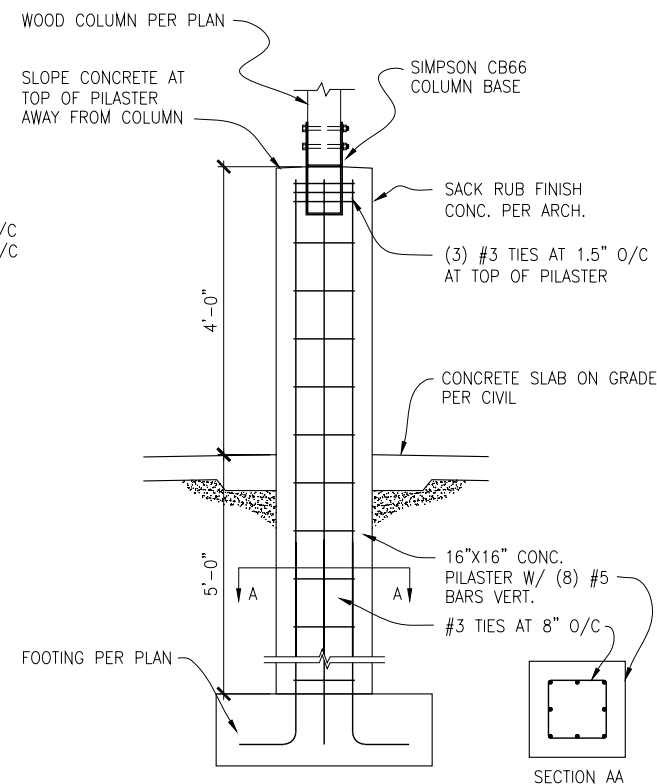


F
S2.1

TYPICAL PILASTER



0 6" 1' 2' 4'

GRAPHIC SCALE

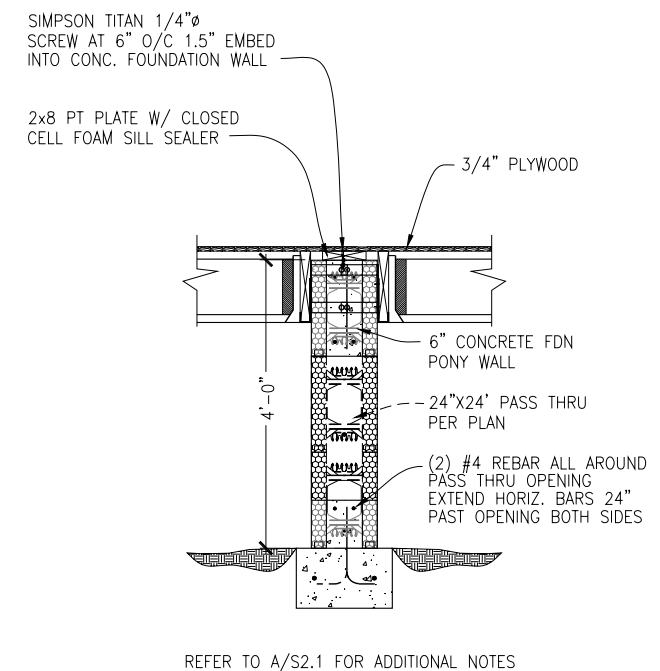

H
S2.1

FOUNDATION WALL NEAR
ENTRY BUMPOUT

0 6" 1' 2' 4'

GRAPHIC SCALE

[illegible]

ALASKA NATIVE
TRIBAL HEALTH CONSORTIUM

DIVISION OF ENVIRONMENTAL
HEALTH AND ENGINEERING
1901 SOUTH BRAGAW STREET, SUITE 200
ANCHORAGE, ALASKA, 99508-3440
(907) 729-3600





McGRATH SUB-REGIONAL
HEALTH CENTER
FOUNDATION DETAILS

DATE: 4/20/2009	FILE NAME:
SSCALE: AS NOTED	PROJECT NO: 0198
DRAWN BY: MJD	PROJ ARCH. BK

SHEET
S-2.1

OF 8

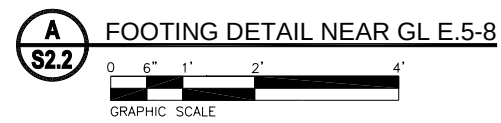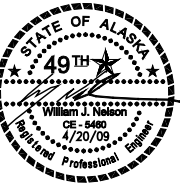[illegible]











**ALASKA NATIVE
TRIBAL HEALTH CONSORTIUM**

**DIVISION OF ENVIRONMENTAL
HEALTH AND ENGINEERING**
1901 SOUTH BRAGAW STREET, SUITE 200
ANCHORAGE, ALASKA, 99508-3440
(907) 729-3600



McGRATH SUB-REGIONAL
HEALTH CENTER
FOUNDATION DETAILS

DATE: 4/20/2009	FILE NAME:
SCALE: AS NOTED	PROJECT NO: 0198
DRAWN BY: MJD	PROJ ARCH. BK

          

STATE OF ALASKA
49TH
William J. Nelson
CE-5480
4/20/09
Registered Professional Engineer

ALASKA NATIVE
TRIBAL HEALTH CONSORTIUM

DIVISION OF ENVIRONMENTAL
HEALTH AND ENGINEERING

1901 SOUTH BRAGAW STREET, SUITE 200
ANCHORAGE, ALASKA, 99508-3440
(907) 729-3600





HEALTH CENTER

ROOF DETAILS

SCALE: AS NOTED	PROJECT NO: 0198
DRAWN BY: MJD	PROJ ARCH: BK

SHEET
-3.1
OF 8

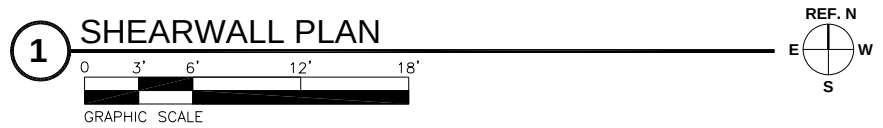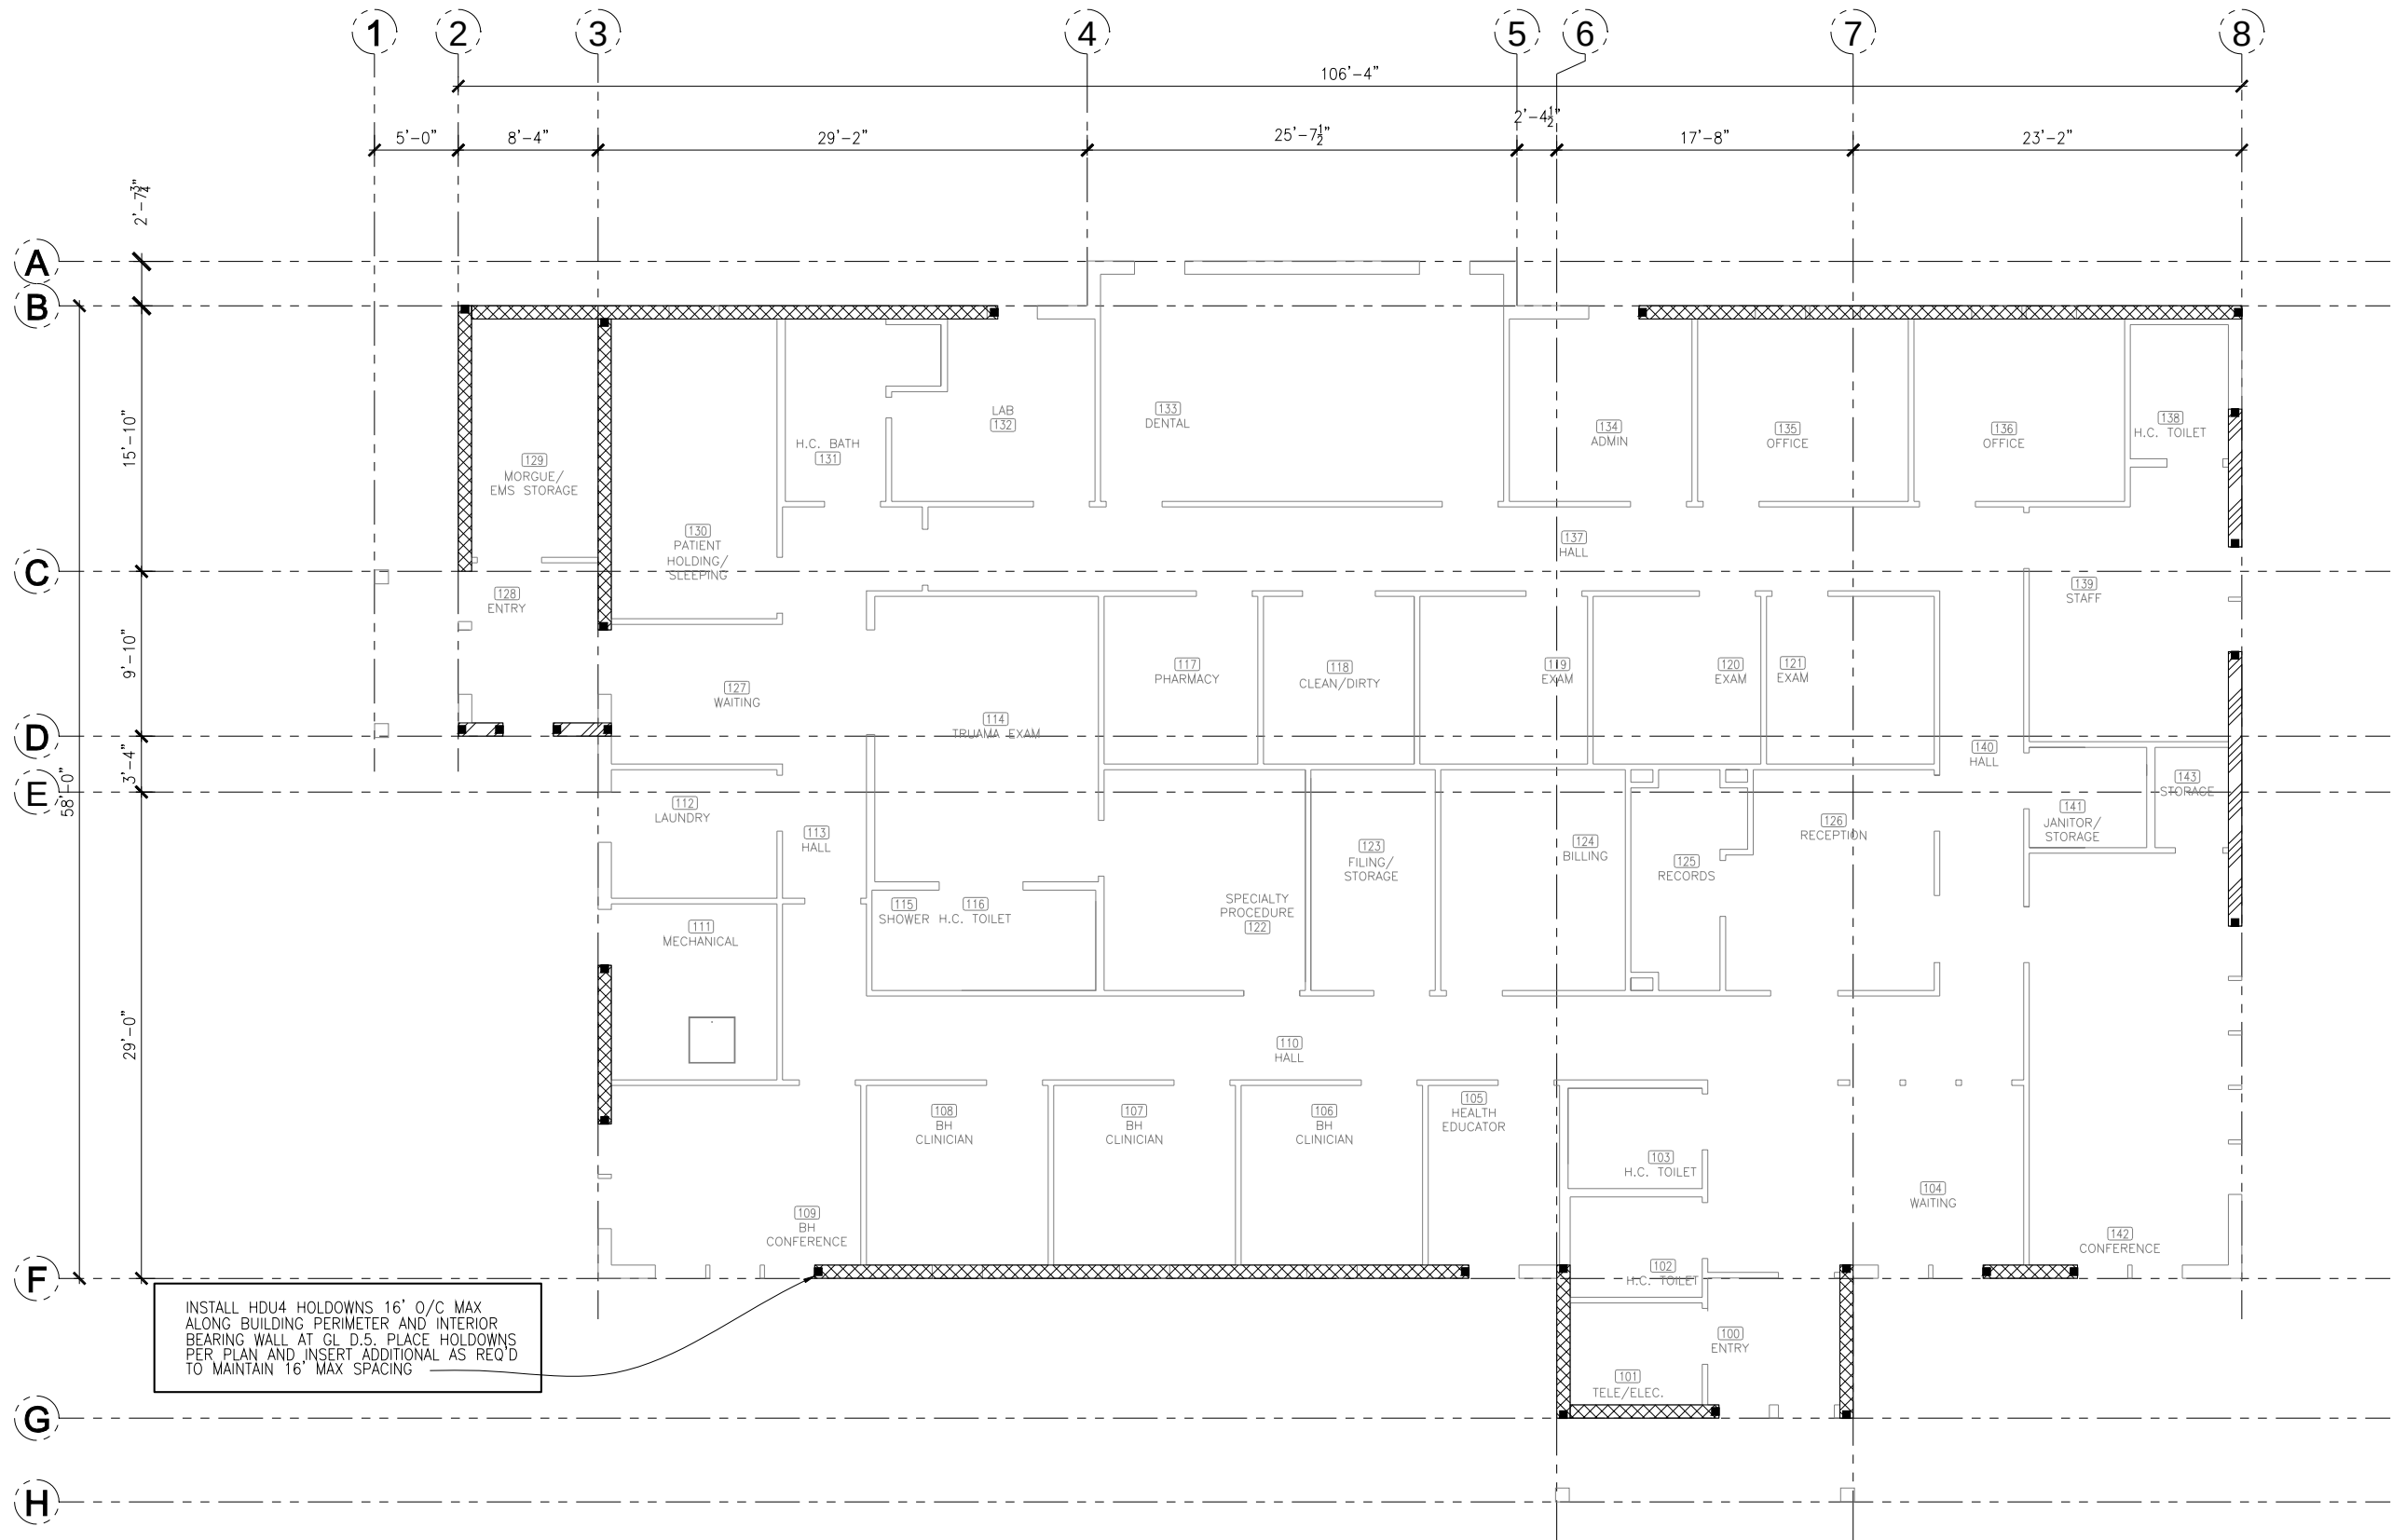

SHEARWALL SCHEDULE			
MARK	SHEATHING	FASTENING	
	7/16" OSB ONE SIDE	8D @ 6" O/C EDGES	8D @ 12" O/C FIELD
	7/16" OSB ONE SIDE	8D @ 4" O/C EDGES	8D @ 12" O/C FIELD
5/8"x12" BENT ANCHOR BOTS AT 32" O/C UNO			
■ HDU 4 HOLD DOWN PER DETAIL D/S2.1			

INIT.

REVISIONS

DATE

ALASKA NATIVE TRIBAL HEALTH CONSORTIUM

DIVISION OF ENVIRONMENTAL HEALTH AND ENGINEERING

1901 SOUTH BRAGAW STREET, SUITE 200
ANCHORAGE, ALASKA, 99508-3440
(907) 729-3600

McGRATH SUB-REGIONAL HEALTH CENTER

SHEARWALL FRAMING PLAN

FILE NAME: _____

PROJECT NO: 0198

DATE: 4/20/2009

SCALE: AS NOTED

PROJ ARCH: BK

MUD

DRAWN BY: _____

SHEET S-4.0

7 OF 8

ABBREVIATIONS

AD	ACCESS DOOR
AFF	ABOVE FINISHED FLOOR
AMPS	AMPERES
APD	AIR PRESSURE DROP
ARCH	ARCHITECTURAL
AS	AIR SEPARATOR
ASSY	ASSEMBLY
AWT	AVERAGE WATER TEMPERATURE
B	BOILER
BB	BASEBOARD
BDD	BACKDRAFT DAMPER
BTUH	BRITISH THERMAL UNIT / HOUR
C/A	COMBUSTION AIR
CFM	CUBIC FEET PER MINUTE
CLG	CEILING
CONT	CONTINUED
CO	CLEANOUT
CONN	CONNECTION
CP	CIRCULATION PUMP
CUH	CABINET UNIT HEATER
CW	COLD WATER
Ø	DIAMETER
DA	DENTAL AIR
DC	DUCT COIL
DEG	DEGREE
DN	DOWN
DVAC	DENTAL VACUUM
DWG	DRAWING
E/A	EXHAUST AIR
EAT	ENTERING AIR TEMPERATURE
EF	EXHAUST FAN
ET	EXPANSION TANK
EXH	EXHAUST
EWT	ENTERING WATER TEMPERATURE
ESP	EXTERNAL STATIC PRESSURE
EGT	ENTERING GLYCOL TEMPERATURE
FT	FEET
FPM	FEET PER MINUTE
FPF	FINS PER FOOT
F	FAHRENHEIT
FCO	FLOOR CLEAN OUT
FOT	FUEL OIL TANK
FW	FIRE WATER
FR	FRACTIONAL
GPH	GALLONS PER HOUR
GPM	GALLONS PER MINUTE
GR	GREASE TRAP
GT	GLYCOL TANK
HB	HOSE BIBB
HC	HEATING COIL
HD	HEAD
HGR	HEATING GLYCOL RETURN
HGS	HEATING GLYCOL SUPPLY
HRV	HEAT RECOVERY VENTILATOR
HW	HOT WATER
HWG	HOT WATER GENERATOR
HP	HORSEPOWER
ID	INSIDE DIAMETER
IN	INCHES
LAT	LEAVING AIR TEMPERATURE
LF	LINEAL FEET
LGT	LEAVING GLYCOL TEMPERATURE
LWT	LEAVING WATER TEMPERATURE
MAX	MAXIMUM
MBH	THOUSAND BTU PER HOUR
MFGR	MANUFACTURER
MIN	MINIMUM
MTD	MOUNTED
NC	NOISE CRITERIA
N.C.	NORMALLY CLOSED
N.O.	NORMALLY OPEN
NTS	NOT TO SCALE
OC	ON CENTER
O/A	OUTSIDE AIR
OD	OUTSIDE DIAMETER
PD	PRESSURE DROP
PG	PROPYLENE GLYCOL
PH	PHASE
PRV	PRESSURE REDUCING VALVE
PSI	POUNDS PER INCH
R/A	RETURN AIR
RGR	RADIANT HEATING GLYCOL RETURN
RCS	RADIANT HEATING GLYCOL SUPPLY
RPM	REVOLUTIONS PER MINUTE
S/A	SUPPLY AIR
SP	STATIC PRESSURE
TEMP	TEMPERATURE
TSP	TOTAL STATIC PRESSURE
TSTAT	THERMOSTAT
TYP	TYPICAL
UH	UNIT HEATER
V	VENT
VTR	VENT THROUGH ROOF
WC	WATER COLUMN
WG	WATER GAGE
WCO	WALL CLEAN OUT
W	WASTE
WTD	WATER TEMPERATURE DROP

MECHANICAL LEGEND

	WASTE
	VENT PIPING
	COLD WATER
	HOT WATER
	SEE ABBREVIATIONS FOR MEDIA
	PIPE UP
	PIPE DOWN
	TEE UP
	TEE DOWN
	UNION
	DIRECTION OF FLOW
	ISOLATION VALVE
	2-WAY CONTROL VALVE
	CHECK VALVE
	BALANCE VALVE
	PRESSURE/TEMPERATURE RELIEF VALVE
	THERMOMETER
	FLOOR CLEANOUT
	FLOOR DRAIN
	FLOOR SINK
	SUPPLY AIR UP & DOWN (SQUARE)
	EXHAUST AIR UP & DOWN (SQUARE)
	ROUND DUCT UP & DOWN
	THERMOSTAT OR SENSOR
	REVERSE ACTING THERMOSTAT
	HUMIDISTAT SENSOR
	SHEET NOTES
	CFM
	DIFFUSER OR GRILLE TYPE
	DETAIL NUMBER
	SHEET LOCATED ON
	BASEBOARD DESIGNATION
	ACTIVE LENGTH
	GPM

PLUMBING FIXTURE SCHEDULE

SYMBOL	FIXTURE	MINIMUM CONNECTION SIZE					MANUFACTURER	MODEL	COLOR	TRIM / REMARKS
		CW	HW	WASTE	VENT	TRAP				
WC-1	WATER CLOSET – FLOOR MOUNT – ADA	1/2"	----	3"	2"	----	KOHLER	HIGHLINE K-3493	WHITE	ELONGATED BOWL, COVER, SPLIT RIM SEAT
LV-1	LAVATORY – WALL MOUNT – ADA	1/2"	1/2"	1-1/2"	1-1/2"	1-1/4"	KOHLER	KINGSTON K-2005	WHITE	DELTA FAUCET 516 WFHDF WITH METAL GRID STRAINER, CONCEALED ARM
										SUPPORTS, WALL CARRIER FOR ADA HEIGHT, INSULATE TRAP AND HW SUPPLY
SK-1	SINK – EXAM	1/2"	1/2"	2"	1-1/2"	2"	PER FF&E PACKAGE		----	PER FF&E PACKAGE
SK-2	SINK – SPECIALTY PROCEDURE	1/2"	1/2"	2"	1-1/2"	2"	PER FF&E PACKAGE		----	PER FF&E PACKAGE
SK-3	SINK – BAR	1/2"	1/2"	2"	1-1/2"	1-1/2"	JUST	SL-1617-A-GR	STAINLESS	DELTA FAUCET 3579 WFHDF, RIGID
SK-4	SINK – KITCHEN	1/2"	1/2"	2"	1-1/2"	1-1/2"	JUST	SLX-1617-A-GR	STAINLESS	DELTA FAUCET 3579 WFHDF, RIGID
SK-5	SINK – DOUBLE COMPARTMENT – LAB	1/2"	1/2"	2"	1-1/2"	2"	JUST	DL-1829-A-GR	STAINLESS	DELTA FAUCET 711-WFHDF, HAWS 7610 EMERGENCY EYEWASH, SWING
SK-6	SINK	1/2"	1/2"	2"	1-1/2"	2"	PER DENTAL EQUIPMENT SUPPLIER		STAINLESS	PER DENTAL EQUIPMENT SUPPLIER
SK-7	SINK – LAUNDRY	1/2"	1/2"	2"	1-1/2"	2"	FIAT	FL-1	WHITE	FIAT FAUCET A-1
SK-8	SINK – SERVICE	1/2"	1/2"	3"	2"	3"	FIAT	MSB-2424	WHITE	FIAT FAUCET 830-AA, 832-AA HOSE AND BRACKET, E-77-AA VINYL BUMPERGUARD, 889-CC MOP HANGER
DS-1	SINK – DENTAL	1/2"	1/2"	3"	2"	3"	PER DENTAL EQUIPMENT SUPPLIER		STAINLESS	PER DENTAL EQUIPMENT SUPPLIER
SH-1	SHOWER – ADA	1/2"	1/2"	2"	1-1/2"	2"	FIAT	3636.01F	WHITE	RPW1111HDF, 60" FLEX HOSE, ADJUSTABLE WALL BRACKET, ADJUSTABLE MAXIMUM TEMP., INTEGRAL CHECK STOPS, PRESSURE BALANCED, VACUUM BREAKER
SV-1	SHOWER VALVE	1/2"	1/2"	----	----	----	DELTA	1305-WSHDF	----	RPW1111HDF, 60" FLEX HOSE, ADJUSTABLE WALL BRACKET, ADJUSTABLE MAXIMUM TEMP., INTEGRAL CHECK STOPS, PRESSURE BALANCED, VACUUM BREAKER
DF-1	DRINKING FOUNTAIN – SINGLE – ADA	1/2"	----	1-1/2"	1-1/2"	1-1/4"	HAWS	1109	STAINLESS	FRONT PUSH BUTTON, 6800 SUPPORT CARRIER, 6700 MOUNTING PLATE
WB-1	WASHER BOX	3/4"	3/4"	2"	1-1/2"	2"	GUY GRAY	T200	----	DRAIN ADAPTOR FOR DWV COPPER
FD-1	FLOOR DRAIN	----	----	2"	1-1/2"	2"	J.R. SMITH	2010-WF	----	ROUND TOP, TRAP PRIMER CONNECTION
FD-2	FLOOR DRAIN	----	----	2"	1-1/2"	2"	J.R. SMITH	DX-2005	----	ROUND TOP, TRAP PRIMER CONNECTION
HB-1	HOSE BIBB – FROST PROOF	3/4"	----	----	----	----	WOODFORD	MODEL 65	----	WITH TEE HANDLE, VACUUM BREAKER

EXPANSION TANK SCHEDULE

SYMBOL	MFGR / MODEL	FUNCTION	FLUID	TOTAL VOLUME (GALLONS)	ACCEPTANCE VOLUME (GALLONS)	DIMENSIONS	MATERIAL	LABEL	REMARKS
ET-1	AMTROL / SX-40V	HYDRONIC EXPANSION	50% P.G.	20	11.3	15"ø x 32"	STEEL/BUTYL	----	----
ET-2	AMTROL / ST-12	DOMESTIC HW EXPANSION	WATER	4.4	3.2	11"ø x 15"	STEEL/BUTYL	IAPMO	APPROVED FOR POTABLE WATER USE

GLYCOL MAKE-UP TANK SCHEDULE

SYMBOL	MFGR / MODEL	FUNCTION	FLUID	CAPACITY (GALLONS)	DIMENSIONS	MATERIAL	REMARKS
GT-1	AXIOM / MF200	GLYCOL MAKE UP	50% P.G.	6.6	12"x12"x16"H	PLASTIC	LOW LEVEL ALARM, ELECTRIC CORD AND PLUG

TANK SCHEDULE

SYMBOL	MFGR / MODEL	FUNCTION	FLUID	CAPACITY (GALLONS)	DIMENSIONS	MATERIAL	LABEL	REMARKS
FOT-1	ACE TANK / AC00550U2K4	FUEL OIL STORAGE	F.O.	550	48"ø x 75"	STEEL	UL	DOUBLE WALL, ABOVE GROUND, SKID MOUNTED

HOT WATER GENERATOR SCHEDULE

SYMBOL	MFGR / MODEL	DOMESTIC HOT WATER				HEATING MEDIUM					LABEL	REMARKS
		RECOVERY (GPH)	CAPACITY (GAL)	EWT	LWT	FLUID	FLOW (GPM)	WPD (FT HD)	EGT	LGT		
HWG-1	AMTROL / WHS-60ZC-DW	268	60	40°F	120°F	50% P.G	7	10'	180°F	150°F	---	DOUBLE WALL VENTED COIL

PUMP SCHEDULE

SYMBOL	MFGR / MODEL	SERVICE	FLUID	GPM	HEAD FT.	MOTOR DATA		REMARKS
						HP	VOLTS/PH	
CP-1	GRUNDFOS / UPS 40-160/2	PERIMETER HEAT	50% P.G.	28.4	25'	3/4	208/3	SET INITIALLY AT SPEED ONE
CP-2	GRUNDFOS / UPS 40-160/2	PERIMETER HEAT	50% P.G.	28.4	25'	3/4	208/3	BACKUP TO CP-1, SET INITIALLY AT SPEED ONE
CP-3	GRUNDFOS / UP 26-96F	HOT WATER GENERATOR	WATER	7	17'	1/12	120/1	----
CP-4	GRUNDFOS / UP 15-18 B7	HOT WATER CIRCULATION	WATER	2	4'	1/25	120/1	BRONZE CONSTRUCTION



DATE	REVISIONS					INT.



ALASKA NATIVE TRIBAL HEALTH CONSORTIUM

DIVISION OF ENVIRONMENTAL HEALTH AND ENGINEERING

1901 SOUTH BRAGAW STREET, SUITE 200
ANCHORAGE, ALASKA 99508-3440
(907) 729-3600

ALASKA NATIVE CONSORTIUM • TRIBAL HEALTH

McGRATH SUB-REGIONAL HEALTH CENTER

EQUIPMENT SCHEDULES
LEGEND & ABBREVIATIONS

FILE NAME: 08167-M01
LAYOUT NAME: LAYOUT1
PROJ ENG: ALEC C. THOMSON, P.E.

DATE: 04/20/09
SCALE: AS NOTED
DRAWN BY: TOH

SEQUENCE OF OPERATION

BOILERS (B-1 AND B-2)
BOILER CONTROLLER SHALL CONTROL BOILER CIRCULATION PUMPS AND FIRE BOILER TO MAINTAIN SUPPLY TEMPERATURE BETWEEN 180°F AND 150°F BASED ON OUTSIDE AIR TEMPERATURE. BOILER CONTROLLER SHALL SHUT DOWN BOILER AND LEAD SYSTEM CIRCULATION PUMP, CP-1 OR CP-2, ON OUTSIDE AIR TEMPERATURES OF 65°F (ADJUSTABLE) AND HIGHER. ON CALL FOR HEAT FROM THE HOT WATER GENERATOR CIRCULATION PUMP, CP-3 SHALL OPERATE, CONTROL VALVE SHALL OPEN AND BOILER SHALL FIRE TO MAINTAIN BOILER TEMPERATURE OF 180°F (ADJUSTABLE). REDUNDANT HIGH LIMIT CONTROLLER SHALL DISABLE BOILER ABOVE 210°F. AT LOW WATER CONDITION, LOW WATER CUT-OFF SHALL DISABLE BOILER, PROVIDE MANUAL RESET.

CIRCULATION PUMP (CP-1 AND CP-2)
CP-1 AND CP-2 LEAD DESIGNATION SHALL BE BY PUMPS MANUAL DISCONNECTS.

CIRCULATION PUMP (CP-3)
PUMP SHALL RUN AS INDICATED UNDER BOILER SEQUENCE.

CIRCULATION PUMP (CP-4)
PUMP SHALL RUN CONTINUOUSLY.

HOT WATER GENERATOR (HWG-1)
WATER HEATER'S AQUASTAT SHALL CALL FOR HEAT TO MAINTAIN TANK WATER TEMPERATURE OF 115°F (ADJUSTABLE). CONTROL VALVE SHALL OPEN AND CIRCULATION PUMP, CP-3, SHALL OPERATE. COORDINATE WITH BOILER CONTROL SEQUENCE.

BASEBOARD RADIATION (BB-1 AND BB-2)
ON SECOND STAGE OF HEAT ZONE THERMOSTAT SHALL CYCLE ZONE CONTROL VALVE TO MAINTAIN SPACE TEMPERATURE.

CABINET UNIT HEATERS (CUH-1 AND CUH-2)
THERMOSTAT SHALL CYCLE BLOWER TO MAINTAIN SPACE TEMPERATURE.

UNIT HEATER (UH-1, UH-2 AND UH-3)
THERMOSTAT SHALL CYCLE BLOWER TO MAINTAIN SPACE TEMPERATURE.

EXHAUST FAN (EF-1, EF-2, EF-3, EF-4 AND EF-6)
ON-OFF CONTROL VIA WALL MOUNTED SWITCH.

EXHAUST FAN (EF-5 AND EF-7)
ON TEMPERATURE RISE ABOVE LINE VOLTAGE THERMOSTAT SETPOINT (ADJUSTABLE) FAN SHALL OPERATE.

EXHAUST FAN (EF-9)
ON TEMPERATURE RISE ABOVE LINE VOLTAGE THERMOSTAT SETPOINT (ADJUSTABLE) FAN SHALL OPERATE AND VENTILATION OPENING CONTROL DAMPER SHALL OPEN.

EXHAUST FAN (EF-8)
ON-OFF CONTROL VIA HUMDISTAT. ON HUMIDITY RISE ABOVE SETPOINT (ADJUSTABLE) FAN SHALL OPERATE.

HEAT RECOVERY VENTILATOR (HRV-1)
UNIT SHALL OPERATE CONTINUOUSLY DURING OCCUPIED HOURS, BASED ON 7-DAY, 24-HOUR PROGRAM AS DETERMINED BY OWNER. UNIT MOUNTED ELECTRONIC CONTROLLER SHALL CONTROL FAN SPEED. HUMIDISTAT SHALL INCREASE SPEED AUTOMATICALLY AS REQUIRED TO MAINTAIN 50% RH. ELECTRONIC CONTROLLER SHALL AUTOMATICALLY ENGAGE DEFROST CYCLE AS REQUIRED TO MAINTAIN HEAT TRANSFER COIL FROST FREE. REMOTE DIGITAL ELECTRONIC TIMERS SHALL ENGAGE HRV IF UNIT IS OFF, OR BOOST HRV TO HIGH SPEED IF UNIT IS ON, FOR 20-MINUTE TIME DURATION.

DUCT COIL (DC-1)
THREE WAY CONTROL VALVE SHALL MODULATE TO MAINTAIN DUCT SUPPLY AIR TEMPERATURE (65°F ADJUSTABLE). PROVIDE CONTACTS ON VALVE SO THAT ON GREATER THAN 10% OPEN A CALL FOR HEAT IS PROVIDED TO THE BOILER.

BOILER SCHEDULE

SYMBOL	MFGR / MODEL	FLUID	FUEL	GROSS INPUT (MBH)	GROSS IBR OUTPUT (MBH)	BURNER		LABEL	REMARKS
						HP	VOLTS/PH		
B-1	ENERGY KINETICS / EK-2 FRONTIER	50% P.G.	OIL	196	175.5	FR	120/1	UL	30 PSI RELIEF VALVE, SWING AWAY BURNER DOOR
B-2	ENERGY KINETICS / EK-2 FRONTIER	50% P.G.	OIL	196	175.5	FR	120/1	UL	30 PSI RELIEF VALVE, SWING AWAY BURNER DOOR

DUCT COIL SCHEDULE

SYMBOL	MFGR	SIZE	CFM	AIR P.D. (IN. W.C.)	VELOCITY (FPM)	EAT	LAT	GPM	FLUID	EFT	LFT	WPD (FT. HD.)	REMARKS
DC-1	TITUS	PER MFGR	415	<0.12	<700	55°F	70°F	0.5	50% P.G.	180°F	150°F	<1	HEIGHT NOT TO EXCEED ADJACENT DUCT HEIGHT

BASEBOARD RADIATION SCHEDULE

SYMBOL	MFGR / MODEL	OUTPUT (BTU/LF)	FLUID	EGT	LGT	TUBE SIZE	ELEMENT FIN SIZE	FIN PER FOOT	FIN THICKNESS	NUMBER OF TIERS	MOUNTING HEIGHT	ENCLOSURE THICKNESS	REMARKS
BB-1	STERLING / JV14B-S	1,120	50% P.G.	180°F	160°F	3/4"	4-1/4" X 3-5/8"	50	0.020"	1	18"	16 GAUGE	SLOPE TOP ENCLOSURE
BB-2	STERLING / C3/4-435	980	50% P.G.	180°F	160°F	3/4"	4-1/4" X 3-5/8"	50	0.020"	1	---	---	BARE ELEMENT

UNIT HEATER SCHEDULE

SYMBOL	MFGR / MODEL	CAPACITY MBH	GPM	FLUID	EGT	LGT	WPD FT HD	CFM	MOTOR DATA		REMARKS
									HP	VOLTS/PH	
UH-1	MODINE / HC-47	22.7	3.2	50% P.G.	180°F	160°F	<1'	730	1/12	120/1	---
UH-2	MODINE / HC-18	9.2	1.3	50% P.G.	180°F	160°F	<1'	340	1/60	120/1	---
UH-3	MODINE / HC-18	9.2	1.3	50% P.G.	180°F	160°F	<1'	340	1/60	120/1	---
CUH-1	MODINE / CW-03	16.2	2.2	50% P.G.	180°F	160°F	<1'	330	1/30	120/1	---
CUH-2	MODINE / CW-03	16.2	2.2	50% P.G.	180°F	160°F	<1'	330	1/30	120/1	---

AIR SEPARATOR SCHEDULE

SYMBOL	MFGR / MODEL	FLUID	GPM	WPD (FT. HD)	INLET/OUTLET SIZE	DIMENSIONS	REMARKS
AS-1	SPIROTHERM / VJR 200TM	50% P.G.	34.9	<3'	2"	10.8"H x 4.0"ø	---

HEAT RECOVERY VENTILATOR SCHEDULE

SYMBOL	MFGR / MODEL	AIRFLOW (CFM)	TSP @ HIGH SPEED (IN. WG)	ELEC. DATA		REMARKS
				WATTS	VOLTS/PH	
HRV-1	LIFEBREATH / 500 DCS	415	0.5	610	120/1	BALANCE DAMPERS/AIR FLOW STATION, PROGRAMMABLE CONTROLLER WITH DEHUMIDISTAT, TIME CLOCK, REMOTE DIGITAL TIMER

FAN SCHEDULE

SYMBOL	MFGR / MODEL	TYPE	SERVICE	CFM	TSP (IN. WG)	MOTOR DATA		DRIVE	SONES	REMARKS
						AMPS	VOLTS/PH			
EF-1	GREENHECK / SP-B90	CENTRIFUGAL	TOILET EXHAUST	75	0.25	0.65	120/1	DIRECT	<5	WALL CAP, BACKDRAFT DAMPER
EF-2	GREENHECK / SP-B90	CENTRIFUGAL	TOILET EXHAUST	75	0.25	0.65	120/1	DIRECT	<5	WALL CAP, BACKDRAFT DAMPER
EF-3	GREENHECK / SP-B90	CENTRIFUGAL	TOILET EXHAUST	75	0.25	0.65	120/1	DIRECT	<5	WALL CAP, BACKDRAFT DAMPER
EF-4	GREENHECK / SP-B90	CENTRIFUGAL	TOILET EXHAUST	75	0.25	0.65	120/1	DIRECT	<5	WALL CAP, BACKDRAFT DAMPER
EF-5	GREENHECK / SP-B200	CENTRIFUGAL	MORGUE EXHAUST	166	0.25	2.2	120/1	DIRECT	<6	WALL CAP, BACKDRAFT DAMPER
EF-6	GREENHECK / SP-B90	CENTRIFUGAL	LAB EXHAUST	75	0.25	0.65	120/1	DIRECT	<5	WALL CAP, BACKDRAFT DAMPER
EF-7	GREENHECK / SP-B150	CENTRIFUGAL	TELE/ELECTRICAL COOLING	150	0.25	1.7	120/1	DIRECT	<5	WALL CAP, BACKDRAFT DAMPER
EF-8	GREENHECK / SP-B150	CENTRIFUGAL	CRAWLSPACE EXHAUST	150	0.25	1.7	120/1	DIRECT	<5	WALL CAP, BACKDRAFT DAMPER
EF-9	GREENHECK / CSP-A510	CENTRIFUGAL	MECHANICAL ROOM COOLING	405	0.25	3.11	120/1	DIRECT	<5	WALL CAP, BACKDRAFT DAMPER

GRILLE - REGISTER - DIFFUSER SCHEDULE

SYMBOL	MFGR / MODEL	TYPE	SERVICE	MATERIAL	FINISH	FACE SIZE	DIFFUSER NECK SIZE	THROW	REMARKS
SA	LIFEBREATH / TECHGRILLE	DIFFUSER	S/A	POLYPROPYLENE	WHITE	6.25"ø	5"ø"	4-WAY	ROUND FACE, AIRFLOW ADJUSTABLE BY POSITIONING CENTER CONE
SB	LIFEBREATH / TECHGRILLE	DIFFUSER	S/A	POLYPROPYLENE	WHITE	7.5"ø	6"ø"	4-WAY	ROUND FACE, AIRFLOW ADJUSTABLE BY POSITIONING CENTER CONE
SC	TITUS / CT-PP-0	GRILLE	---	ALUMINUM	WHITE	4"WIDE	---	---	LENGHT TO MATCH CABINET LENGTH COORDINATE WITH ARCHITECTURAL
EA	LIFEBREATH / TECHGRILLE	DIFFUSER	E/A	POLYPROPYLENE	WHITE	6.25"ø	5"ø"	4-WAY	ROUND FACE, AIRFLOW ADJUSTABLE BY POSITIONING CENTER CONE
EB	LIFEBREATH / TECHGRILLE	DIFFUSER	E/A	POLYPROPYLENE	WHITE	7.5"ø	6"ø"	4-WAY	ROUND FACE, AIRFLOW ADJUSTABLE BY POSITIONING CENTER CONE
TA	TITUS / CT-700L	GRILLE	T/A	ALUMINUM	WHITE	18/6	---	---	WITH AUXILIARY FRAME, MOUNT LOW IN DOOR



DATE	REVISIONS					INIT.



ALASKA NATIVE TRIBAL HEALTH CONSORTIUM

DIVISION OF ENVIRONMENTAL HEALTH AND ENGINEERING
1901 SOUTH BRAGAW STREET, SUITE 200
ANCHORAGE, ALASKA 99508-3440
(907) 729-3600

McGrath SUB-REGIONAL HEALTH CENTER

EQUIPMENT SCHEDULES

FILE NAME: 08167-M02


LAYOUT NAME: LAYOUT1

PROJ ENG: ALEC C. THOMSON, P.E.

DATE: 04/20/09

SCALE: AS NOTED

DRAWN BY: TOH

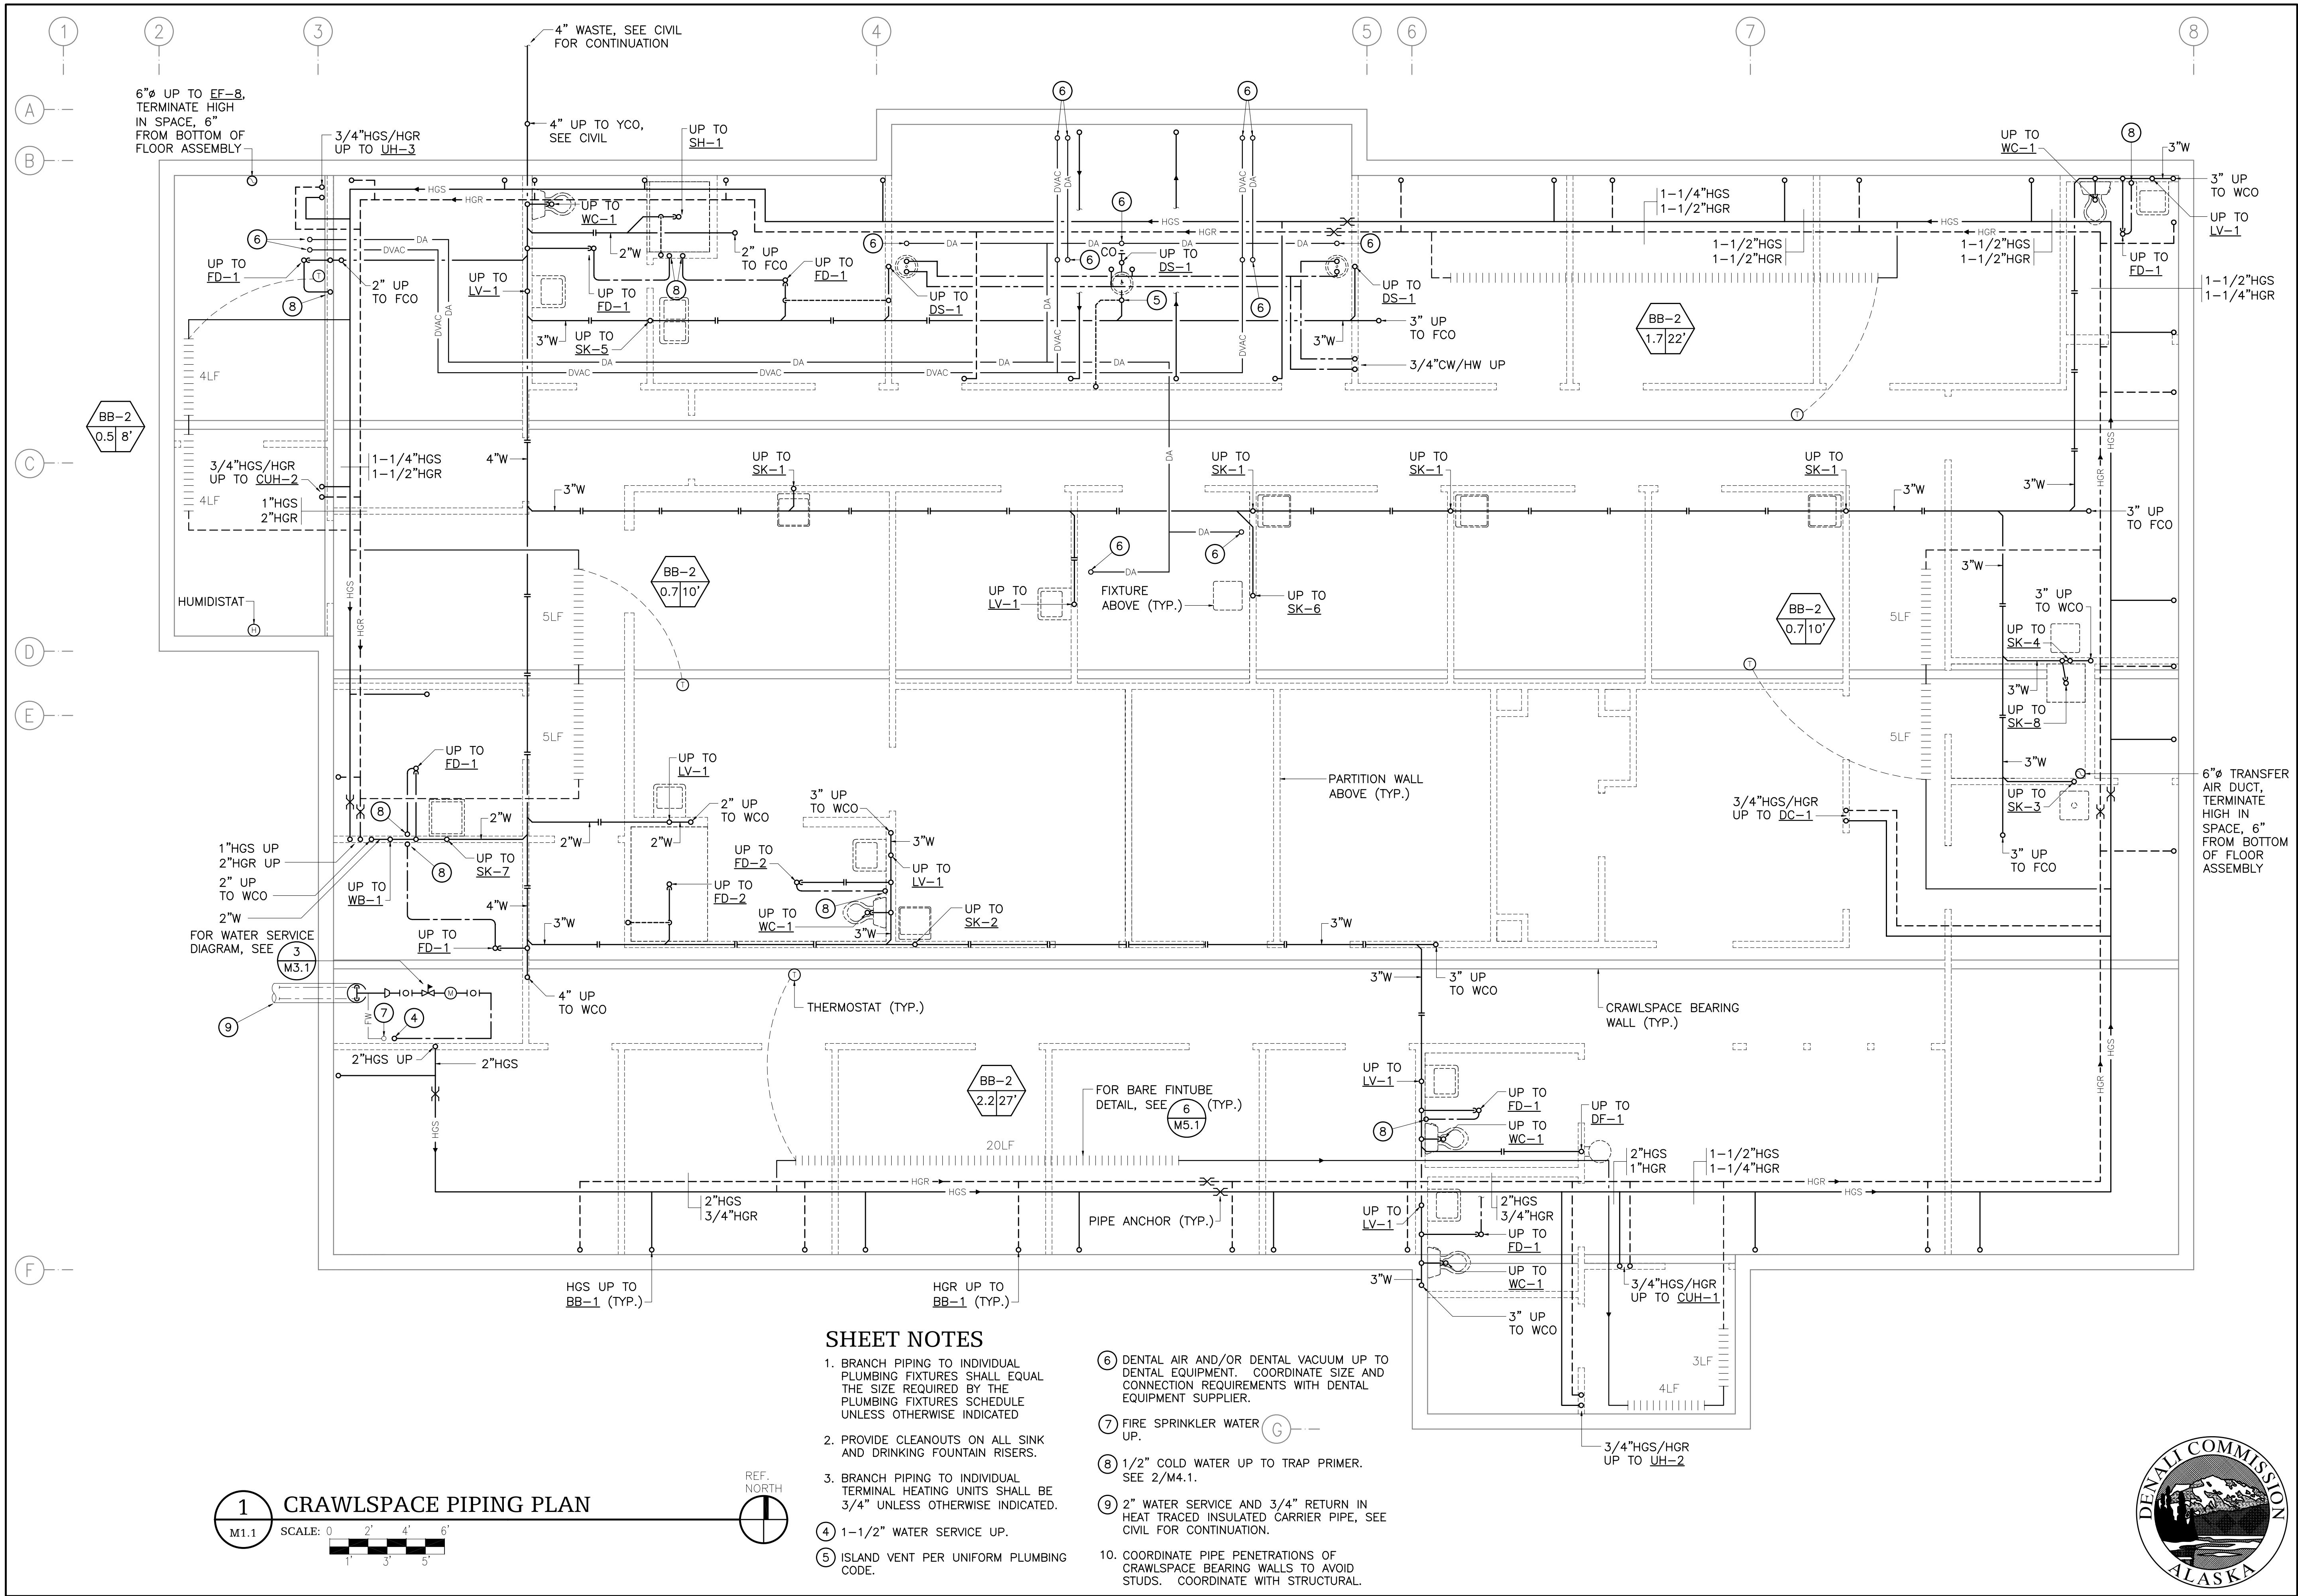

REVISIONS	
DATE	DESCRIPTION

STATE OF ALASKA
ALEC C. THOMSON
No. 94206
REGISTERED PROFESSIONAL ENGINEER

ALASKA NATIVE TRIBAL HEALTH CONSORTIUM

DIVISION OF ENVIRONMENTAL HEALTH AND ENGINEERING
1901 SOUTH BRAGAW STREET, SUITE 200
ANCHORAGE, ALASKA 99508-3440
(907) 729-3600

ALASKA NATIVE TRIBAL HEALTH CONSORTIUM


McGRATH SUB-REGIONAL HEALTH CENTER
CRAWLSPACE PLUMBING PLAN

FILE NAME: 08167-M11
LAYOUT NAME: LAYOUT1
PROJ ENG: ALEC C. THOMSON, P.E.

DATE: 04/20/09
SCALE: AS NOTED
DRAWN BY: TOH

DENALI COMMISSION
ALASKA

SHEET M1.1
3 OF 8M

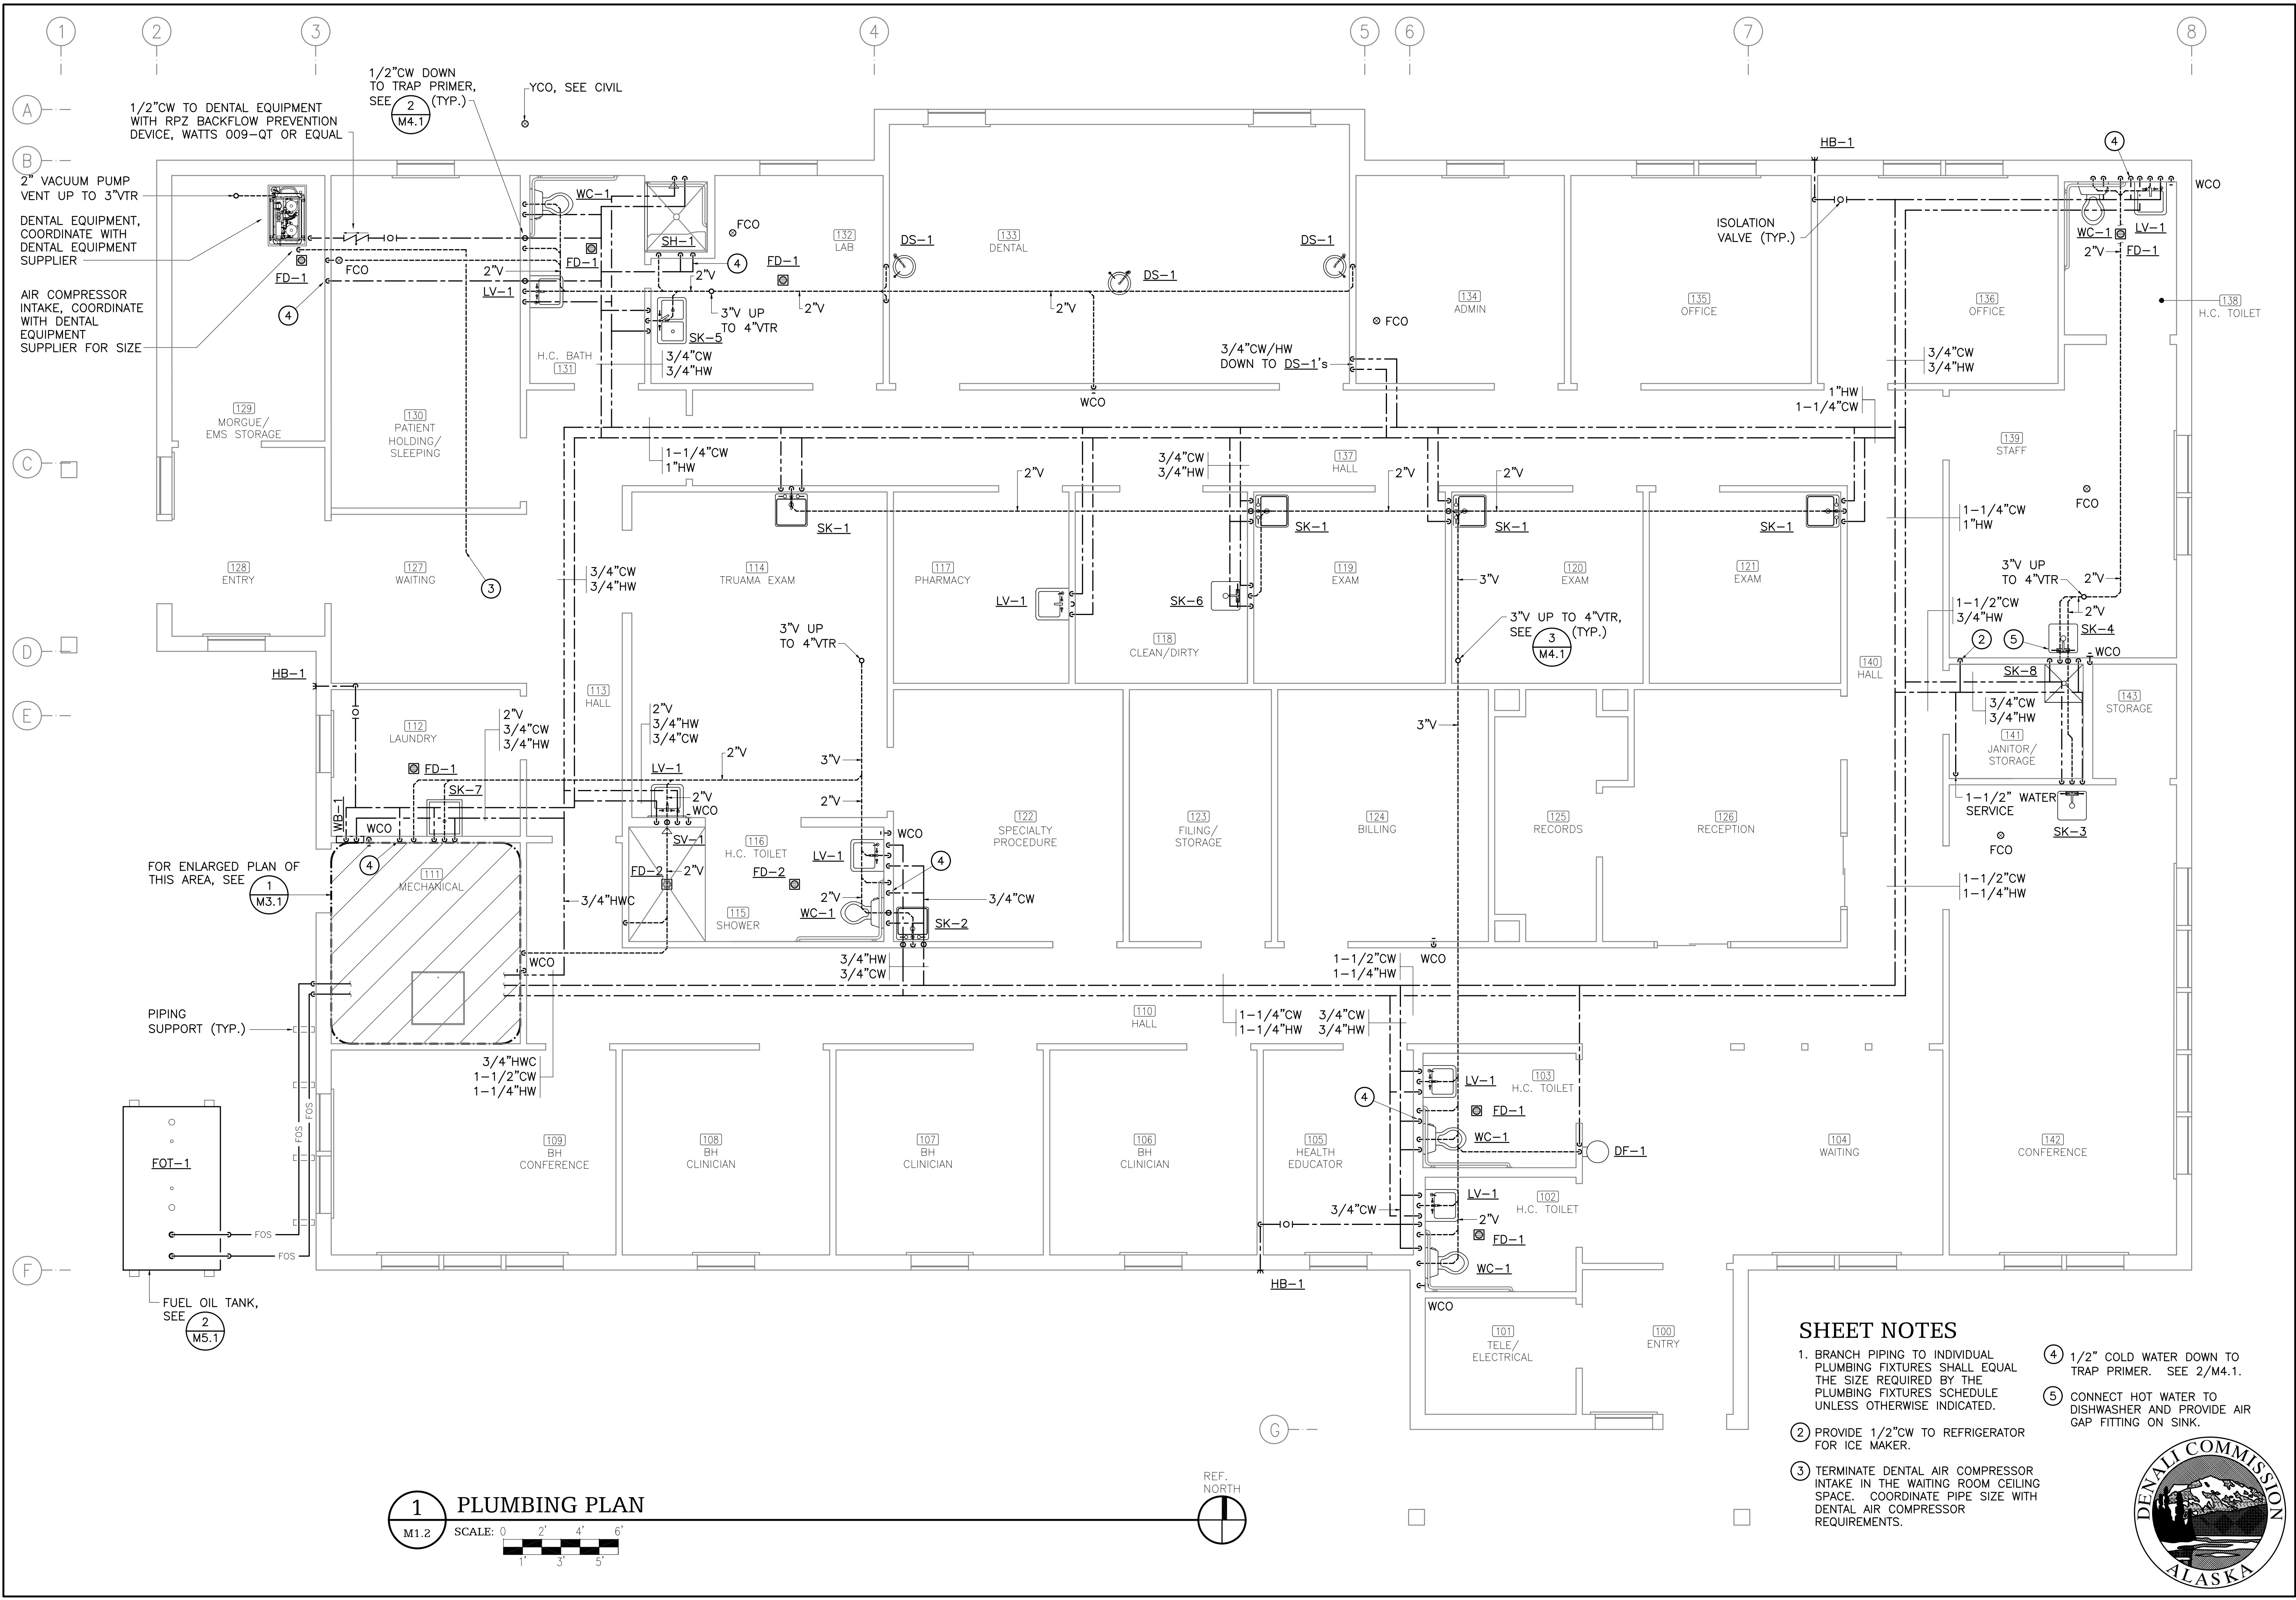

SHEET NOTES

- BRANCH PIPING TO INDIVIDUAL PLUMBING FIXTURES SHALL EQUAL THE SIZE REQUIRED BY THE PLUMBING FIXTURES SCHEDULE UNLESS OTHERWISE INDICATED.
- PROVIDE 1/2" CW TO REFRIGERATOR FOR ICE MAKER.
- TERMINATE DENTAL AIR COMPRESSOR INTAKE IN THE WAITING ROOM CEILING SPACE. COORDINATE PIPE SIZE WITH DENTAL AIR COMPRESSOR REQUIREMENTS.
- 1/2" COLD WATER DOWN TO TRAP PRIMER. SEE 2/M4.1.
- CONNECT HOT WATER TO DISHWASHER AND PROVIDE AIR GAP FITTING ON SINK.



McGrath SUB-REGIONAL HEALTH CENTER PLUMBING PLAN		FILE NAME: 08167-M12 LAYOUT NAME: LAYOUT1 PROJ ENG: ALEC C. THOMSON, P.E.
DATE: 04/20/09 SCALE: AS NOTED DRAWN BY: TOH	SHEET M1.2 4 OF 8M	

ALASKA NATIVE TRIBAL HEALTH CONSORTIUM

DIVISION OF ENVIRONMENTAL HEALTH AND ENGINEERING

1901 SOUTH BRAGAW STREET, SUITE 200
ANCHORAGE, ALASKA 99508-3440
(907) 729-3600






STATE OF ALASKA

REGISTERED PROFESSIONAL ENGINEER

NO. 2009

ALC

INIT.	
REVISIONS	
DATE	

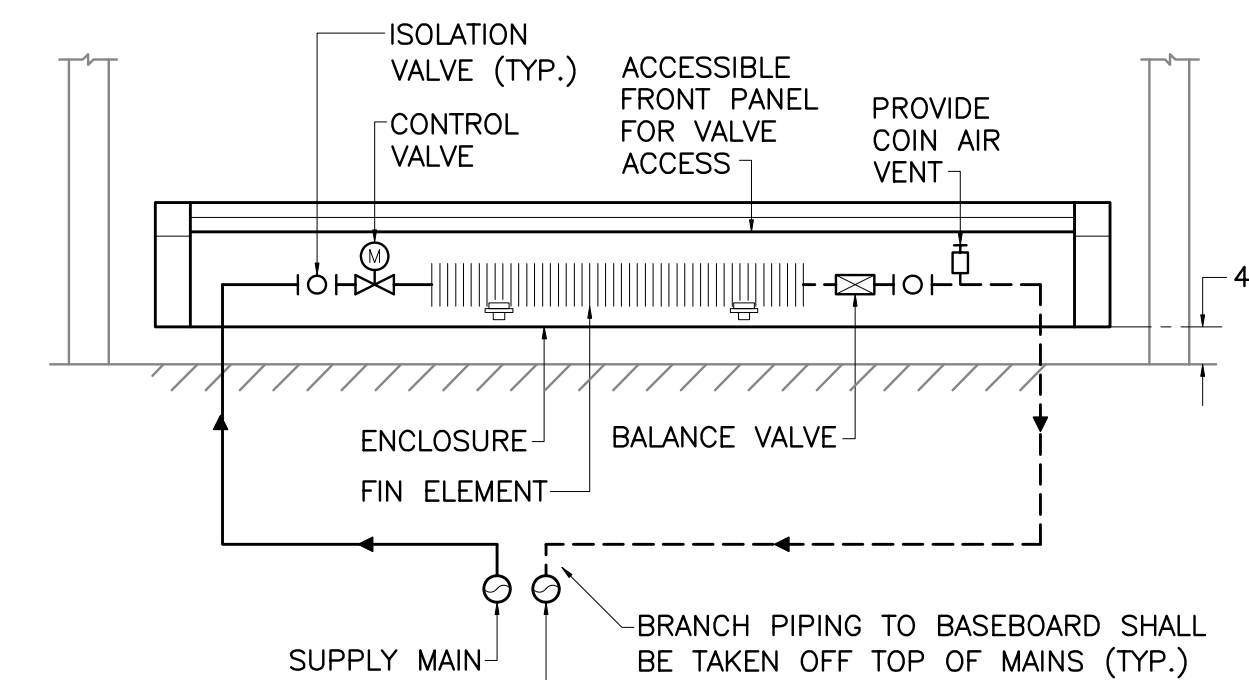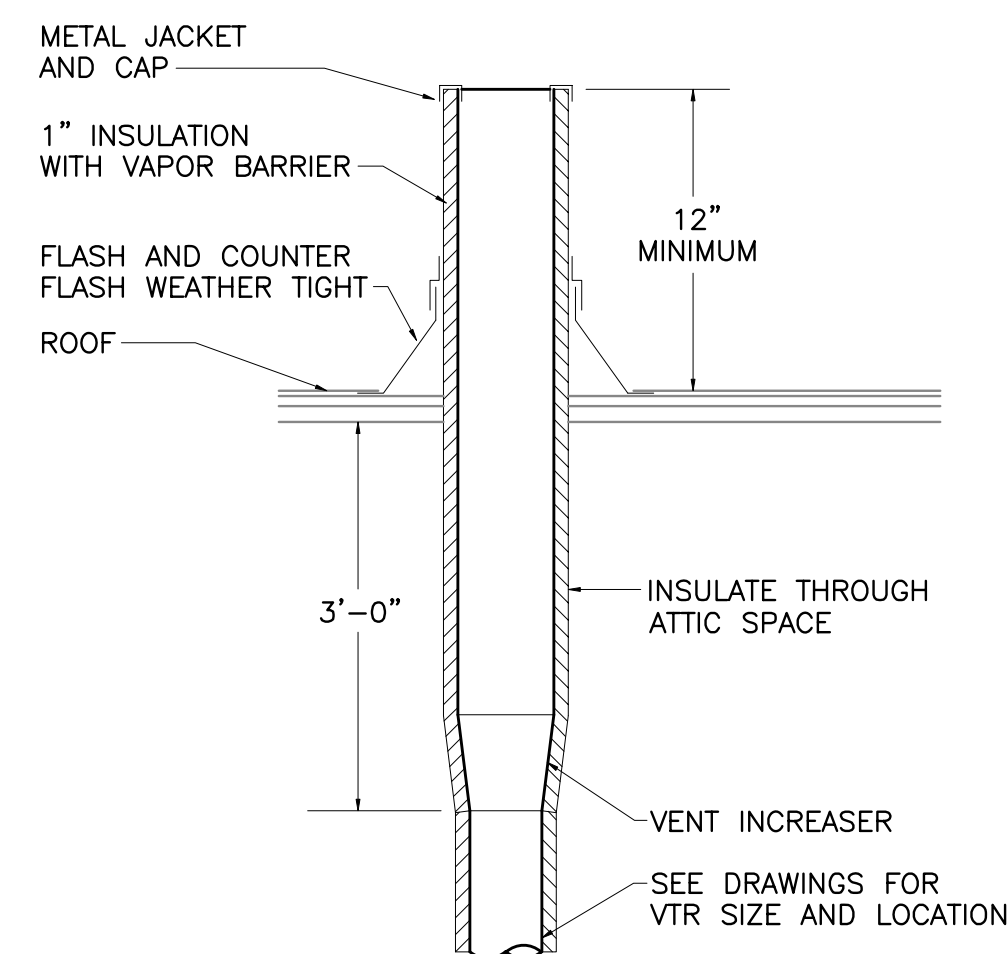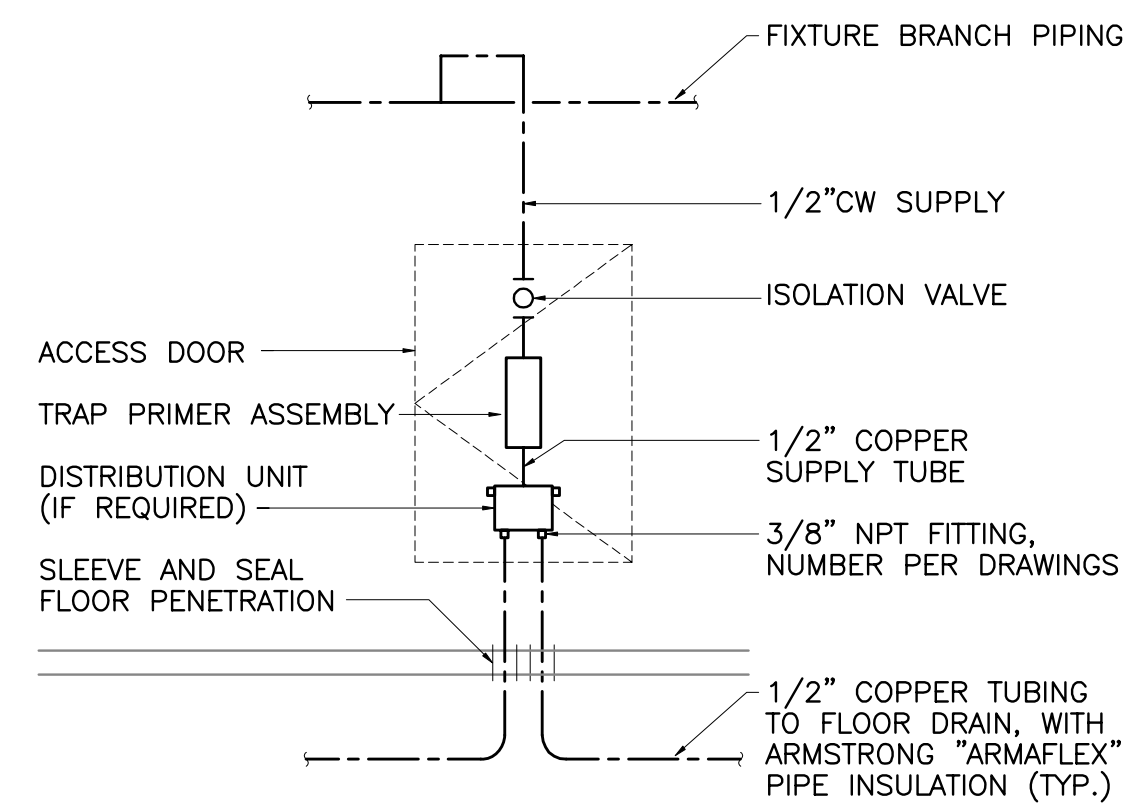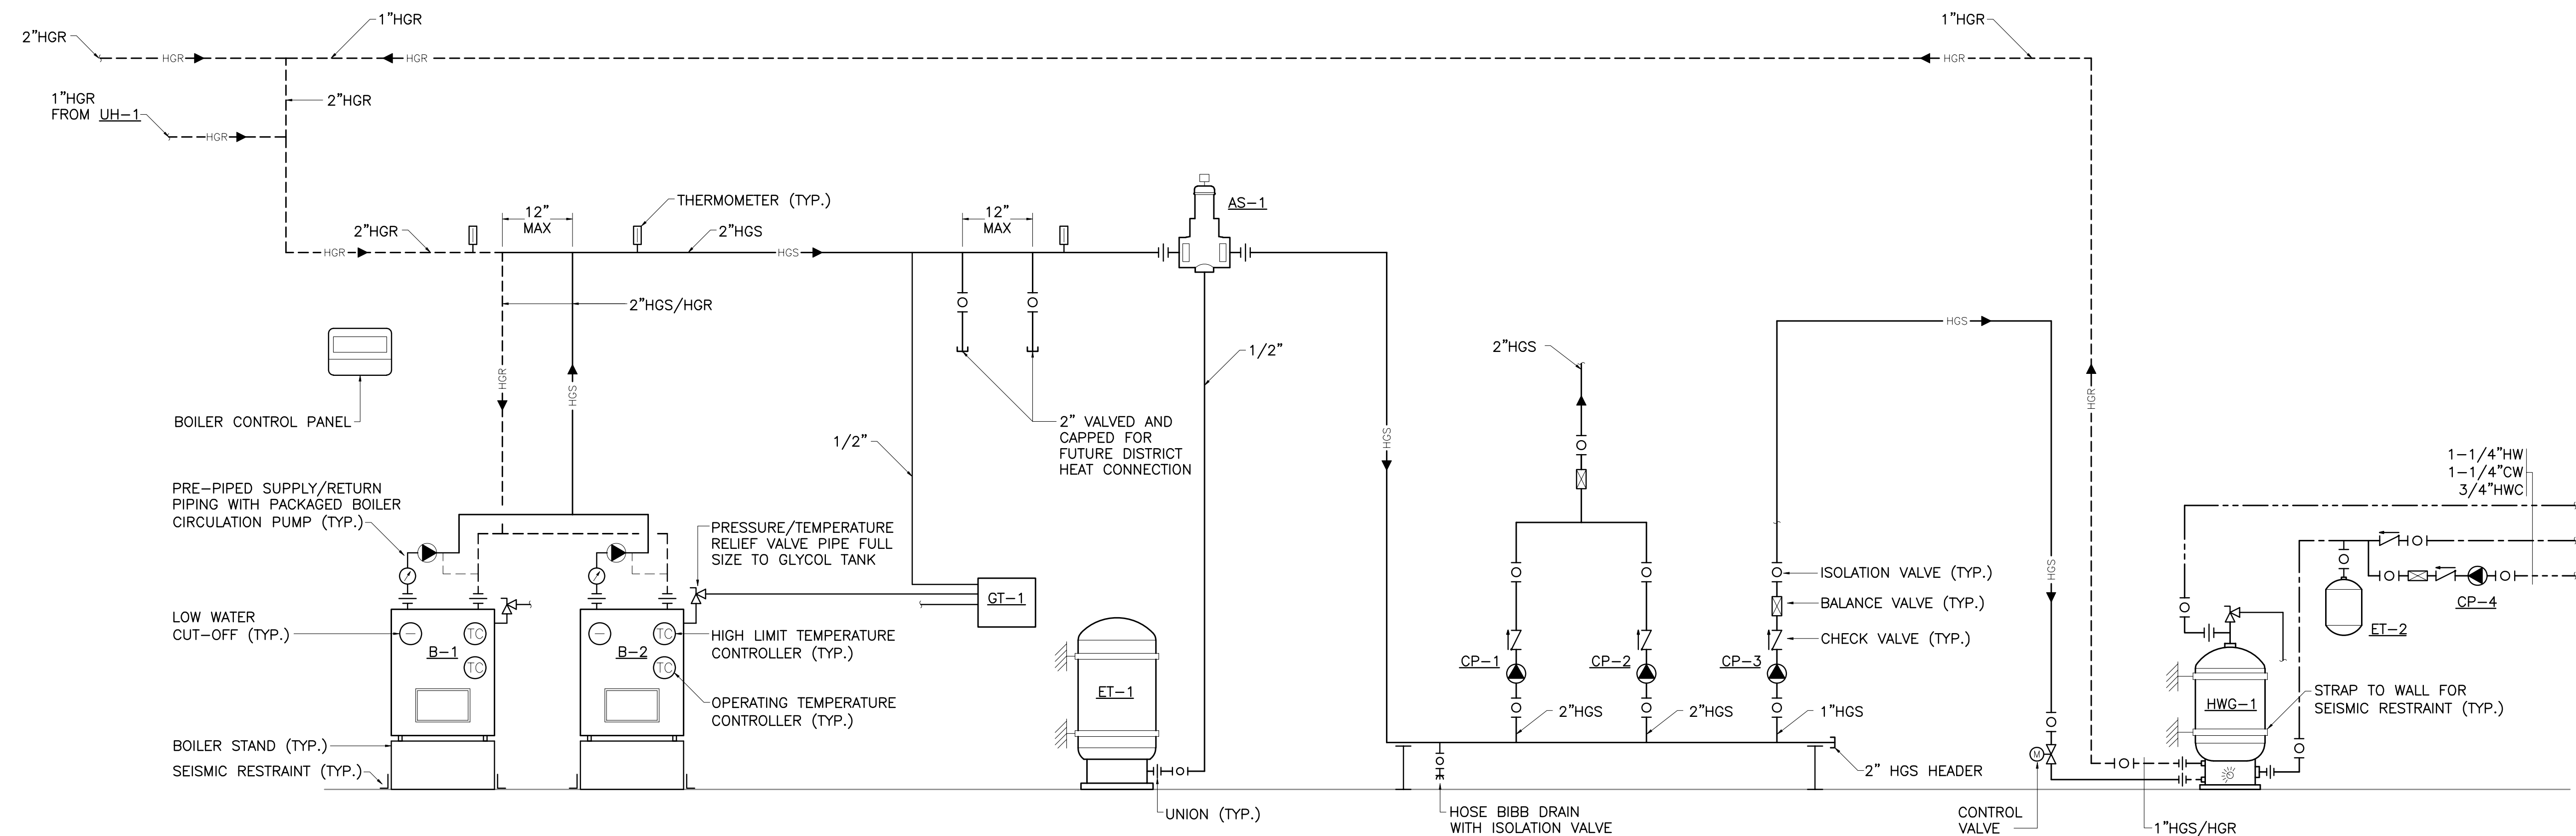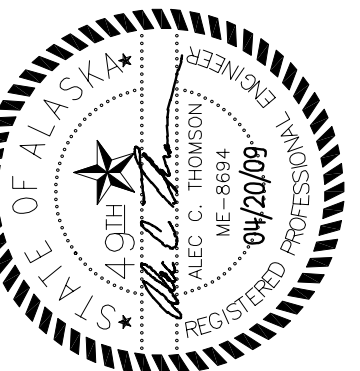[illegible]


ALASKA NATIVE
TRIBAL HEALTH CONSORTIUM

DIVISION OF ENVIRONMENTAL
HEALTH AND ENGINEERING


1901 SOUTH BRAGAW STREET, SUITE 200
ANCHORAGE, ALASKA, 99508-3440
(907) 729-3600




DATE: 04/20/09	FILE NAME: 08167-M61
AS SCALE: AS NOTED	LAYOUT NAME: LAYOUT1
DRAWN BY: TOH	PROJ ENG: ALEC C. THOMSON, P.E.

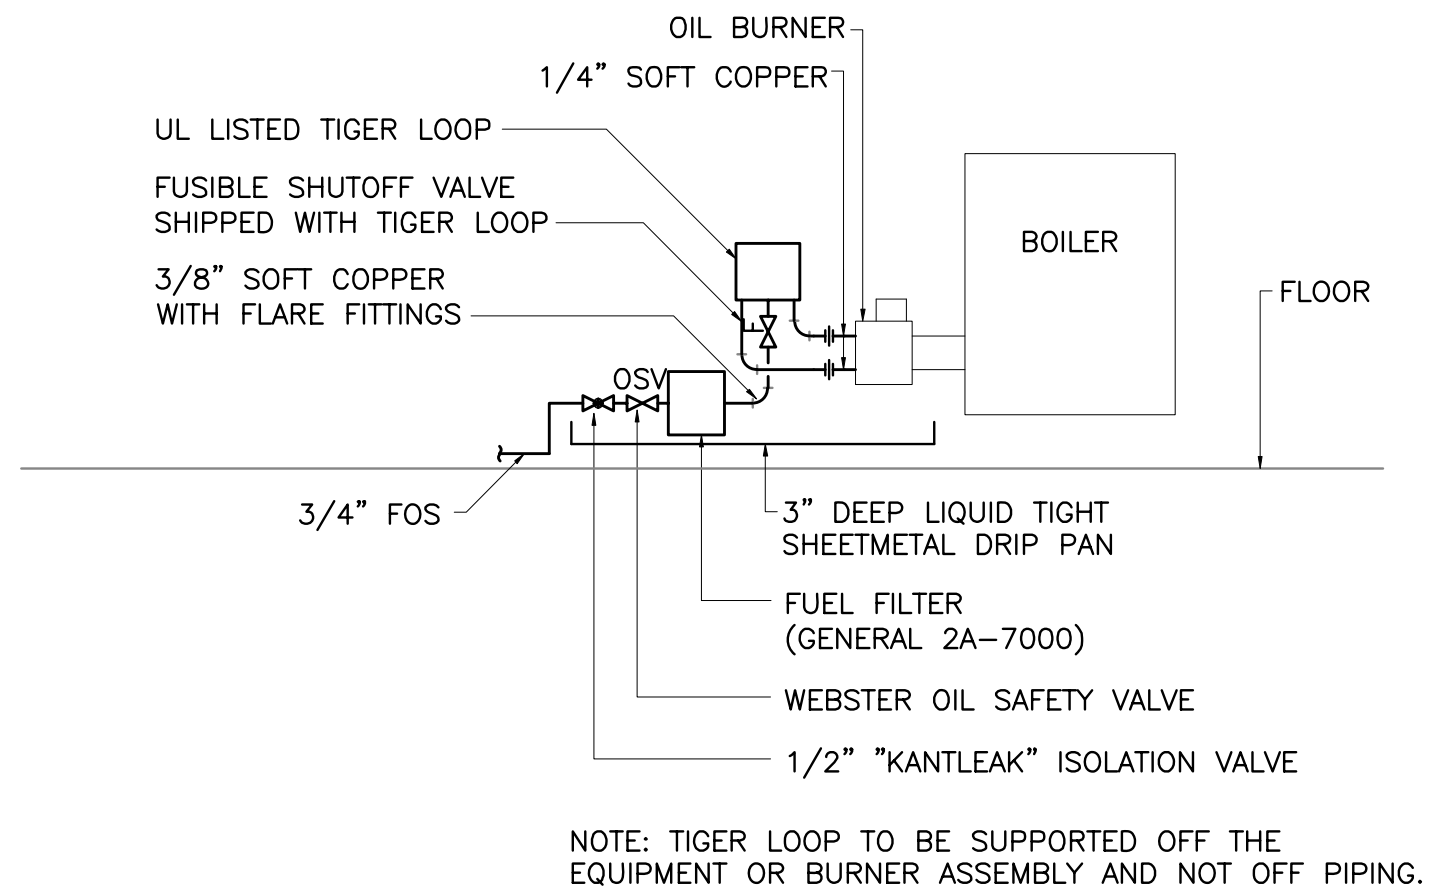


1 FUEL OIL PIPING DIAGRAM
M5.1 SCALE: NONE

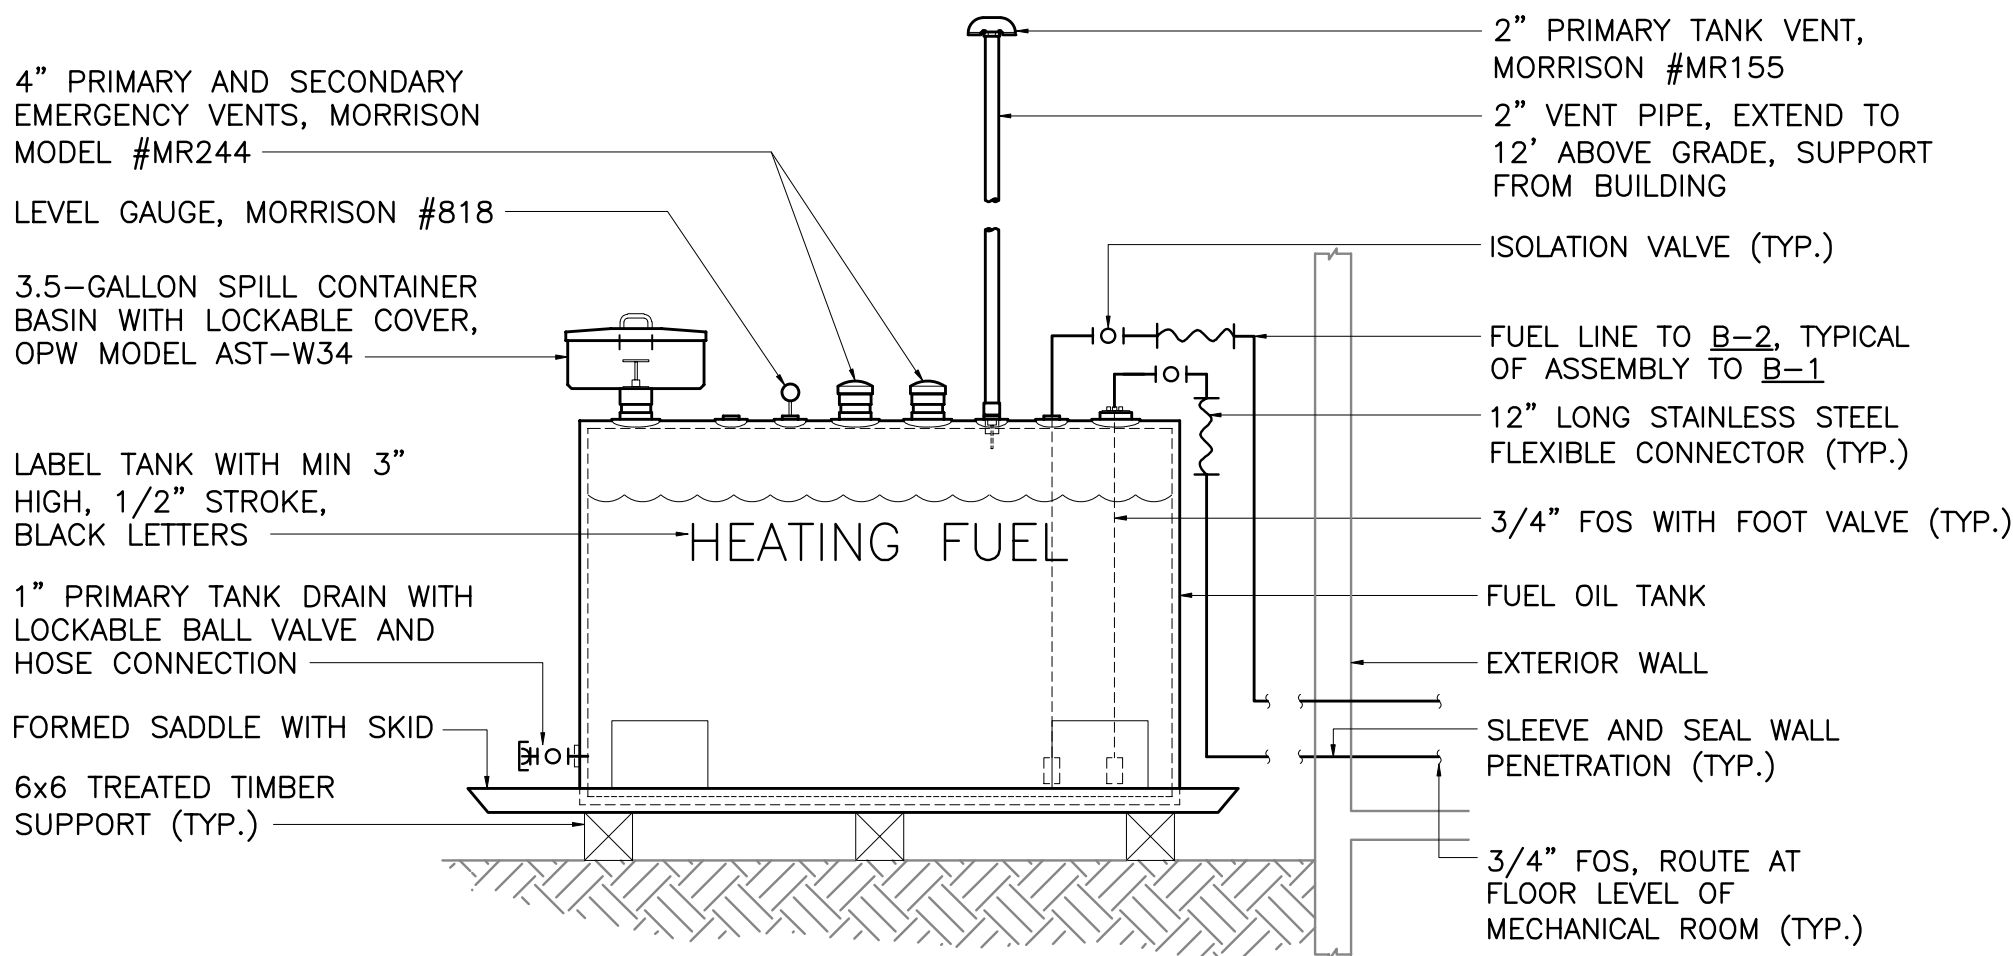

2 FUEL TANK DETAIL
M5.1 SCALE: NONE

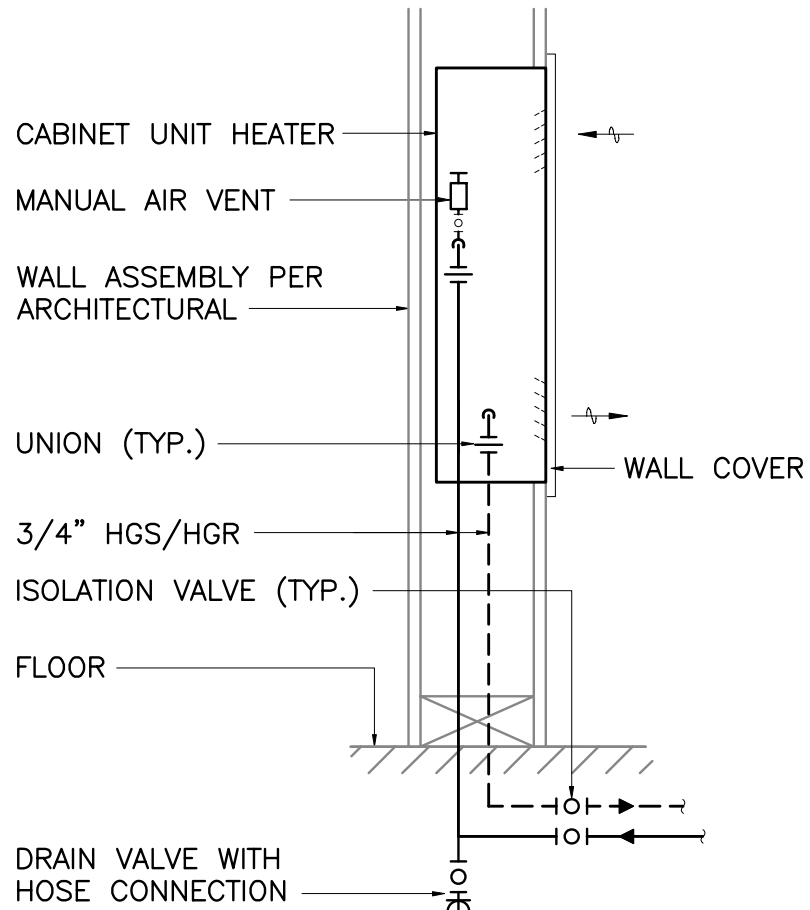


3 CABINET UNIT HEATER DETAIL
M5.1 SCALE: NONE

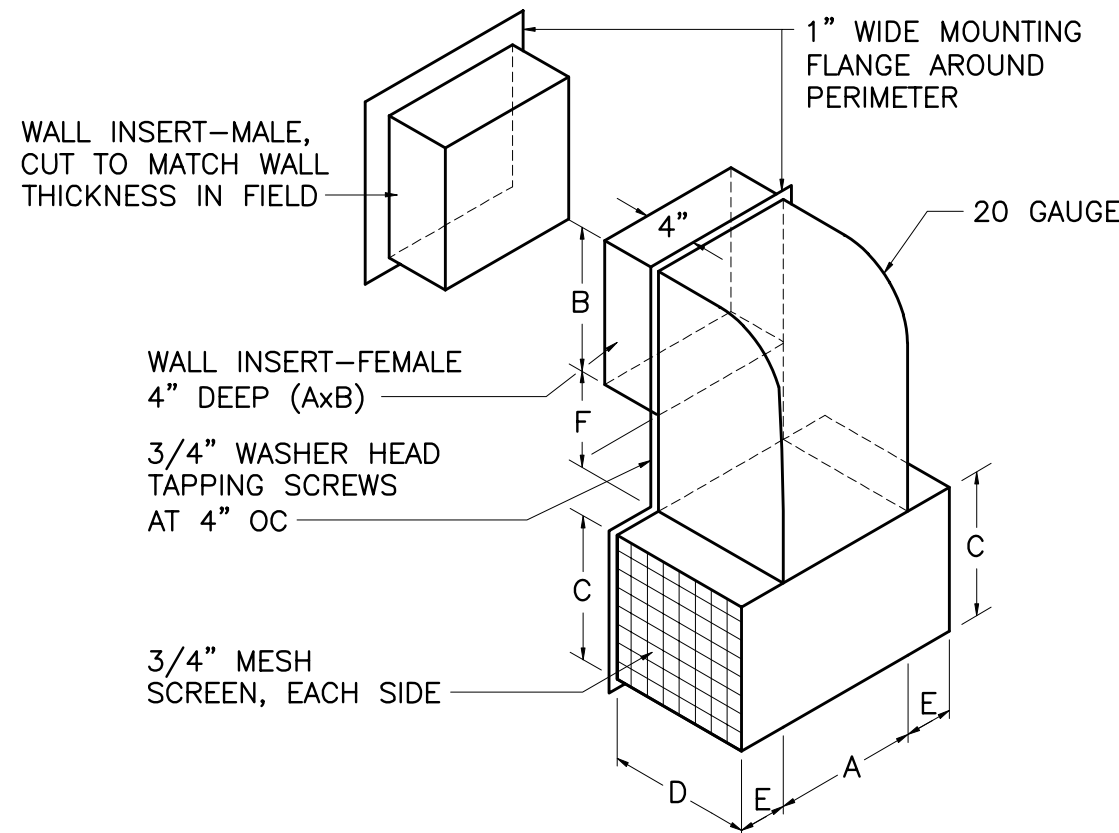


LOCATION	SERVICE	A	B	C	D	E	F
GABLE END	HRV INTAKE	14"	8"	7"	8"	6"	8"
GABLE END	HRV EXHAUST	14"	8"	N/A*	8"	N/A*	8"

* ARCTIC TEE NOT REQUIRED, TERMINATE WITH DOWN DISCHARGE


4 HEAT RECOVERY VENTILATION HOOD DETAIL
M5.1 SCALE: NONE

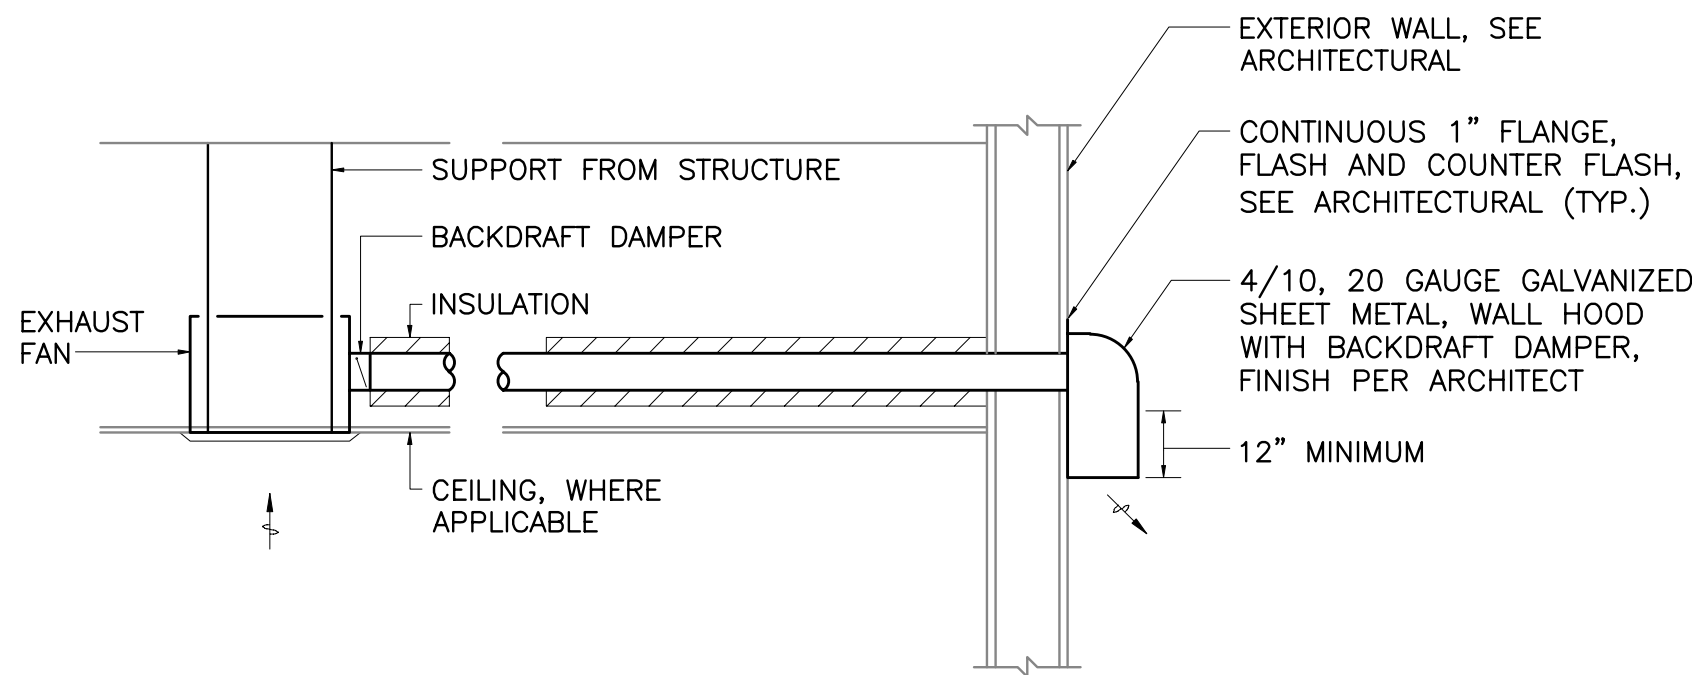


5 EXHAUST FAN DETAIL
M5.1 SCALE: NONE

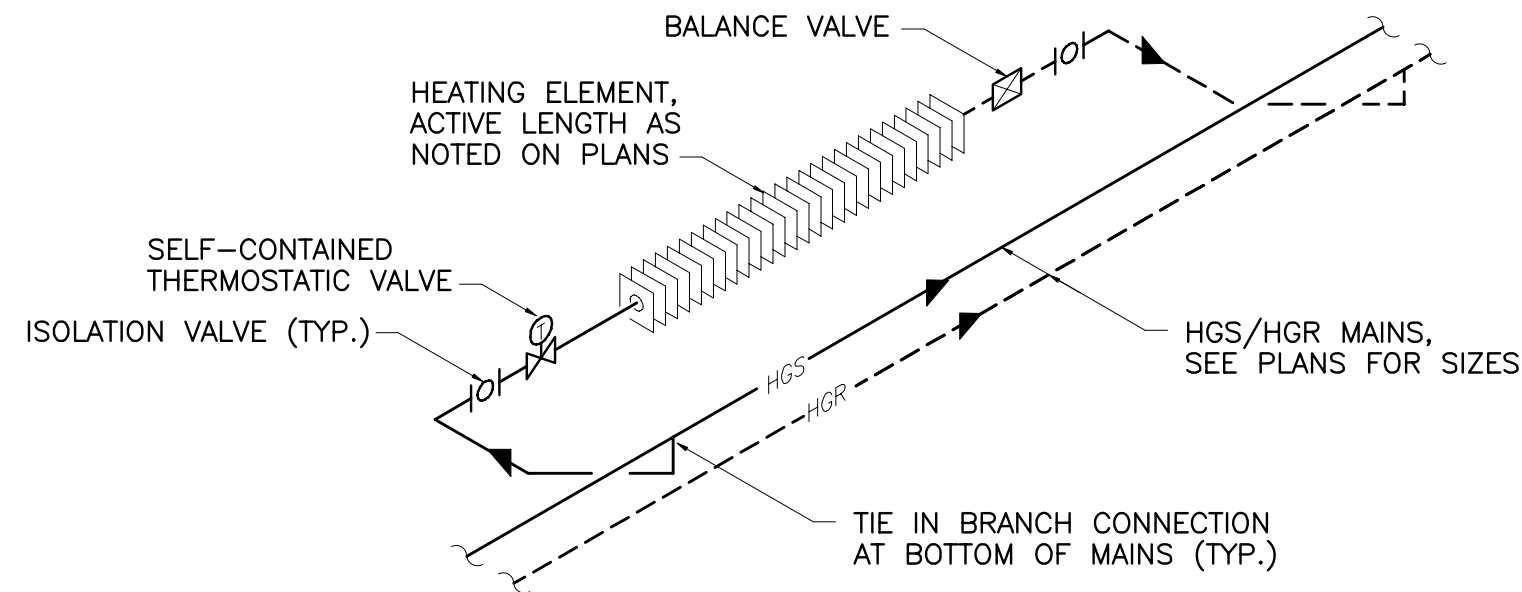


6 BARE FINTUBE DETAIL
M5.1 SCALE: NONE

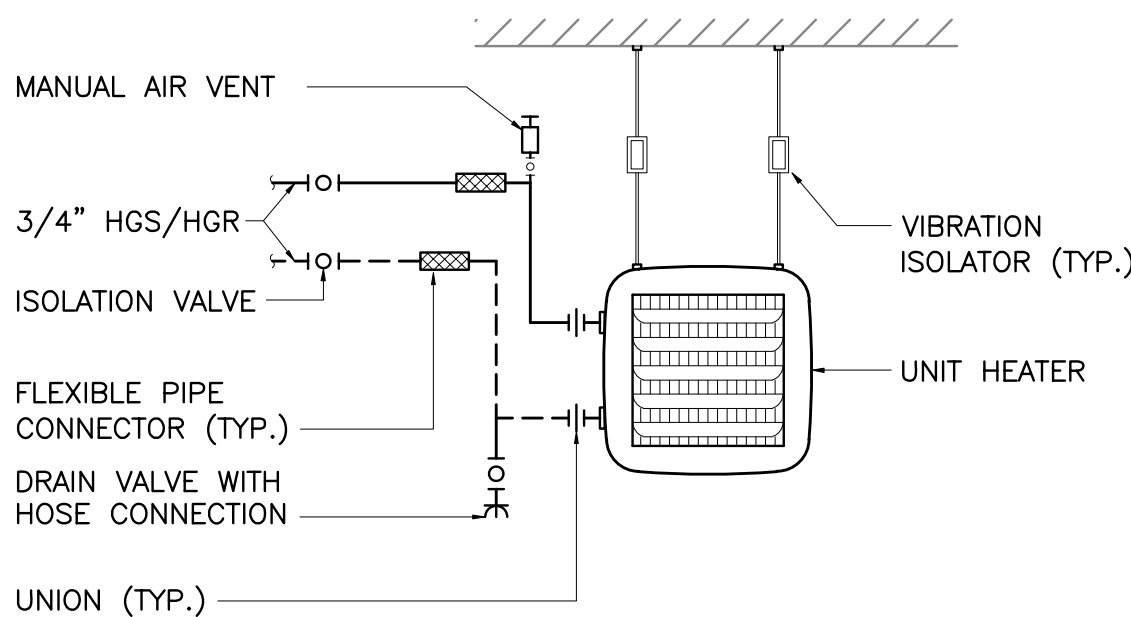

7 UNIT HEATER DETAIL
M5.1 SCALE: NONE

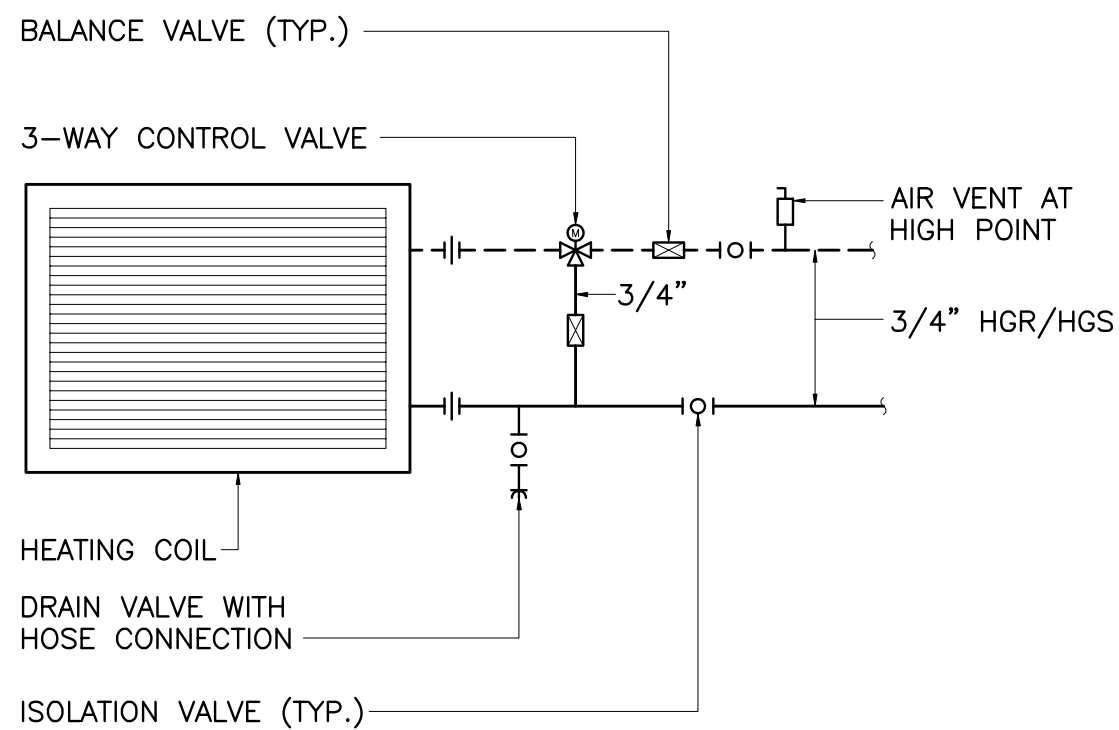

8 DUCT COIL DETAIL
M5.1 SCALE: NONE

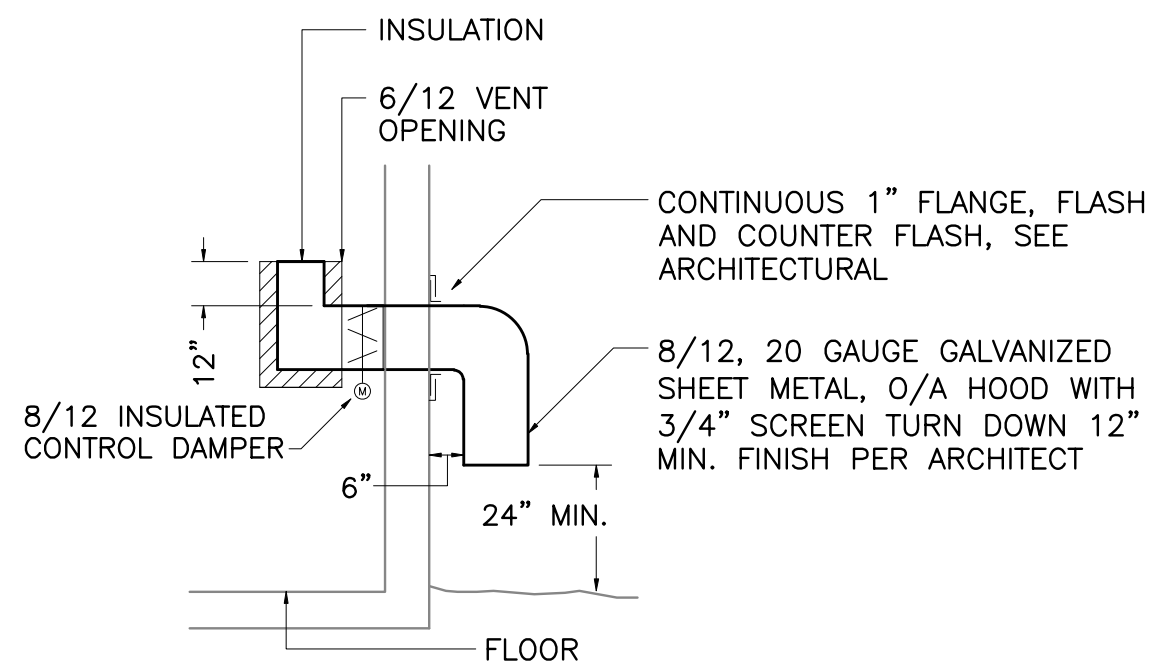

9 VENTILATION AIR DUCT DETAIL
M5.1 SCALE: NONE



INT.

REVISIONS

DATE

ALASKA NATIVE TRIBAL HEALTH CONSORTIUM

DIVISION OF ENVIRONMENTAL HEALTH AND ENGINEERING

1901 SOUTH BRAGAW STREET, SUITE 200
ANCHORAGE, ALASKA 99508-3440
(907) 729-3600

ALASKA NATIVE TRIBAL HEALTH CONSORTIUM

McGrath Sub-Regional Health Center

MECHANICAL DETAILS

FILE NAME: 08167-M71

LAYOUT NAME: LAYOUT1

PROJ ENG: ALEC C. THOMSON, P.E.

DATE: 04/20/09

SCALE: AS NOTED

DRAWN BY: TOH

SHEET M5.1

8 OF 8M

	LIGHT FIXTURE – SURFACE WALL MOUNTED		PANEL
	LIGHT FIXTURE – SURFACE MOUNTED		DUPLEX RECEPTACLE
	FLUORESCENT FIXTURE – RECESS MOUNTED 2'x4'		GROUND FAULT CURRENT INTERRUPTER RECEPTACLE
	FLUORESCENT FIXTURE – SURFACE MOUNTED 1'x4'		QUADRAPLEX RECEPTACLE
	FLUORESCENT FIXTURE – RECESS MOUNTED 1'x4'		# INDICATES SUPPLY BRANCH CIRCUIT
	FLUORESCENT FIXTURE – RECESS MOUNTED 2'x2'		SPECIAL PURPOSE RECEPTACLE
	FIXTURE WITH EMERGENCY BATTERY BACK-UP SEE NOTE 4 ON LIGHTING PLANS		DUPLEX RECEPTACLE-SWITCHED
	LIGHT FIXTURE – SURFACE MOUNTED		JUNCTION BOX
	LIGHT FIXTURE – WALL MOUNTED		FLOOR MOUNTED DEVICE (DUPLEX REC. SHOWN)
	FLUORESCENT STRIP FIXTURE – SURFACE MOUNTED		DISCONNECT SWITCH
	FLUORESCENT FIXTURE – SURFACE MOUNTED 4'		FUSED DISCONNECT SWITCH
	EXIT LIGHT – CEILING MOUNTED		COMBINATION MOTOR STARTER DISCONNECT
	EXIT LIGHT – WALL MOUNTED		FRACTIONAL HP MOTOR SWITCH
	SINGLE POLE SWITCH		MOTOR
	LOWER CASE LETTER INDICATES SWITCHING CONTROL		TELECOMMUNICATION OUTLET
	THREE WAY SWITCH AND FOUR WAY SWITCH		FA SMOKE DETECTOR
	OCCUPANCY SENSOR SWITCH		FA HEAT DETECTOR (FIXED TEMP. NOTED)
	PILOT LIGHT SWITCH		FA HORN STROBE
	LIGHTED TOGGLE SWITCH		FA MANUAL PULL STATION
	SPEED CONTROL SWITCH PROVIDED BY MECHANICAL		BELL
	TIMER SWITCH		STROBE
	CONDUIT, CONCEALED		KEY PAD
	NUMBER AND SIZE OF WIRES (NO SLASHES = 3#12)		NIGHT LIGHT
	HOMERUN TO PANEL (PANEL AND CIRCUIT No.)		GROUND FAULT CIRCUIT INTERRUPTER
	SELF-CONTAINED EMERGENCY LIGHT		FIXTURE WITH EMERGENCY BATTERY BACK UP
	REMOTE HEAD ASSOCIATED W/ EMERGENCY LIGHT		NOTE TAG (No. INDICATES NOTE)
GEN	INDICATES FIXTURE OR DEVICE CONNECTED TO GENERATOR STANDBY PANEL M		FIXTURE IDENTIFICATION (LETTER INDICATES TYPE)
AC	ABOVE COUNTER – REFERENCE MOUNTING HEIGHT SCHEDULE ON THIS SHEET		TELEVISION OUTLET
CLG	CEILING MOUNTED		SECURITY SYSTEM INTRUSION DETECTOR
WP	WEATHERPROOF		FIRE SMOKE DAMPER
FACP	FIRE ALARM CONTROL PANEL		TEMPERATURE PROBE
			CARBON DIOXIDE DETECTOR



- ## 1 FIRE ALARM/SECURITY SYSTEM RISER DIAGRAM

TYPE	MANUFACTURER AND MODEL NUMBER	DESCRIPTION	LAMP		MOUNTING	
			TYPE	QUANTITY	TYPE	HEIGHT
	LITHONIA #2SP G 2 32 A12125 120 GEB10 W/ BODINE B50ST	2X4 SPECIFICATION GRADE STATIC TROFFER WITH ACRYLIC LENS. PROVIDE WITH EMERGENCY BATTERY WHERE INDICATED ON THE DRAWINGS.	F25T8	2	RECESSED	CEILING
	LITHONIA #2SP G 3 32 A12125 120 GEB10 W/ BODINE B50ST	2X4 SPECIFICATION GRADE TROFFER WITH ACRYLIC LENS WITH 1-2 LAMP BALLAST AND 1-1 LAMP BALLAST. PROVIDE WITH EMERGENCY BATTERY WHERE INDICATED ON THE DRAWINGS.	F25T8	3	RECESSED	CEILING
	LITHONIA #2SRT-G332-FW- A12125V-120-GEB10- R1F1 W/ BODINE B50ST	2X4 SPECIFICATION GRADE SEALED TROFFER WITH ACRYLIC LENS WITH 1-2 LAMP BALLAST AND 1-1 LAMP BALLAST. PROVIDE WITH EMERGENCY BATTERY WHERE INDICATED ON THE DRAWINGS.	F25T8	3	RECESSED	CEILING
	LITHONIA #AW 2 32 AR 120 GEB10 W/ BODINE B50ST	1X4 WRAPAROUND STYLE FLUORESCENT FIXTURE WITH ACRYLIC LENS. PROVIDE WITH EMERGENCY BATTERY WHERE INDICATED ON THE DRAWINGS.	F25T8	2	SURFACE	CEILING
	DAYBRITE #VIS-150-12-X-G	INCANDESCENT VAPOLET FIXTURE WITH GLASS GLOBE, GUARD & MOUNTING AS SUITABLE FOR CRAWLSPACE AND ATTIC LOCATION	100W	1	SURFACE	CRAWLSPACE AND ATTIC
	LITHONIA #TWL 35S PE LPI	HIGH PRESSURE SODIUM WALL PACK STYLE AREA LIGHT WITH INTEGRAL PHOTOCELL AND -20°F BALLAST	35W HPS	1	SURFACE	SEE ARCH. ELEVATIONS
	LITHONIA #TWP 150S PE1 LP1	HIGH PRESSURE SODIUM WALL PACK STYLE AREA FLOOD LIGHT WITH INTEGRAL PHOTOCELL AND -20°F BALLAST	150W HPS	1	SURFACE	SEE ARCH. ELEVATIONS
	LITHONIA #LQM S W 3 R 120 EL N	EMERGENCY EXIT LED RED. PROVIDE WITH MOUNTING AND QUANTITY OF DIRECTIONAL ARROWS AS SHOWN ON DRAWINGS.	LED		CENTER	ABOVE DOOR
	LITHONIA #ELA T NX H1206	PAR 36 SEALED AND GASKETED 6V EMERGENCY EXTERIOR FLOODLIGHT W/ TWIN HEAD & WET LOCATION LISTING	12W 6V	2	SURFACE	WALL 7'-6" COORD. W/ ARCH. FOR LOCATION
	LITHONIA #ELM654-RO	SELF CONTAINED EMERGENCY LIGHTING UNIT WITH MAINTENANCE FREE LEAD CALCIUM BATTERY, WITHOUT LAMP HEADS, 54W (6V) OUTPUT, FOR CONNECTION TO REMOTE HEADS		-	WALL	WALL 7'-6"
	LITHONIA #ELM654	SELF CONTAINED EMERGENCY LIGHT WITH MAINTENANCE FREE LEAD CALCIUM BATTERY, 9W ADJUSTABLE HEADS, AND 54 WATT, 6V OUTPUT FOR CONNECTION TO REMOTE HEADS.	9W 6V	2	WALL	WALL 7'-6"

NOTE:

1) CATALOG NUMBERS ARE FOR GENERAL REFERENCE AND ARE NOT INCLUSIVE OF ALL OPTIONS OR REQUIREMENTS DENOTED ON PLANS AND SPECIFICATIONS.

2) ALL LIGHT FIXTURE LOCATIONS ARE DIAGRAMMATIC IN NATURE, REFER TO ARCHITECTURAL REFLECTED CEILING PLAN FOR EXACT LOCATIONS.

PANELBOARDS (TOP)	70"
SPECIAL SYSTEM PANELS (TOP)	66"
POWER METER BASE (CENTER LINE OF SOCKET)	66"
CONTACTORS, MOTOR STARTERS, DISCONNECT SWITCHES (TOP)	66"
RECEPTACLES (UNLESS OTHERWISE NOTED)	18"
ABOVE COUNTER DEVICES (DENOTED "AC")	SEE NOTES
WALL MOUNTED SWITCHES	46"
TELECOMMUNICATION OUTLETS (UNLESS OTHERWISE NOTED)	18"
HORNS/STROBES/HORN STROBES	80" TO BOTTOM
PULL STATIONS, PUSH BUTTONS	46"

COORDINATE AND INSTALL ALL EQUIPMENT AND DEVICES
RELATED TO DENTAL, PER DENTAL PLANS.



DIVISION OF ENVIRONMENTAL
HEALTH AND ENGINEERING
1901 SOUTH BRAGAW STREET, SUITE 200
ANCHORAGE, ALASKA, 99508-3440
(907) 729-3600




DATE: 04/20/09	FILE NAME: 08167-E11
SCALE: AS NOTED	LAYOUT NAME: LAYOUT1
DRAWN BY: BAB	PROJ ENG: BRETT BINGHAM,

SHEET
E1.1


1 OF 9E



1 ELECTRICAL SITE PLAN
E1.2 SCALE: 0 10' 15'
1" = 5'

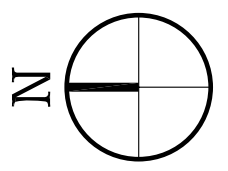

- SHEET NOTES**
- 1 THE CONTRACTOR SHALL COORDINATE WITH THE LOCAL TELEPHONE COMPANY (RICK WILLIAMS AT UNITED UTILITIES INCORPORATED, 1 800 478-2020) AND SHALL INSTALL TWO 2" CONDUITS WITH PULL STRING (ONE IS TO BE A SPARE) FROM MAIN TELEPHONE BACKBOARD TO THE TELEPHONE UTILITY POLE. EXACT POLE LOCATION COULD NOT BE CONFIRMED. FOR BIDDING PURPOSES CONTRACTOR SHALL ASSUME POLE LOCATION IS AS SHOWN. COORDINATE EXACT LOCATION, ROUTING AND REQUIREMENTS WITH UTILITY COMPANY.
 - 2 PROPOSED LOCATION FOR ELECTRICAL SERVICE ENTRANCE EQUIPMENT. CONTRACTOR TO COORDINATE LOCATION AND TYPE OF UTILITY SERVICE CONNECTION WITH SERVING UTILITY, McGRATH LIGHTING AND POWER (LOUIS EGRASS 907 524-3391 OR ERNIE BAUMGARTNER 907 524-3360).
 - 3 HEADBOLT HEATER PEDESTAL. SEE DETAIL 2/E1.2.

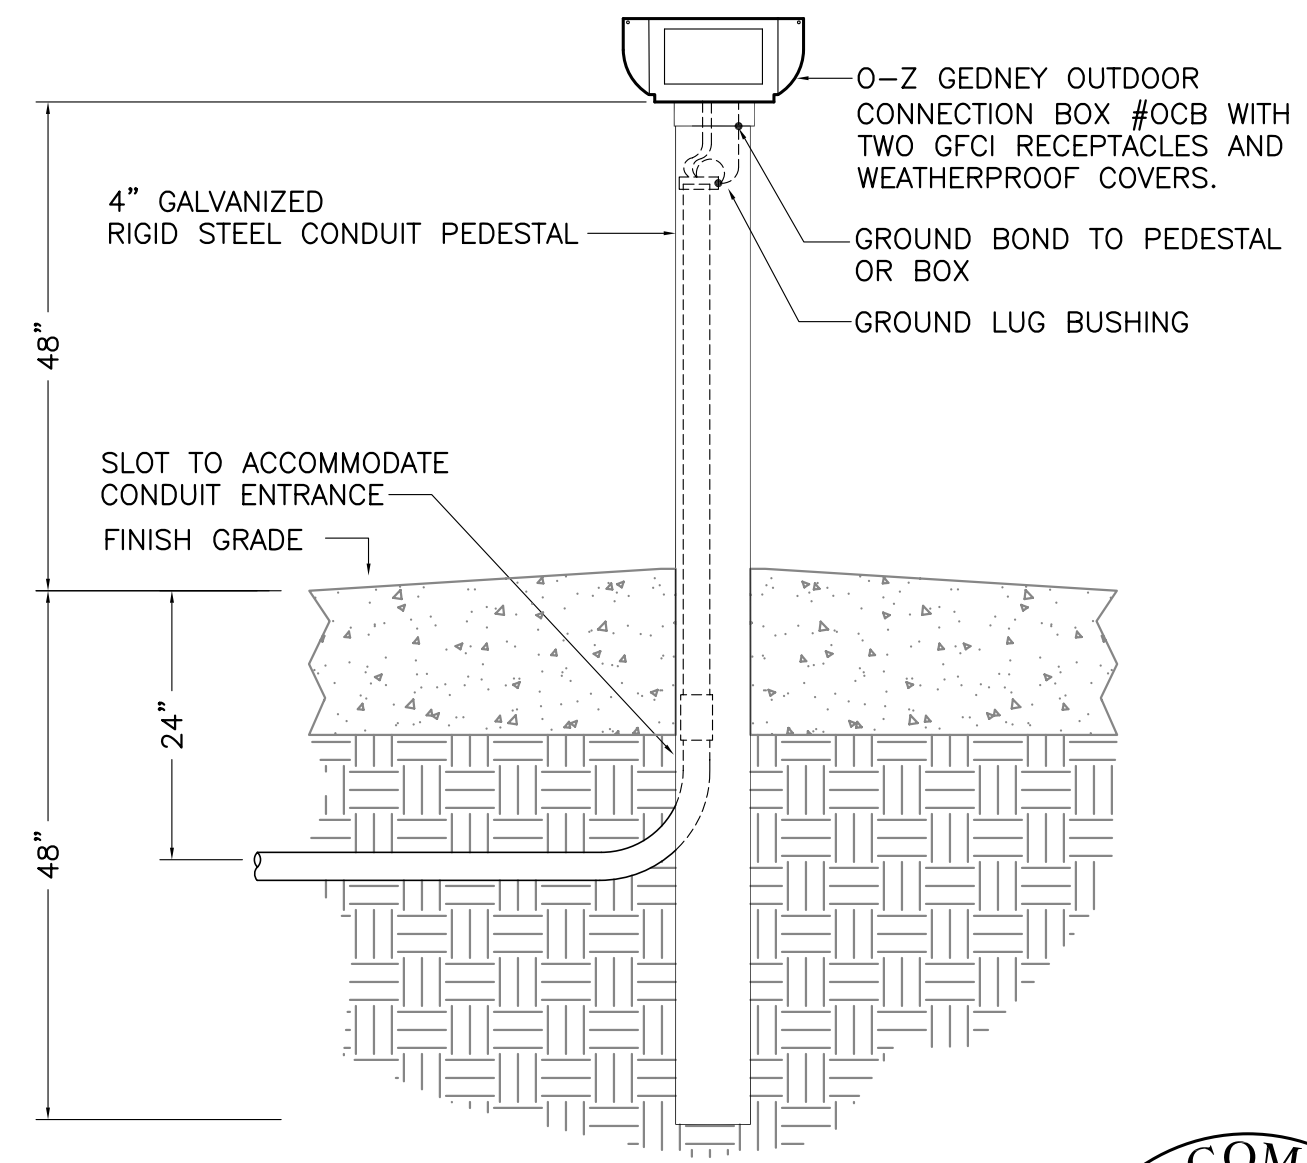

2 TYPICAL HEADBOLT HEATER
E1.2 OUTLET DETAIL
SCALE: 1/8" = 1'-0"




DATE	REVISIONS	INIT.




ALASKA NATIVE
TRIBAL HEALTH CONSORTIUM

DIVISION OF ENVIRONMENTAL
HEALTH AND ENGINEERING
1901 SOUTH BRAGAW STREET, SUITE 200
ANCHORAGE, ALASKA 99508-3440
(907) 729-3600

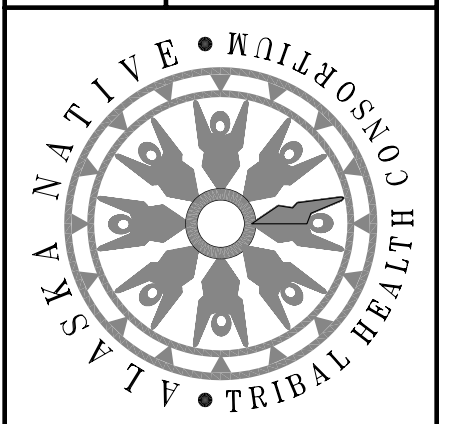

McGRATH SUB-REGIONAL HEALTH CENTER SITE PLAN	FILE NAME: 08167-E12
	LAYOUT NAME: LAYOUT1
	PROJ ENG: BRETT BINGHAM, P.E.
	DRAWN BY: BAB
DATE: 04/20/09	SCALE: AS NOTED

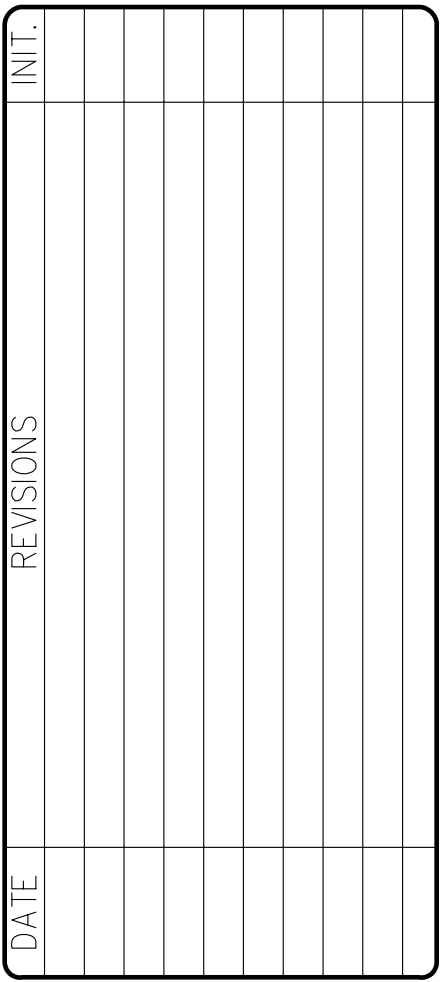

ALASKA NATIVE
TRIBAL HEALTH CONSORTIUM

DIVISION OF ENVIRONMENTAL
HEALTH AND ENGINEERING
1901 SOUTH BRAGAW STREET, SUITE 200
ANCHORAGE, ALASKA, 99508-3440
(907) 729-3600



McGRATH SUB--REGIONAL HEALTH CENTER CRAWLSpace LIGHTING AND POWER PLAN		FILE NAME: 08167-E22
		LAYOUT NAME: LAYOUT1
		PROJ ENG: BRETT BINGHAM, P.E.
DATE: 04/20/09		
SCALE: AS NOTED		
DRAWN BY: EDA		

SHEET
E2.2


4 OF 9E



E2.2 SCALE: 0 2' 4' 6'

1' 3' 5'

- ① RECEPTACLES ARE TO BE UNSWITCHED.
- ② CONNECT TO PILOT LIGHT SWITCH IN ROOM ABOVE FOR CONTROL OF LIGHTING.

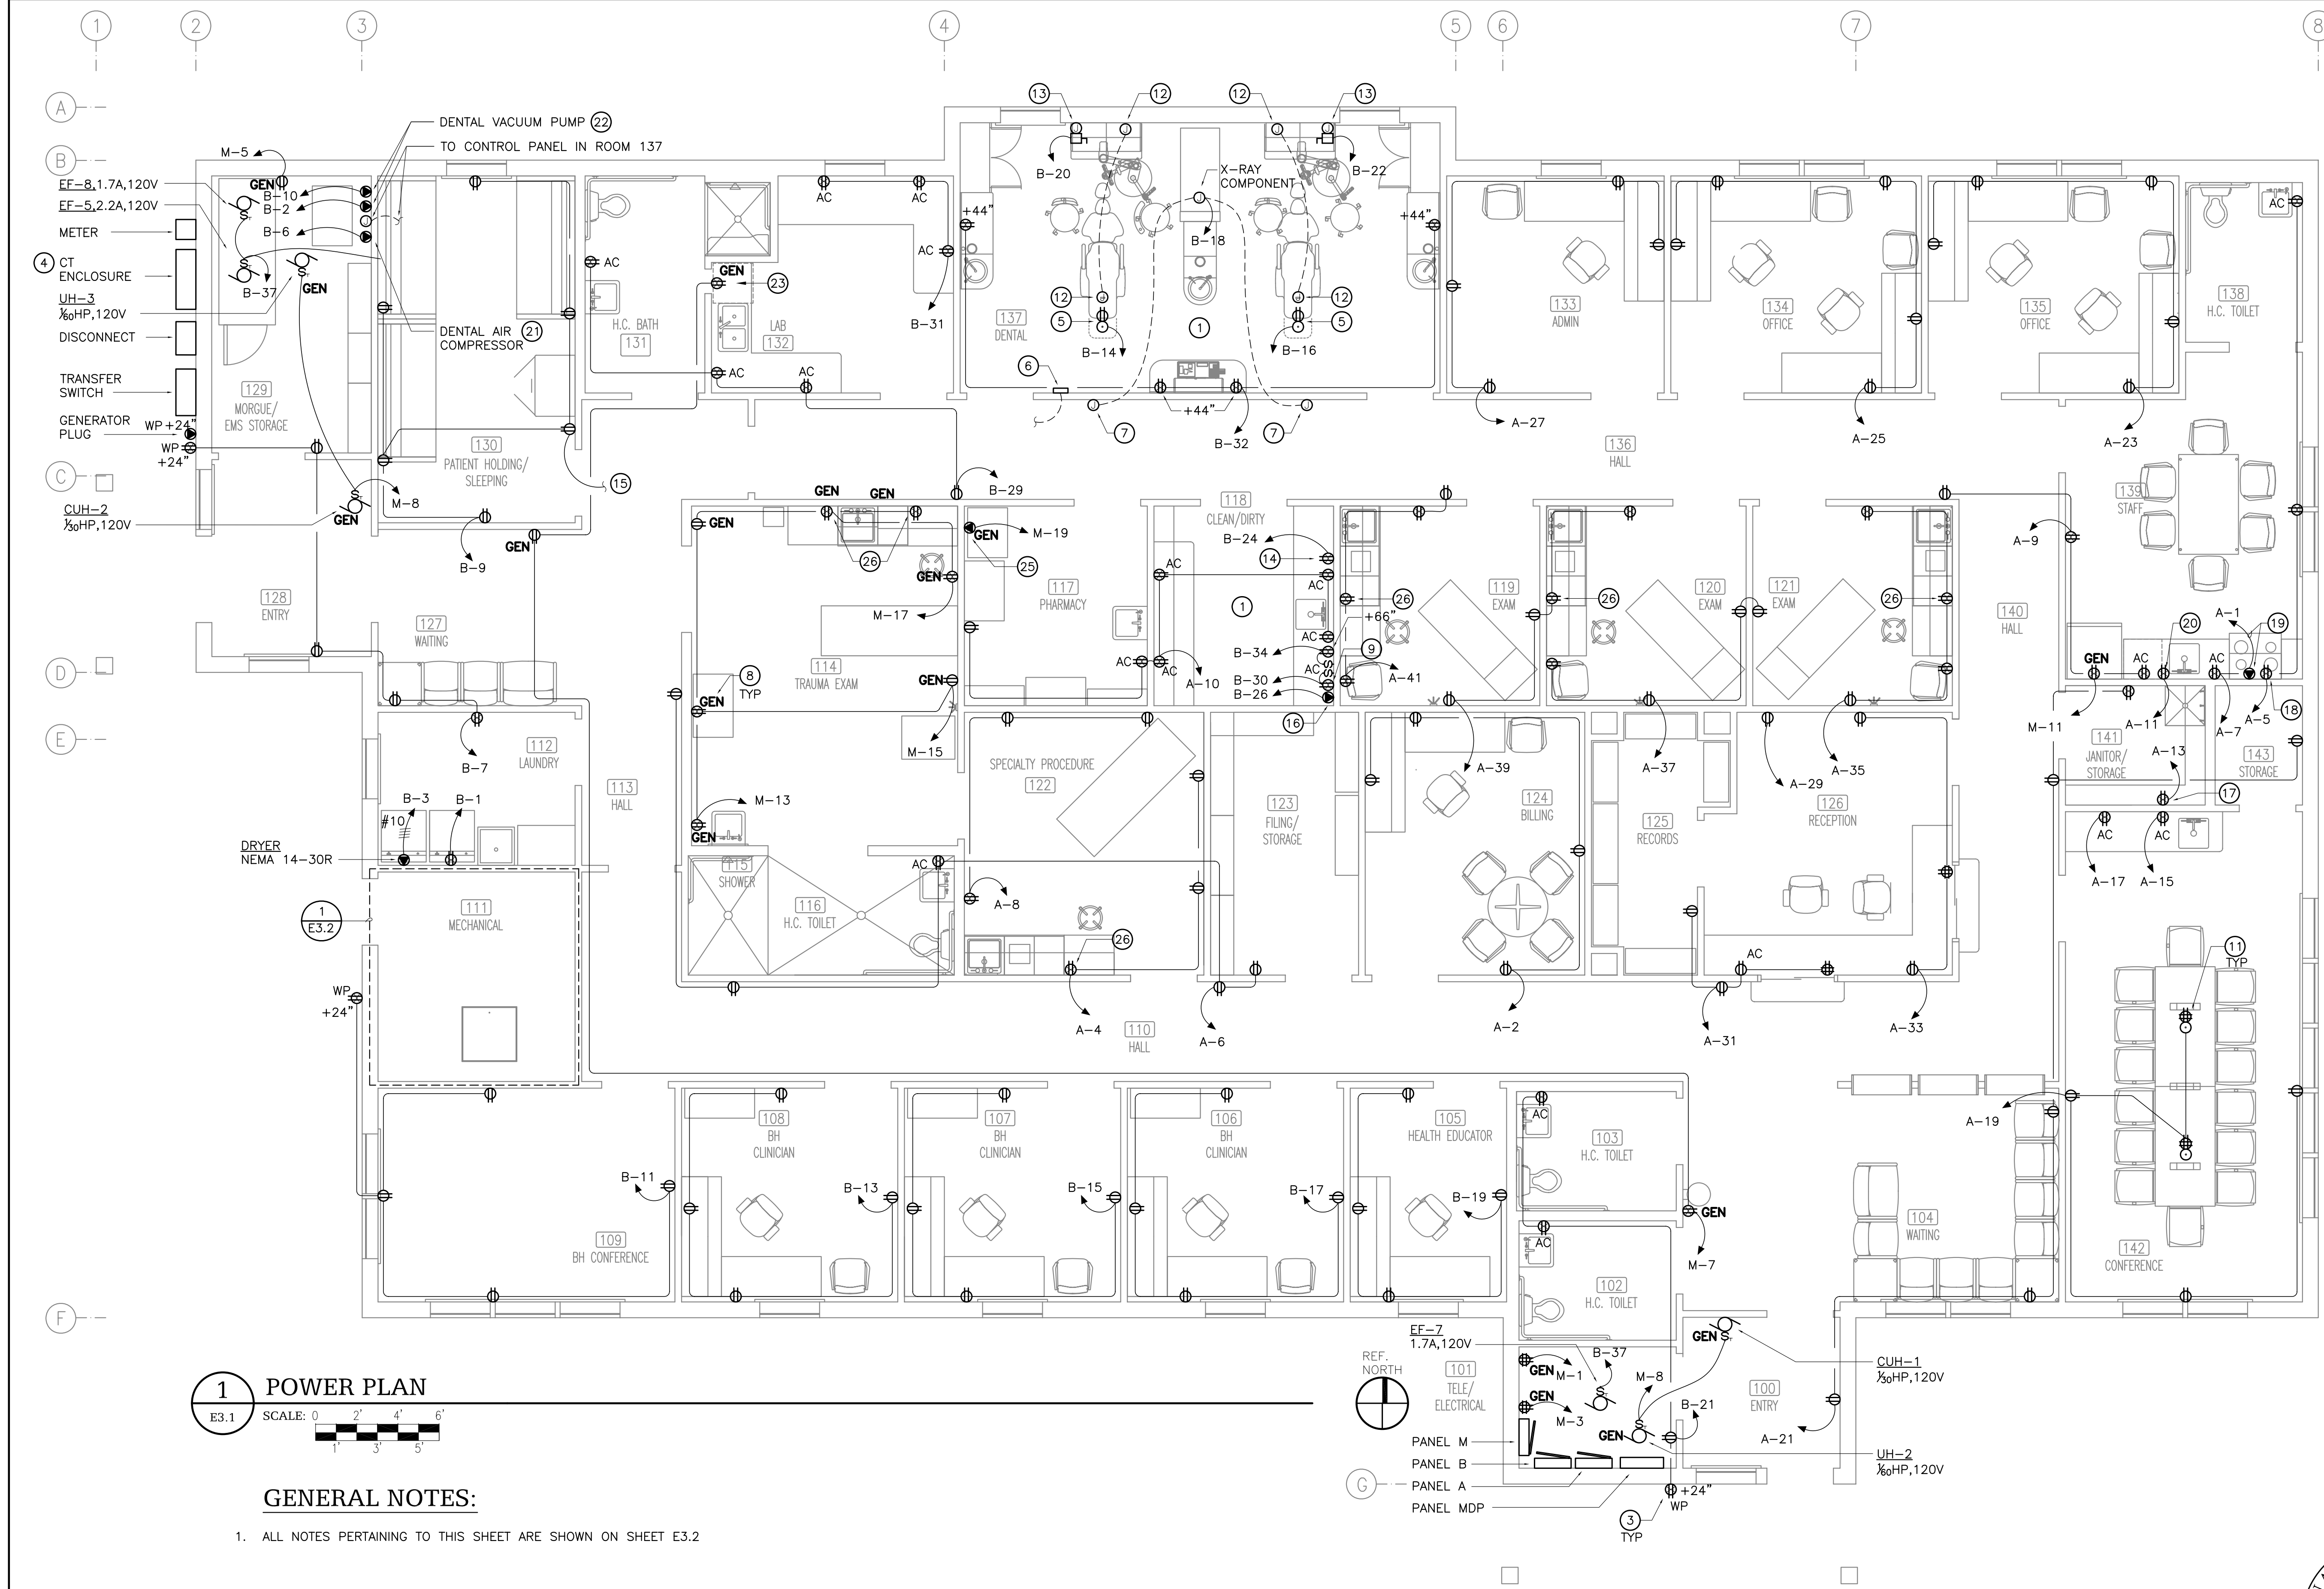

INT.	REV.	DATE



ALASKA NATIVE
TRIBAL HEALTH CONSORTIUM
DIVISION OF ENVIRONMENTAL
HEALTH AND ENGINEERING
1901 SOUTH BRAGAW STREET, SUITE 200
ANCHORAGE, ALASKA 99508-3440
(907) 729-3600



McGrath Sub-Regional
Health Center
POWER PLAN

FILE NAME: 08167-E31
LAYOUT NAME: LAYOUT1
PROJ ENG: BRETT BINGHAM, P.E.
DATE: 04/20/09
SCALE: AS NOTED
DRAWN BY: EDA



The logo of the Denali Commission Alaska is a circular emblem. It features a stylized landscape with a snow-capped mountain peak (Denali) in the background, a body of water in the foreground, and a small evergreen tree on the left. The words "DENALI COMMISSION" are written in a circle around the top, and "ALASKA" is written at the bottom.

SHEET
E3.2
6 OF 9E

PANEL A				SCHEDULE										225A MLO		
120/208V, 3PH, 4W																
CKT	AMP	POLE	LOAD DESCRIPTION	PHASE A VA		PHASE B VA		PHASE C VA		LOAD DESCRIPTION	POLE	AMP	CKT			
1	50	2	REC-RANGE STAFF 139	4,000	720					REC-BILLING 124	1	20	2			
3	20					4,000	540			REC-SPEC. PROC 122	1	20	4			
5	20	1	REC-MICROWAVE STAFF 139					1,800	900	REC-FILE 123,HALL 110,113,TLT	1	20	6			
7	20	1	REC-139 CNTR (E) & E WALL, 13	540	540					REC-SPEC. PROC 122	1	20	8			
9	20	1	REC-139 CNTR (W) & W WALL, 13			540	1,080			REC-CLN/DRTY 118, PHRMCY 11	1	20	10			
11	20	1	REC-STAFF 139 DISHWASHER					1,200	1,355	LTG-CONF JAN STAFF	1	20	12			
13	20	1	REC-HRV (JAN 141)	610	1,215					LTG-ADMIN. OFF 134,135, TLT	1	20	14			
15	20	1	REC-CONF 142 COUNTER			180	1,715			LTG-RCP'N,BILL,RCRDS,FLNG	1	20	16			
17	20	1	REC-CONF 142 COUNTER							REC-HEADBOLT HEATER	1	20	18			
19	20	1	REC-CONF 142 WALLS, FLOOR	1,280	1,120			180	1,455	DENTAL EXAM LT, XRAY VIEWE	1	20	20			
21	20	1	REC-STOR,JAN,HALL,WTG,ENTR			1,080	940			LTG-EXTERIOR BUILDING	1	20	22			
23	20	1	REC-OFFICE 135					900	1,255	LTG-DENTAL, LAB, HC BATH	1	20	24			
25	20	1	REC-OFFICE 134	900	1,500					REC-HEADBOLT HEATER	2	20	26			
27	20	1	REC-OFFICE 133			720	1,500			REC-HEADBOLT HEATER	2	20	28			
29	20	1	REC-RECEPTION COPIER					1,200	1,500	REC-HEADBOLT HEATER	2	20	30			
31	20	1	REC-RECEPTION 126	900	1,500					REC-HEADBOLT HEATER	2	20	32			
33	20	1	REC-RECEPTION 126			720	1,500			REC-HEADBOLT HEATER	2	20	34			
35	20	1	REC-EXAM 120, 121					720	1,500	REC-HEADBOLT HEATER	2	20	36			
37	20	1	REC-EXAM 120	720						SPARE	1	20	38			
39	20	1	REC-EXAM 119, 120			720				SPARE	1	20	40			
41	20	1	REC-EXAM 119					720		SPARE	1	20	42			
CONNECTED LOAD (VA)				15,525		15,235		14,685		45,445 VA						
CONNECTED LOAD (AMPERES)				129		127		122		126 A						
DEMAND LOAD (VA)				16,109		15,899		15,701		47,709 VA						
DEMAND LOAD (AMPERES)				134		132		131		133 A						
AMPERE INTERRUPT RATING																
AS INDICATED BY THE FAULT CURRENT ANALYSIS																

PANEL B				SCHEDULE										225A MLO			
120/208V, 3PH, 4W																	
CKT	AMP	POLE	LOAD DESCRIPTION	PHASE A VA	PHASE B VA	PHASE C VA	LOAD DESCRIPTION	POLE	AMP	CKT							
1	20	1	WASHER	1,500	1,560		DENTAL VACUUM	2	20	2							
3	30	1	DRYER		2,500	1,560			2	4							
5	20	2								6							
7	20	1	REC-LNDRY, WTG, ENTRY, MRG	900	960		2,500	960	DENTAL COMPRESSOR	2	20	8					
9	20	1	REC-PATIENT HLDG, CO, DTCTR		1,260	1,560				10							
11	20	1	REC-BH CONF 109			900	1,560	DENTAL VACUUM	2	10	12						
13	20	1	REC-CLINICIAN 108	720	960				1	20	14						
15	20	1	REC-CLINICIAN 107		720	960				16							
17	20	1	REC-CLINICIAN 106			720	960	REC-DENTAL CHAIR	1	20	18						
19	20	1	REC-HEALTH EDUCATOR 105	720	960		720	960	REC-DENTAL CHAIR	1	20	16					
21	20	1	REC-TLTS, ELEC, EXTERIOR						DENTAL XRAY	1	20	18					
23	20	1	LTG-CRAWLSPACE						DENTAL UTILITY	1	20	20					
25	2	2	REC-CRAWLSPACE	1,440	1,105				DENTAL UTILITY	1	20	22					
27	20	1	LTG-PATIENT HOLDING		430	1,105	1,200	720	REC-ULTRASONIC CLNR (118)	1	20	24					
29	20	1	REC-LAB CNTR, HC BATH, HALL						REC-STERILIZER	2	20	26					
31	20	1	REC-LAB COUNTER	540	720					2	20	28					
33	20	1	LTG-BH CLINIC, TLT, HLTH ED		1,080	180	720	1,440	REC-STERILIZER	1	20	30					
35	20	1	LTG-BH CLINIC, CONF, MECH, LNDRY						REC-DENTAL CABINETS	1	20	32					
37	20	1	EF-5, 8, 7	675	1,500				REC-CLEAN/DIRTY (DISTILLER)	1	20	34					
39	20	1	EF-9		375		1,140	1,500	REC-HEADBOLT HEATER	2	20	36					
41	20	1	SPARE						REC-HEADBOLT HEATER	2	20	38					
									SPARE	1	20	40					
									SPARE	1	20	42					
CONNECTED LOAD (VA)				14,260	13,410	14,320	41,990 VA										
CONNECTED LOAD (AMPERES)				119	112	119	117 A										
DEMAND LOAD (VA)				14,650	14,178	15,145	43,973 VA										
DEMAND LOAD (AMPERES)				122	118	126	122 A										
AMPERE INTERRUPT RATING																	
AS INDICATED BY THE FAULT CURRENT ANALYSIS																	


A - ARC-FAULT TYPE CIRCUIT BREAKER.

PANEL M				SCHEDULE						225A MLO			
120/208V, 3PH, 4W													
CKT	AMP	POLE	LOAD DESCRIPTION	PHASE A VA	PHASE B VA	PHASE C VA	LOAD DESCRIPTION	POLE	AMP	CKT			
1	20	1	REC-DATA ROOM	360	660		LTG-MORG,ENTRY,WTG,HALL	1	20	2			
3	20	1	REC-DATA ROOM		360	1,650	LTG-ELEC,ENTRY,WTG,HALLS	1	20	4			
5	20	1	REC-MORGUE129 FRIDGE			1,440	778	LTG-TRAUMA	1	20	6		
7	15	1	REC-WTG 104, WTG 127, 132 FR	840	1,200			CUH-1 & 2, UH-1 & 2 & 3, HWG-1	1	20	8		
9	20	1	FIRE ALARM CONTROL PANEL		500	500		MECH RM CONTROL PANEL	1	20	10		
11	20	1	REC-STAFF 139 FRIDGE			1,000	500	B-1, BC-1	1	20	12		
13	20	1	REC-TRAUMA EXAM 114	540	900			REC-MECH RM, GT-1	1	20	14		
15	20	1	REC-TRAUMA EXAM 114		360	500		B-2, BC-2	1	20	16		
17	20	1	REC-TRAUMA EXAM 114			360	890	CP-1, CP-2	2	20	18		
19	15	2	PHARMACY FRIDGE	470	890				3	20	20		
21	2	2			470	890				22			
23	20	1	SPARE			500	CP-3, CP-4	1	20	24			
25	20	1	SPARE				SPARE	1	20	26			
27	20	1	SPARE				SPARE	1	20	28			
29	20	1	SPARE				SPARE	1	20	30			
31	20	1	SPARE				SPARE	1	20	32			
33	20	1	SPARE				SPARE	1	20	34			
35	20	1	SPARE				SPARE	1	20	36			
37	-	1	SPACE				SPACE	1	-	38			
39	-	1	SPACE				SPACE	1	-	40			
41	-	1	SPACE				SPACE	1	-	42			
CONNECTED LOAD (VA)				5,860	5,230	5,468	16,558 VA						
CONNECTED LOAD (AMPERES)				49	44	46	46 A						
DEMAND LOAD (VA)				6,136	5,754	5,774	17,664 VA						
DEMAND LOAD (AMPERES)				51	48	48	49 A						
AMPERE INTERRUPT RATING						AS INDICATED BY THE FAULT CURRENT ANALYSIS							

L - PROVIDE WITH LOCK-ON TYPE DEVICE.

MDP																	120/208V, 3PH, 4W						400A					
CKT	* AMP	POLE	LOAD DESCRIPTION	PHASE A VA		PHASE B VA		PHASE C VA		LOAD DESCRIPTION	POLE	* AMP	CKT															
1			PANEL A	16,109	6,136					PANEL M			2															
		3				15,899	5,754																					
	*							15,701	5,774		3																	
3			PANEL B	14,650						SPACE			4															
		3				14,178																						
								15,145			3																	
5			SPACE							SPACE			6															
		3									3																	
										SPACE																		
7			SPACE							SPACE			8															
		3									3																	
										SPACE																		
9			SPACE							SPACE			10															
		3									3																	
CONNECTED LOAD (VA)				36,895		35,830		36,620		109,345 VA																		
CONNECTED LOAD (AMPERES)				307		299		305		304 A																		
DEMAND LOAD (VA)				36,895		35,830		36,620		109,345 VA																		
DEMAND LOAD (AMPERES)				307		299		305		304 A																		
AMPERE INTERRUPT RATING																												

A
B
C
D
E
F

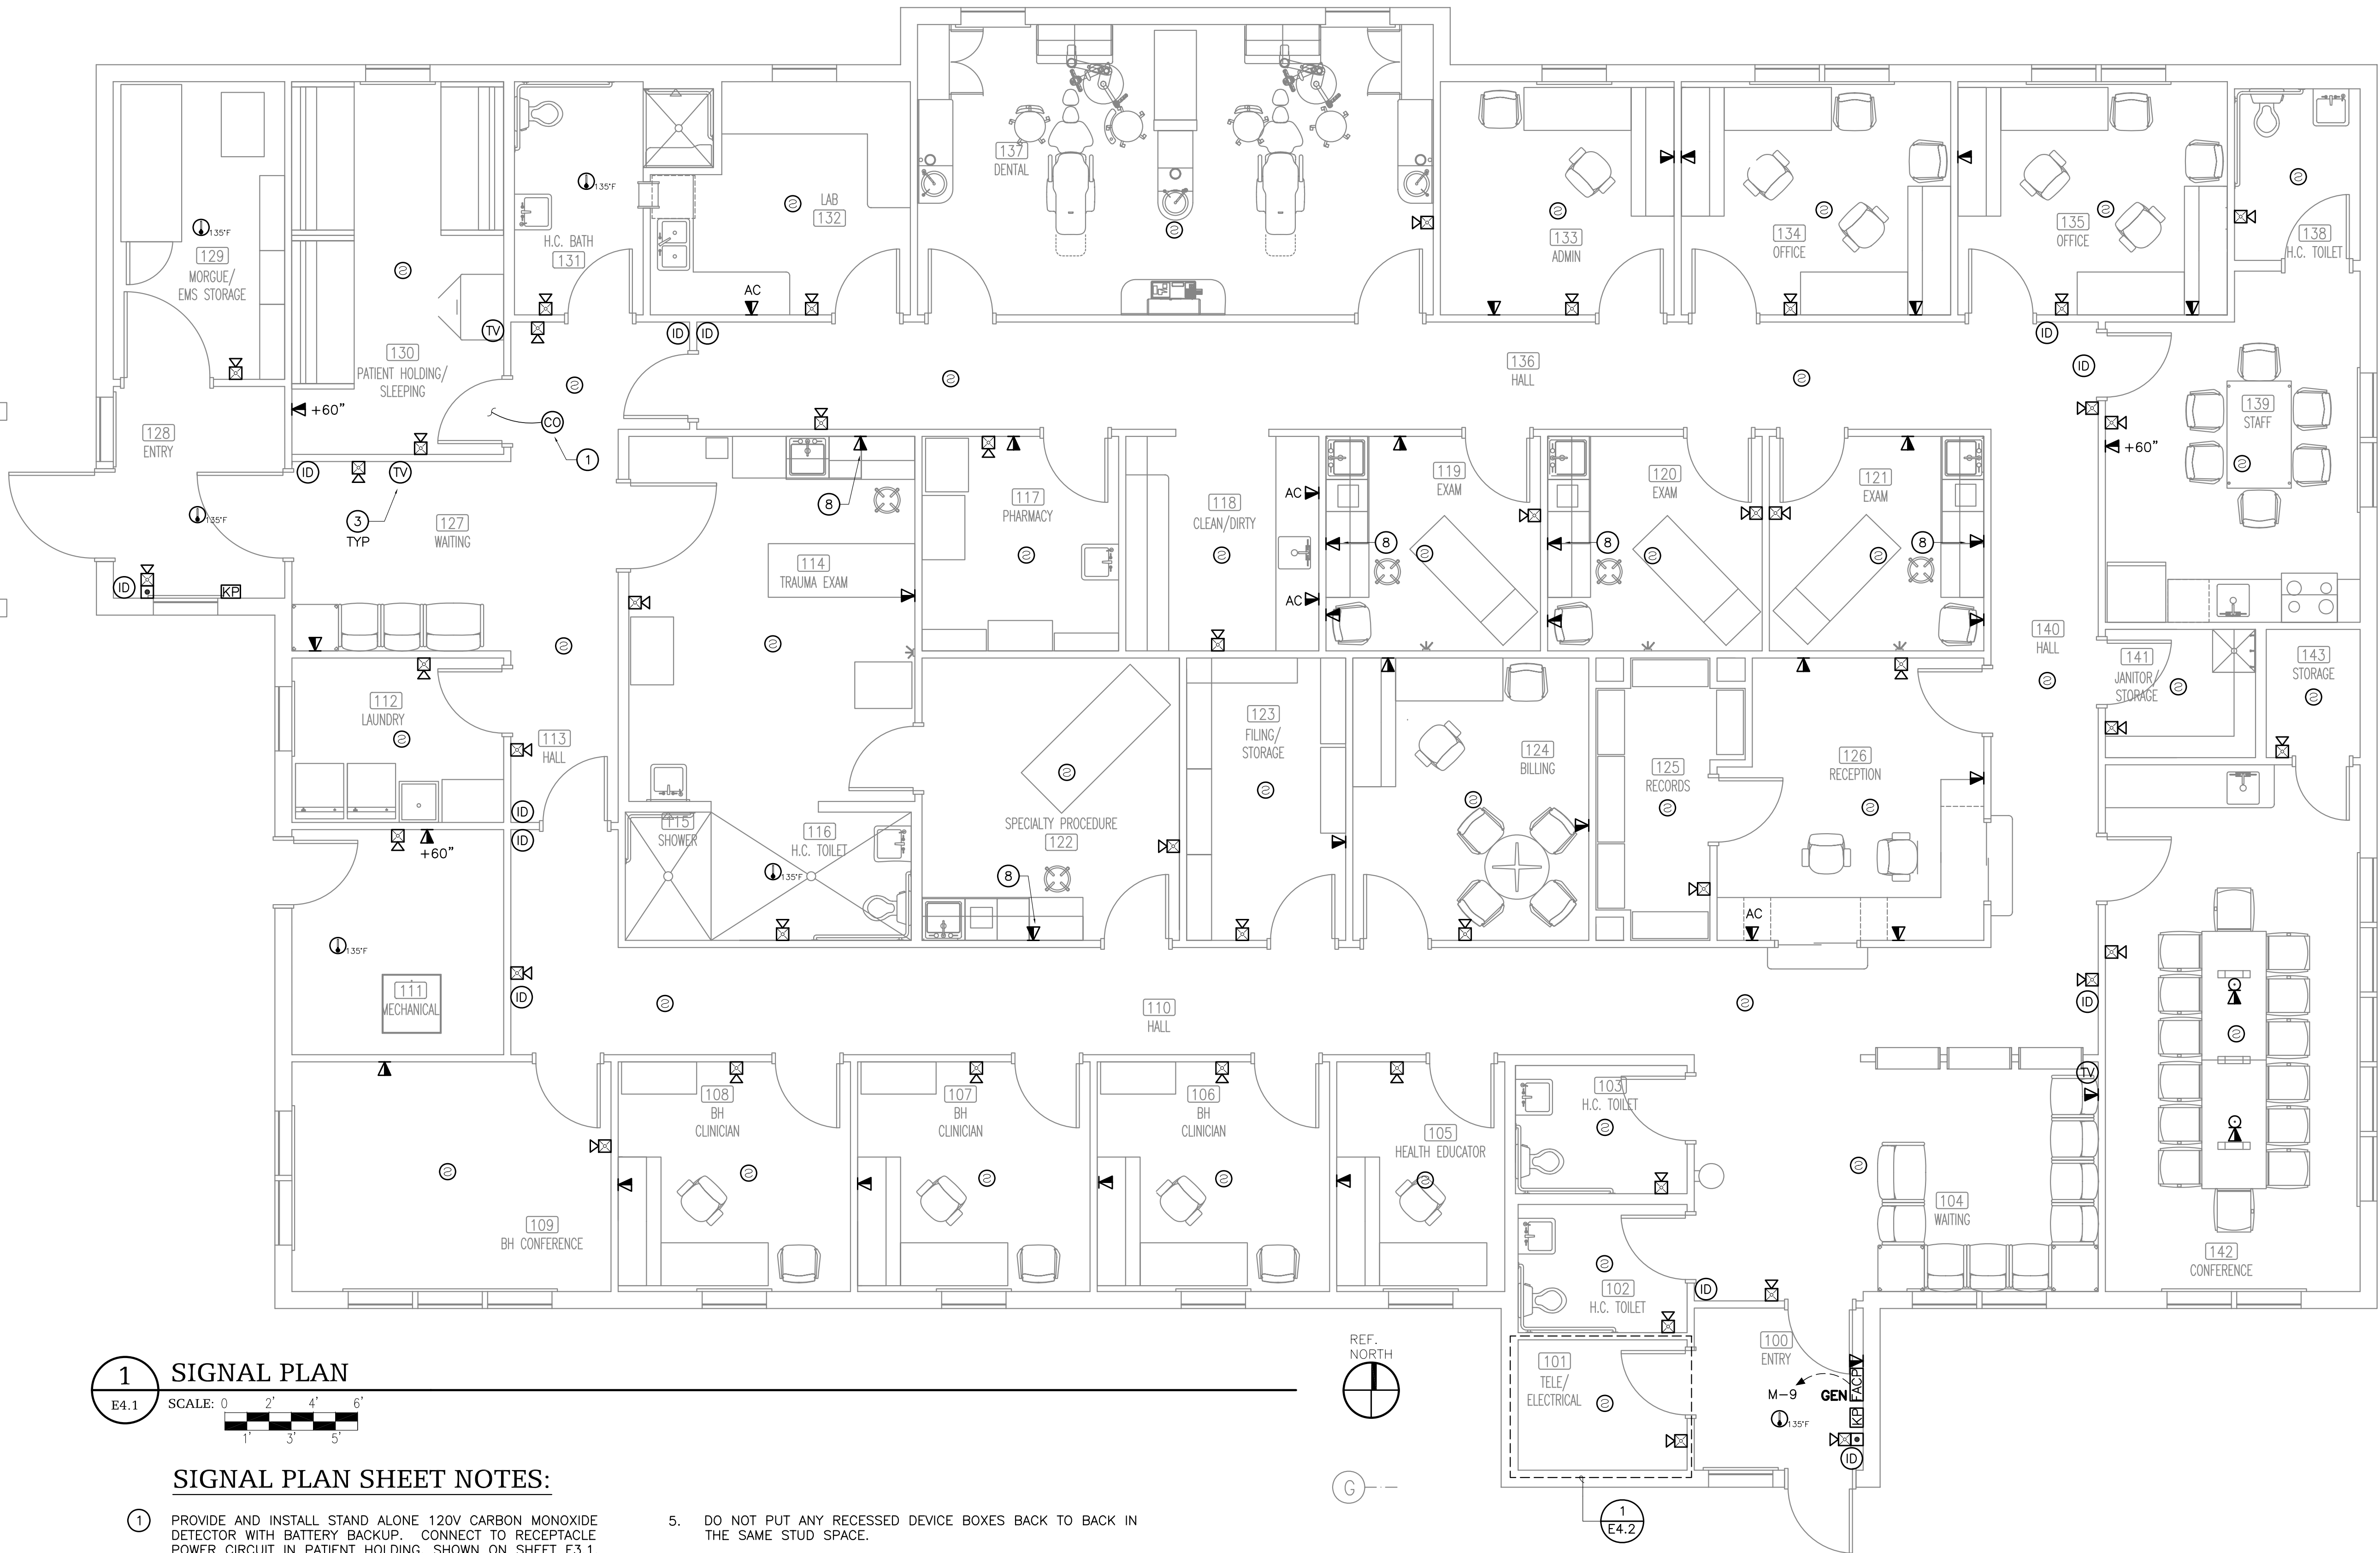

1 SIGNAL PLAN

E4.1 SCALE: 0 2' 4' 6' 1' 3' 5'

SIGNAL PLAN SHEET NOTES:

- 1 PROVIDE AND INSTALL STAND ALONE 120V CARBON MONOXIDE DETECTOR WITH BATTERY BACKUP. CONNECT TO RECEPTACLE POWER CIRCUIT IN PATIENT HOLDING, SHOWN ON SHEET E3.1.
- 2 ALL TELECOM OUTLETS SHALL HAVE A MINIMUM OF 2 CAT5 HOMERUNS UNLESS OTHERWISE NOTED. SEE 5/E-4.2.
- 3 PRE-WIRE TV OUTLETS WITH RG59 CABLE TO TELECOM. DEMARC. BOARD, TYP. COORDINATE HEIGHT WITH ARCHITECTURAL DRAWINGS.
- 4 STUB UP MIN. OF 3/4" INTO ACCESSIBLE ATTIC SPACE FOR EACH TELECOM OUTLET.
- 5 DO NOT PUT ANY RECESSED DEVICE BOXES BACK TO BACK IN THE SAME STUD SPACE.
- 6 ALL REQUIRED FIRE ALARM DEVICES MAY NOT BE SHOWN ON THESE DRAWINGS. THE CONTRACTOR IS RESPONSIBLE FOR COMPLETE DESIGN OF FIRE ALARM AND DETECTION SYSTEMS. PROVIDE ALL NECESSARY DEVICES, WIRING, ETC. AS REQUIRED FOR COMPLIANCE WITH GOVERNING CODES INCLUDING DETECTORS THAT MAY BE REQUIRED IN CRAWLSPACES, ATTICS, ABOVE CEILINGS SPACES, CONNECTIONS TO SPRINKLER SYSTEMS, FIRE PUMPS, ETC.
- 7 THE EXTERIOR WALL SHALL NOT BE PENETRATED AND ALL CEILING PENETRATIONS SHALL HAVE SOLID BLOCK AND WEATHER TIGHT BOXES.




McGrath SUB-REGIONAL
HEALTH CENTER
SIGNAL PLAN

FILE NAME: 08167-E41
LAYOUT NAME: LAYOUT1
DATE: 04/20/09
SCALE: AS NOTED
DRAWN BY: EDA
PROJ ENG: BRETT BINGHAM, P.E.


ALASKA NATIVE
TRIBAL HEALTH CONSORTIUM
DIVISION OF ENVIRONMENTAL
HEALTH AND ENGINEERING
1901 SOUTH BRAGAW STREET, SUITE 200
ANCHORAGE, ALASKA 99508-3440
(907) 729-3600



DATE	REVISIONS	INIT.

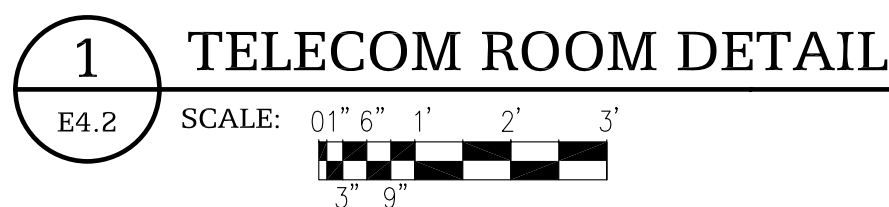

① ALL GROUND CONNECTIONS SHALL BE IRREVERSABLE CRIMP TYPE.

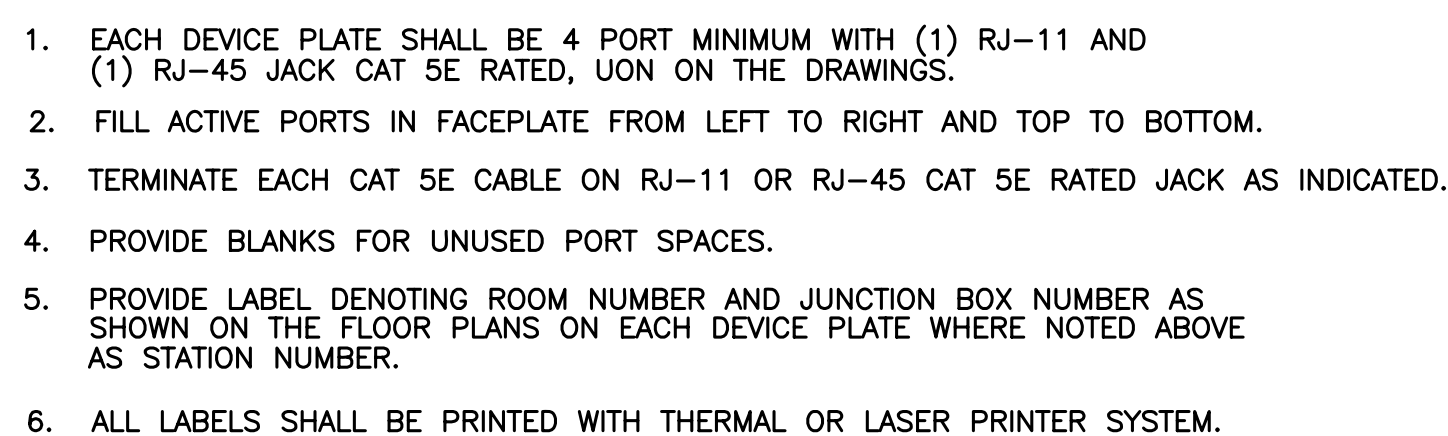[illegible]

ALASKA NATIVE
TRIBAL HEALTH CONSORTIUM

DIVISION OF ENVIRONMENTAL
HEALTH AND ENGINEERING
1901 SOUTH BRAGAW STREET, SUITE 200
ANCHORAGE, ALASKA, 99508-3440
(907) 729-3600



**McGRATH SUB-REGIONAL
HEALTH CENTER**
SIGNAL DETAILS

DATE:	04/20/09	FILE NAME:	08167-E42
SCALE:	AS NOTED	LAYOUT NAME:	LAYOUT1
DRAWN BY:	BAB	PROJ ENG:	BRETT BINGHAM,

SHEET
E4.2

9 OF 9E