

BIM 360://21003.03 SCF Fireweed Dental Renovation/Southern Foundation Fireweed Dental Renovation.rvt
Plot Date Time: 5/10/2023 1:30:29 PM

SHEET FLAG NOTES


- NEW RE-LITE / PASS-THRU WINDOW
- NEW 3-FORM RAILING PANELS
- NEW DECORATIVE WOOD PANEL WALL
- ADD ONE LAYER GWB TO INTERIOR SIDE OF WALLS IN CBCT 122 AND CBCT 141
- LARGE TOUCHSCREEN MONITOR, OFCI
- WALL MOUNTED MONITOR, SEE ELECTRICAL
- BOTTLE FILLER, SEE MECHANICAL
- SHAFT ENCLOSURE ON EVERY FLOOR REQUIRES PARTIAL DEMO DUE TO MECHANICAL WORK. REPLACE WITH SAME WALL TYPE AS REQUIRED, PATCH, REPAIR & PAINT. SEE MECHANICAL DRAWINGS.
- SOUND-DAMPENING FABRIC WRAPPED ACOUSTICAL PANELS (FWP-1)

GENERAL NOTES FLOOR PLAN

- NEW FLOORING & BASE THROUGHOUT U.O.N. SEE A-601
- NEW WALLS THROUGHOUT, SEE SHEET A-603 FOR PARTITION TYPES
- NEW DOORS, FRAMES & ASSOCIATED HARDWARE THROUGHOUT, SEE DOOR SCHEDULE A-602
- NEW PLUMBING FIXTURES THROUGHOUT, SEE MECHANICAL DRAWINGS
- NEW CASEWORK THROUGHOUT, SEE ELEVATION SHEETS (SERIES 4) & "EQ" SERIES SHEETS FOR ELEVATIONS
- NEW EQUIPMENT THROUGHOUT, SEE "EQ" SERIES SHEETS FOR EQUIPMENT INFORMATION
- SEE SHEETS A104, A105, A601 & A602 FOR DOOR, ROOM FINISH AND COLOR SCHEDULES.
- SEE SIMILAR DETAILS AND APPLY AT SIMILAR LOCATIONS, TYPICAL
- REFER TO SPECIFICATIONS FOR INFORMATION NOT PROVIDED IN CONSTRUCTION DRAWINGS.
- PATCH, MATCH AND REPAIR EXISTING FINISHES AND CONSTRUCTION AS REQUIRED FOR INSTALLATION OF NEW WORK, TYPICAL
- ALL DIMENSIONS FACE OF FINISH U.O.N.
- NEW FURNITURE OFCI
- NEW WINDOW COVERINGS THROUGHOUT LEVEL ONE, SEE SPECIFICATION

LEGEND

- EXISTING PARTITION AND DOOR
- NEW METAL STUD PARTITION AND DOOR
- NOT IN SCOPE
- WALL PARTITION TYPE, SEE A-604

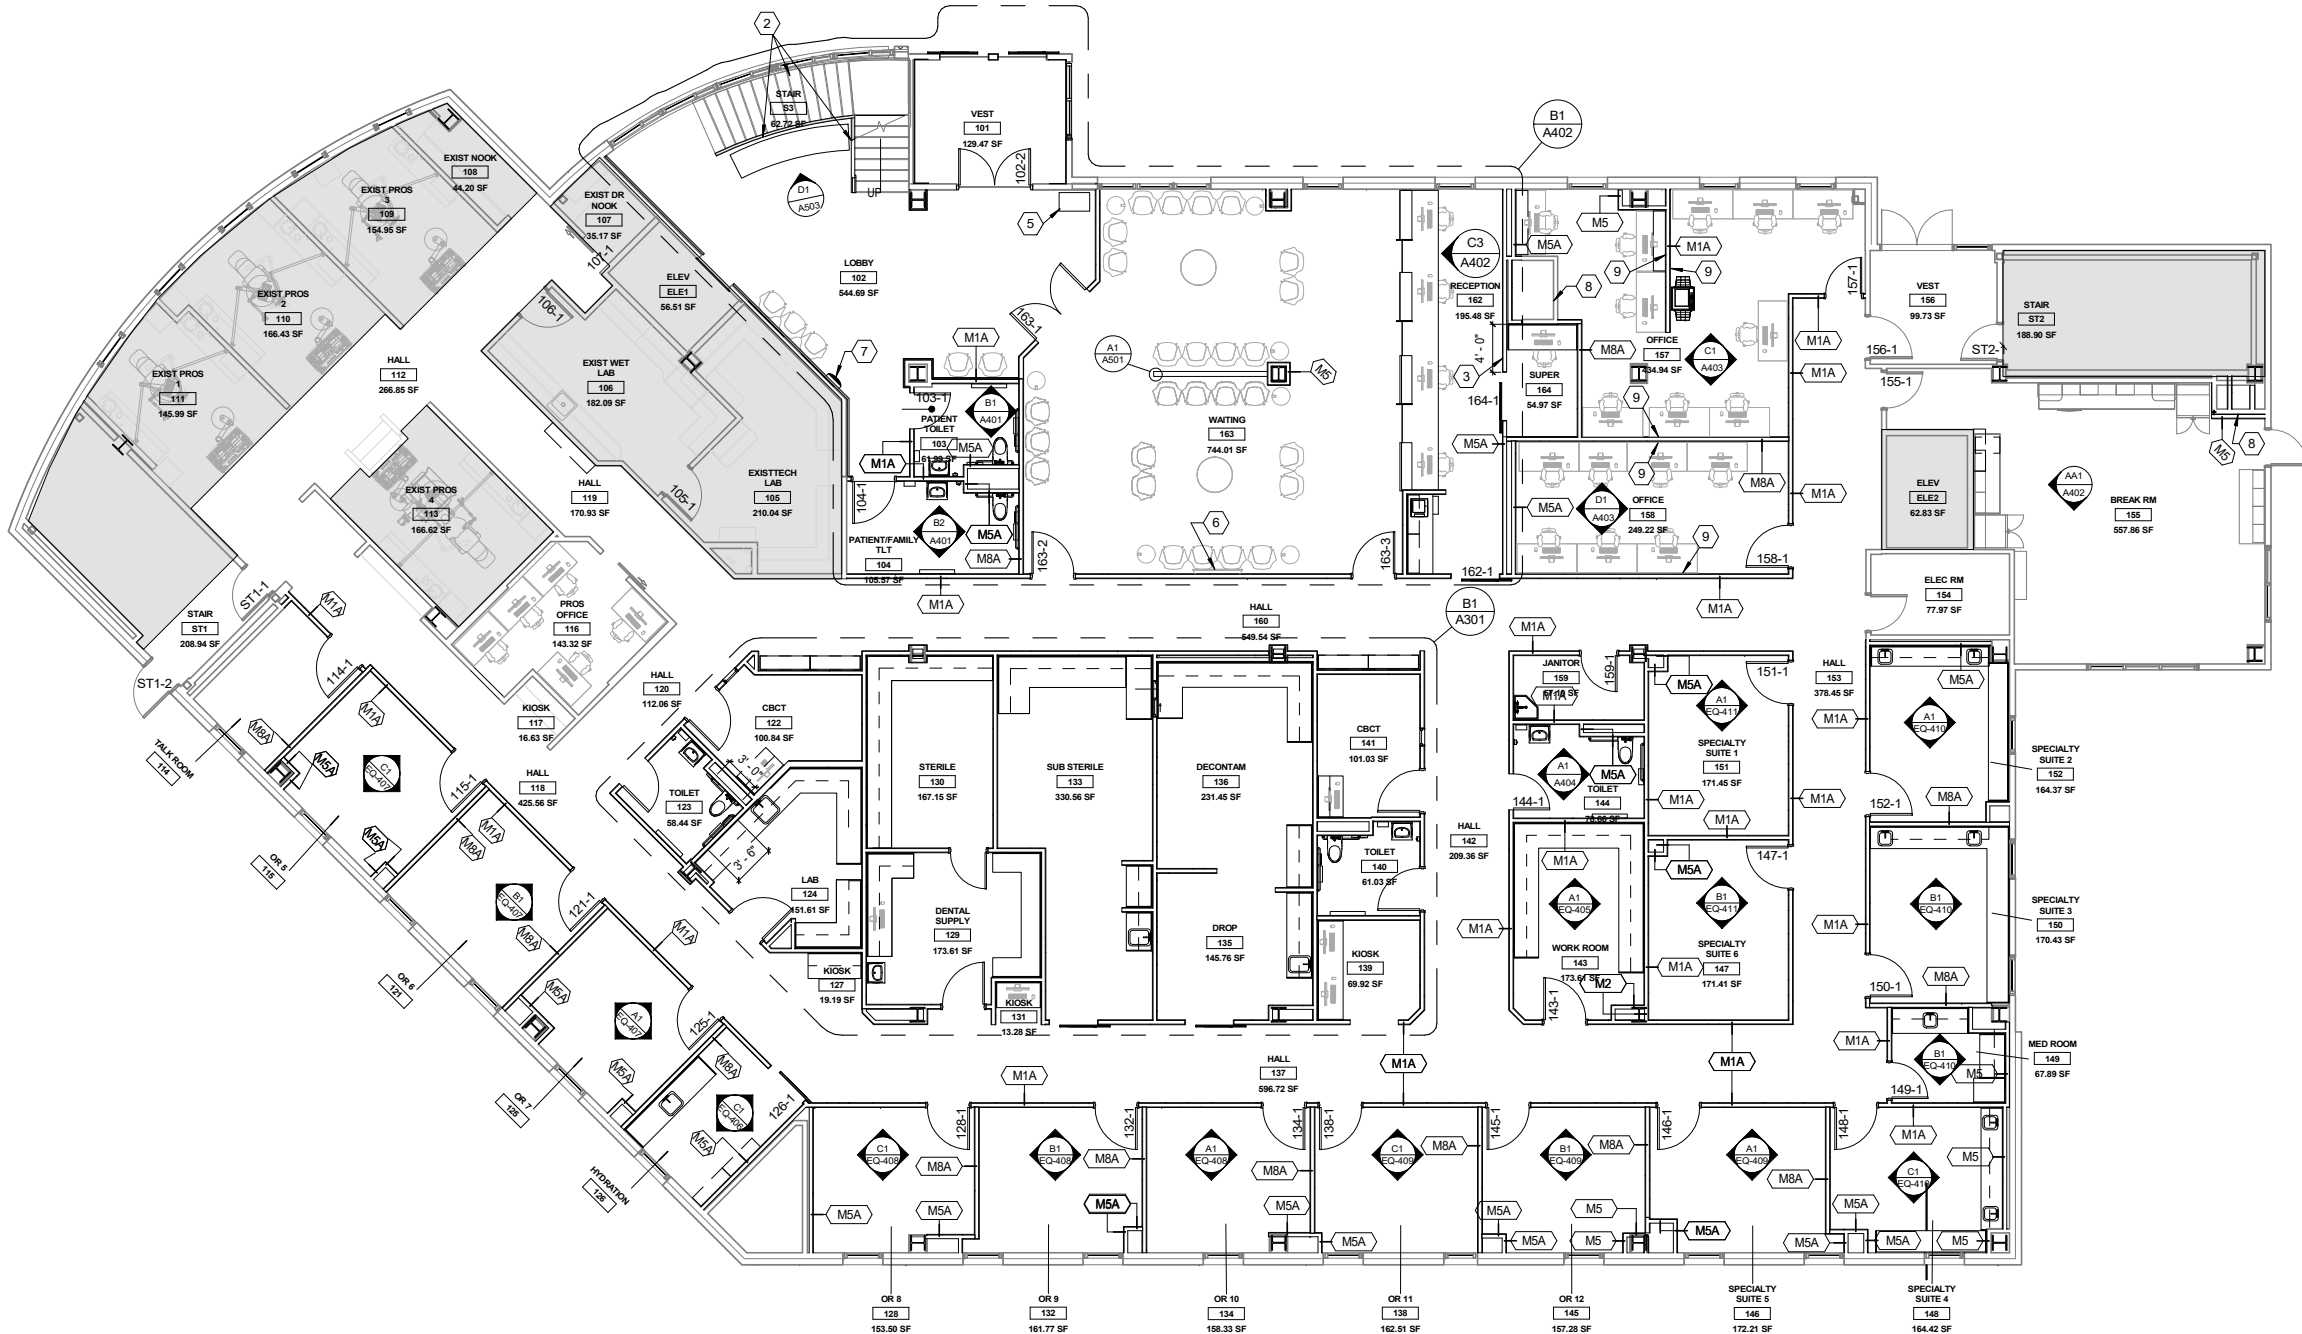

C1
A101 FIRST FLOOR LEVEL FLOOR PLAN
1/8" = 1'-0"

**Architects
Alaska.**
ARCHITECTS ALASKA
AK Corp. Authorization AECC561
900 W. 5th Avenue, Suite 403
Anchorage, Alaska 99501-2029
907.272.3567 907.277.1732 fax
191 E. Swanson Avenue, Suite 203
Wasilla, Alaska 99654-7025
907.373.7503 907.376.3166 fax
347 S. Ferguson Ave, Suite 3
Bozeman, Montana 59715
406.404.1588
www.architectsalaska.com

95%
CONSTRUCTION
DOCUMENTS

SOUTHCENTRAL FOUNDATION SCF FIREWEED BUILDING RENOVATION 4341 TUDOR CENTRE DR

Revisions

No.	Description	Date

Drawn by Author	Date 03/17/2023
Checked Checker	Job No. 21003.03

Sheet Contents
FIRST FLOOR LEVEL FLOOR PLAN

Sheet No.

A101